

DRAWING INDEX	
E-0101	DRAWING INDEX, GENERAL NOTES, ABBREVIATIONS, LEGEND & SYMBOLS
E-0201	POWER RISER DIAGRAM
E-0301	SITE UTILITIES AND LIGHTING LAYOUT, AUXILIARY POWER AND LIGHTING LAYOUT
E-0302	GROUND FLOOR POWER LAYOUT
E-0303	SECOND FLOOR POWER LAYOUT
E-0304	THIRD FLOOR POWER LAYOUT
E-0305	ROOF DECK POWER LAYOUT
E-0401	GROUND FLOOR LIGHTING LAYOUT
E-0402	SECOND FLOOR LIGHTING LAYOUT
E-0403	THIRD FLOOR LIGHTING LAYOUT
E-0404	ROOF DECK LIGHTING LAYOUT
E-0501	LIGHTNING PROTECTION SYSTEM RISER DIAGRAM, GROUND FLOOR GROUNDING AND ROOF DECK LIGHTNING PROTECTION SYSTEM LAYOUT
E-1001	SCHEDULE OF LOADS
E-1002	SCHEDULE OF LOADS
E-1003	SCHEDULE OF LOADS
E-3001	MISCELLANEOUS DETAILS
E-3002	MISCELLANEOUS DETAILS
E-3003	MISCELLANEOUS DETAILS

GENERAL NOTES:

1. ALL ELECTRICAL INSTALLATION HEREIN SHALL BE DONE IN ACCORDANCE WITH THE PLANS/LAYOUTS, SPECIFICATIONS & STANDARDS, WITH PROVISIONS OF THE LATEST EDITION OF THE PHILIPPINE ELECTRICAL CODE, THE LOCAL RULES & REGULATIONS AND THE REQUIREMENTS OF THE LOCAL POWER COMPANY.
2. ALL ELECTRICAL WORKS HEREIN SHALL BE IMPLEMENTED BY EXPERIENCED AND SKILLED PERSONNEL UNDER THE SUPERVISION OF A DULY LICENSED ELECTRICAL ENGINEER. ALL WORKS SHALL BE CARRIED OUT AS PER HSSE (HEALTH/SAFETY/SECURITY/ENVIRONMENT) STANDARDS.
3. ELECTRICAL SERVICE VOLTAGE IS 400V, 3-PHASE, 4-WIRE PLUS GROUND, 60 Hz.
4. ALL MATERIALS AND EQUIPMENT TO BE USED SHALL BE NEW AND SHALL CONFORM TO THE LATEST PROVISIONS OF APPLICABLE STANDARDS.
5. MINIMUM CONDUCTOR SIZE FOR LIGHTING AND POWER OUTLET SHALL BE 3.5mm2 THHN/THWN-2.
6. ALL EMBEDDED CONDUITS SHALL BE PVC, EXPOSED CONDUITS SHALL USE IMC OR EMT WITH COMPRESSION TYPE FITTINGS AND SERVICE ENTRANCE SHALL USE RSC. ALL CONDUITS SHALL BE PROPERLY SUPPORTED OR ANCHORED FOR PERMANENT CONNECTION WITH CONCRETE WALLING OR BEAM.
7. CONDUITS SHALL BE PROTECTED AGAINST DAMAGE DURING CONSTRUCTION. ALL ENDS SHALL BE PLUGGED TO PREVENT WATER INGRESS AND PRESENCE OF MOISTURE AND FOREIGN MATERIALS AFTER INSTALLATION.
8. THE MAXIMUM NUMBER OF CONDUCTORS IN TRADE SIZES OF CONDUITS SHALL BE AS FOLLOWS:

CABLE SIZES		MAXIMUM NUMBER OF CONDUCTORS IN CONDUIT			
mmØ	mm²	20mmØ PVC	25mmØ PVC	32mmØ PVC	50mmØ PVC
		15mmØ PVC	20mmØ PVC	25mmØ PVC	32mmØ PVC
1.6	2.0	4	6	10	18
2.0	3.5	3	5	8	15
2.6	5.5	1	4	7	13
	8.0	1	3	4	7
	14	1	1	3	4

9. ALL BRANCH CIRCUITS SHALL BE PROVIDED WITH ADDITIONAL GROUND IN ACCORDANCE WITH THE PHILIPPINE ELECTRICAL CODE TABLE 2.50.6.13 PEC 2017 PART 1 VOL 1 UNLESS OTHERWISE SPECIFIED, INCLUDING WIRING FROM CONTROLLER TO THE EQUIPMENT.
10. ELECTRICAL TRADE SIZE SHALL BE USED, A MINIMUM OF 15mmØ FOR CONDUITS AND IN NO CASE SHALL THERE BE MORE THAN FOUR QUARTER BENDS IN ONE RUN. IN CASE OF MORE THAN FOUR QUARTER BENDS, PULLBOX SHALL BE PROVIDED.
11. TRADE CONTRACTORS SHALL PROVIDE CONTROLLERS FOR ELECTRICALLY OPERATED EQUIPMENT E.G. FIRE PROTECTION AND SANITARY SYSTEM AND OTHER SPECIAL SYSTEMS INCLUDING WIRING FROM CONTROLLER TO THE EQUIPMENT.
12. ALL SERVICE EQUIPMENT, SWITCHGEARS, PANELBOARDS, ECB AND NON-CURRENT CARRYING METAL PARTS SHALL BE PROPERLY GROUNDED IN ACCORDANCE WITH THE PHILIPPINE ELECTRICAL CODE.
13. THE FOLLOWING TESTS SHALL BE PERFORMED INCLUSIVE OF THE INSTALLATION TO BE SUBMITTED IN DETAILS:
A)INSULATION RESISTANCE TEST, 500VDC
B)GROUND RESISTANCE TEST (5 OHMS)
C)OPERATIONAL TEST
D)PHASE SEQUENCE TEST
E)SYSTEM TEST
14. COLOR CODING OF WIRES SHALL BE AS FOLLOWS:
LINE 1 – RED NEUTRAL – WHITE
LINE 2 – YELLOW GROUND – GREEN
LINE 3 – BLUE CONTROL – BLACK
15. ALL RACEWAYS, WALL AND FLOOR PENETRATIONS SHALL BE PROVIDED WITH FIRE BARRIER OR FIRE RATED SEALANT.
16. ALL OUTDOOR BOXES/EQUIPMENT SHALL USE WEATHERPROOF TYPE ENCLOSURES.
17. A PLASTIC HOLDER OR JACKET DIRECTORY SHALL BE PROVIDED FOR EACH PANELBOARD INDICATION SINGLE LINE DIAGRAM AND LOAD SCHEDULE.
18. ALL ELECTRICAL CIRCUITS SHALL BE WIRED ACCORDING TO THE LOAD SCHEDULE AND SINGLE LINE DIAGRAM.
19. ALL EXIT LIGHTS AND EMERGENCY LIGHTS SHALL BE WIRED AHEAD OF THE LOCAL SWITCH AND SHALL BE OF GROUNDING TYPE.
20. SURFACE MOUNTED CONDUITS SHALL BE SUPPORTED AND SECURED BY C-CHANNELS, CLAMP OR U-BOLT.
21. SWITCHES SHALL BE RATED 15 AMPS, 300 VOLTS AND CONVENIENCE OUTLET SHALL BE WITH GROUNDING CONNECTION AND A QUICK CONNECT TYPE.
22. TERMINATION SHALL BE MADE USING 3M SPRING CONNECTORS OR EQUIVALENT, FOR SPLICING OF WIRES (LIGHTING SWITCH AND POWER OUTLET).
23. PULLBOXES SHALL HAVE DEDICATED BRANCH CIRCUIT RUNS AND SHALL NOT BE SHARED WITH OTHER CIRCUITS.

MOUNTING HEIGHTS:


PANELBOARD	1900mm FROM TOP OF PANEL TO FLOOR FINISH
CONVENIENCE OUTLET	300mm FROM CENTER OF DEVICE TO FLOOR FINISH, 300mm FROM CENTER OF DEVICE TO COUNTER TOP (VERIFY ACTUAL)
WALL SWITCHES, ENCLOSED	1400mm FROM CENTER OF DEVICE TO FLOOR FINISH
CIRCUIT BREAKERS	

ABBREVIATION			
MCB	MINIATURE CIRCUIT BREAKER	ATS	AUTOMATIC TRANSFER SWITCH
MCCB	MOLDED CASE CIRCUIT BREAKER	AT	AMPERE TRIP
ECB	ENCLOSED CIRCUIT BREAKER	AF	AMPERE FRAME
ACCU	AIR COOLED CONDENSING UNIT	CO	CONVENIENCE OUTLET
EF	EXHAUST FAN	MW	MICROWAVE (GFCI)
LED	LIGHT EMITTING DIODE	REF	REFRIGERATOR (GFCI)
SL	STRIP LIGHTS	WD	WATER DISPENSER
THHN	HEAT RESISTANT THERMOPLASTIC WIRE	WP	WEATHERPROOF
DP	DISTRIBUTION PANELBOARD	IMC	INTERMEDIATE METAL CONDUIT
PP	POWER PANELBOARD	PVC	POLYVINYL CHLORIDE CONDUIT
ATS	AUTOMATIC TRANSFER SWITCH	RSC	RIGID STEEL CONDUIT
GFCI	GROUND FAULT CIRCUIT INTERRUPTER	RDL	ROOF DECK LIGHTS
SL	STRIP LIGHTS	FL	FENCE LIGHTS
DPM	DIGITAL POWER METER	CM	CEILING MOUNTED


LEGENDS & SYMBOLS:

SINGLE LINE DIAGRAM/POWER RISER	
	SERVICE ENTRANCE
	CIRCUIT BREAKER, RATING AS INDICATED
	DISCONNECTING MEANS BREAKER (ENCLOSED CIRCUIT BREAKER)
	GROUND BAR
	KILOWATT-HOUR METER
	MOTOR LOAD
	MOTOR CONTROLLER
POWER	
	DUPLEX CONVENIENCE OUTLET, 15A, 240V, WALL OR TABLE MOUNTED
	DUPLEX CONVENIENCE OUTLET, 15A, 240V, OUTDOOR WEATHERPROOF, WALL MOUNTED
	SIMPLEX CONVENIENCE OUTLET, 15A, 240V
	DUPLEX CONVENIENCE OUTLET, 15A, 240V, FLOOR MOUNTED
	SPECIAL PURPOSE CONVENIENCE OUTLET, 20A, 240V
	POWER PANELBOARD
	JUNCTION BOX
	PULLBOX
	CIRCUIT HOMERUN xxx-xx — CIRCUIT NO. └ FLOOR PANEL LOCATION TYPE OF PANEL: POWER (PP), DISTRIBUTION (DP)
	CIRCUIT RUN CONCEALED IN WALL & CEILING
	CIRCUIT RUN EMBEDDED IN FLOOR SLAB, CEILING SLAB, CONCRETE WALL
	RISER UP
	RISER DOWN
	MOTOR LOAD
	FAN COIL UNIT
	AIR COOLED CONDENSING UNIT


LIGHTING	
	1x9W LED SUSPENDED OR SURFACE MOUNTED DOWNLIGHT
	1x15W LED T-5 SUSPENDED OR SURFACE MOUNTED INDUSTRIAL LIGHTING ALUMINUM REFLECTOR AND SPECULAR LOUVER
	2x15W T-5 RECESSED MOUNTED LED LAMP WITH CENTRAL LOUVER & WHITE POWDER COATED BACKING REFLECTOR, ZINC PHOSPHATED STEEL SHEET HOUSING WITH POWDER COAT PAINT FINISH, MIRROR FINISH ANODIZED ALUMINUM REFLECTOR & SPECULAR LOUVER
	14W LED LAMP COVELIGHT
	1x9W LED 160mmx160mmx31mm THICK WALL LUMINAIRE
	1x9W LED 140mmx140mmx350mm HIGH POST LUMINAIRE
	BOLLARD LIGHT
	FOCAL FLOOR LIGHTS
	IN GROUND LUMINAIRES
	RECESSED FLOOR LUMINAIRES
	LIGHT POLE
	BATTERY PACK EMERGENCY LIGHTS WITH 1x8W LED LAMP, NICKEL CADMIUM, 3 HOURS DURATION
	CEILING MOUNTED EXIT SIGNAGE WITH 2W LED LUMINAIRE COMPLETE WITH EMERGENCY BATTERY PACK, 3 HOURS DURATION
	ELEVATOR SHAFT LIGHTING
	1-GANG SWITCH
	2-GANG SWITCH
	3-GANG SWITCH
	1-GANG 3 WAY SWITCH
GROUNDING	
	50mm² BARE COPPER SOFT DRAWN WIRE
	INSULATED COPPER, GREEN PVC SIZE: 100mm² 80mm² 60mm² 50mm² 38mm² 30mm² 14mm² 8.0mm² 5.5mm² 3.5mm² 2.0mm²
	GROUND ROD
	GROUND TEST PIT
	EQUIPMENT GROUNDING

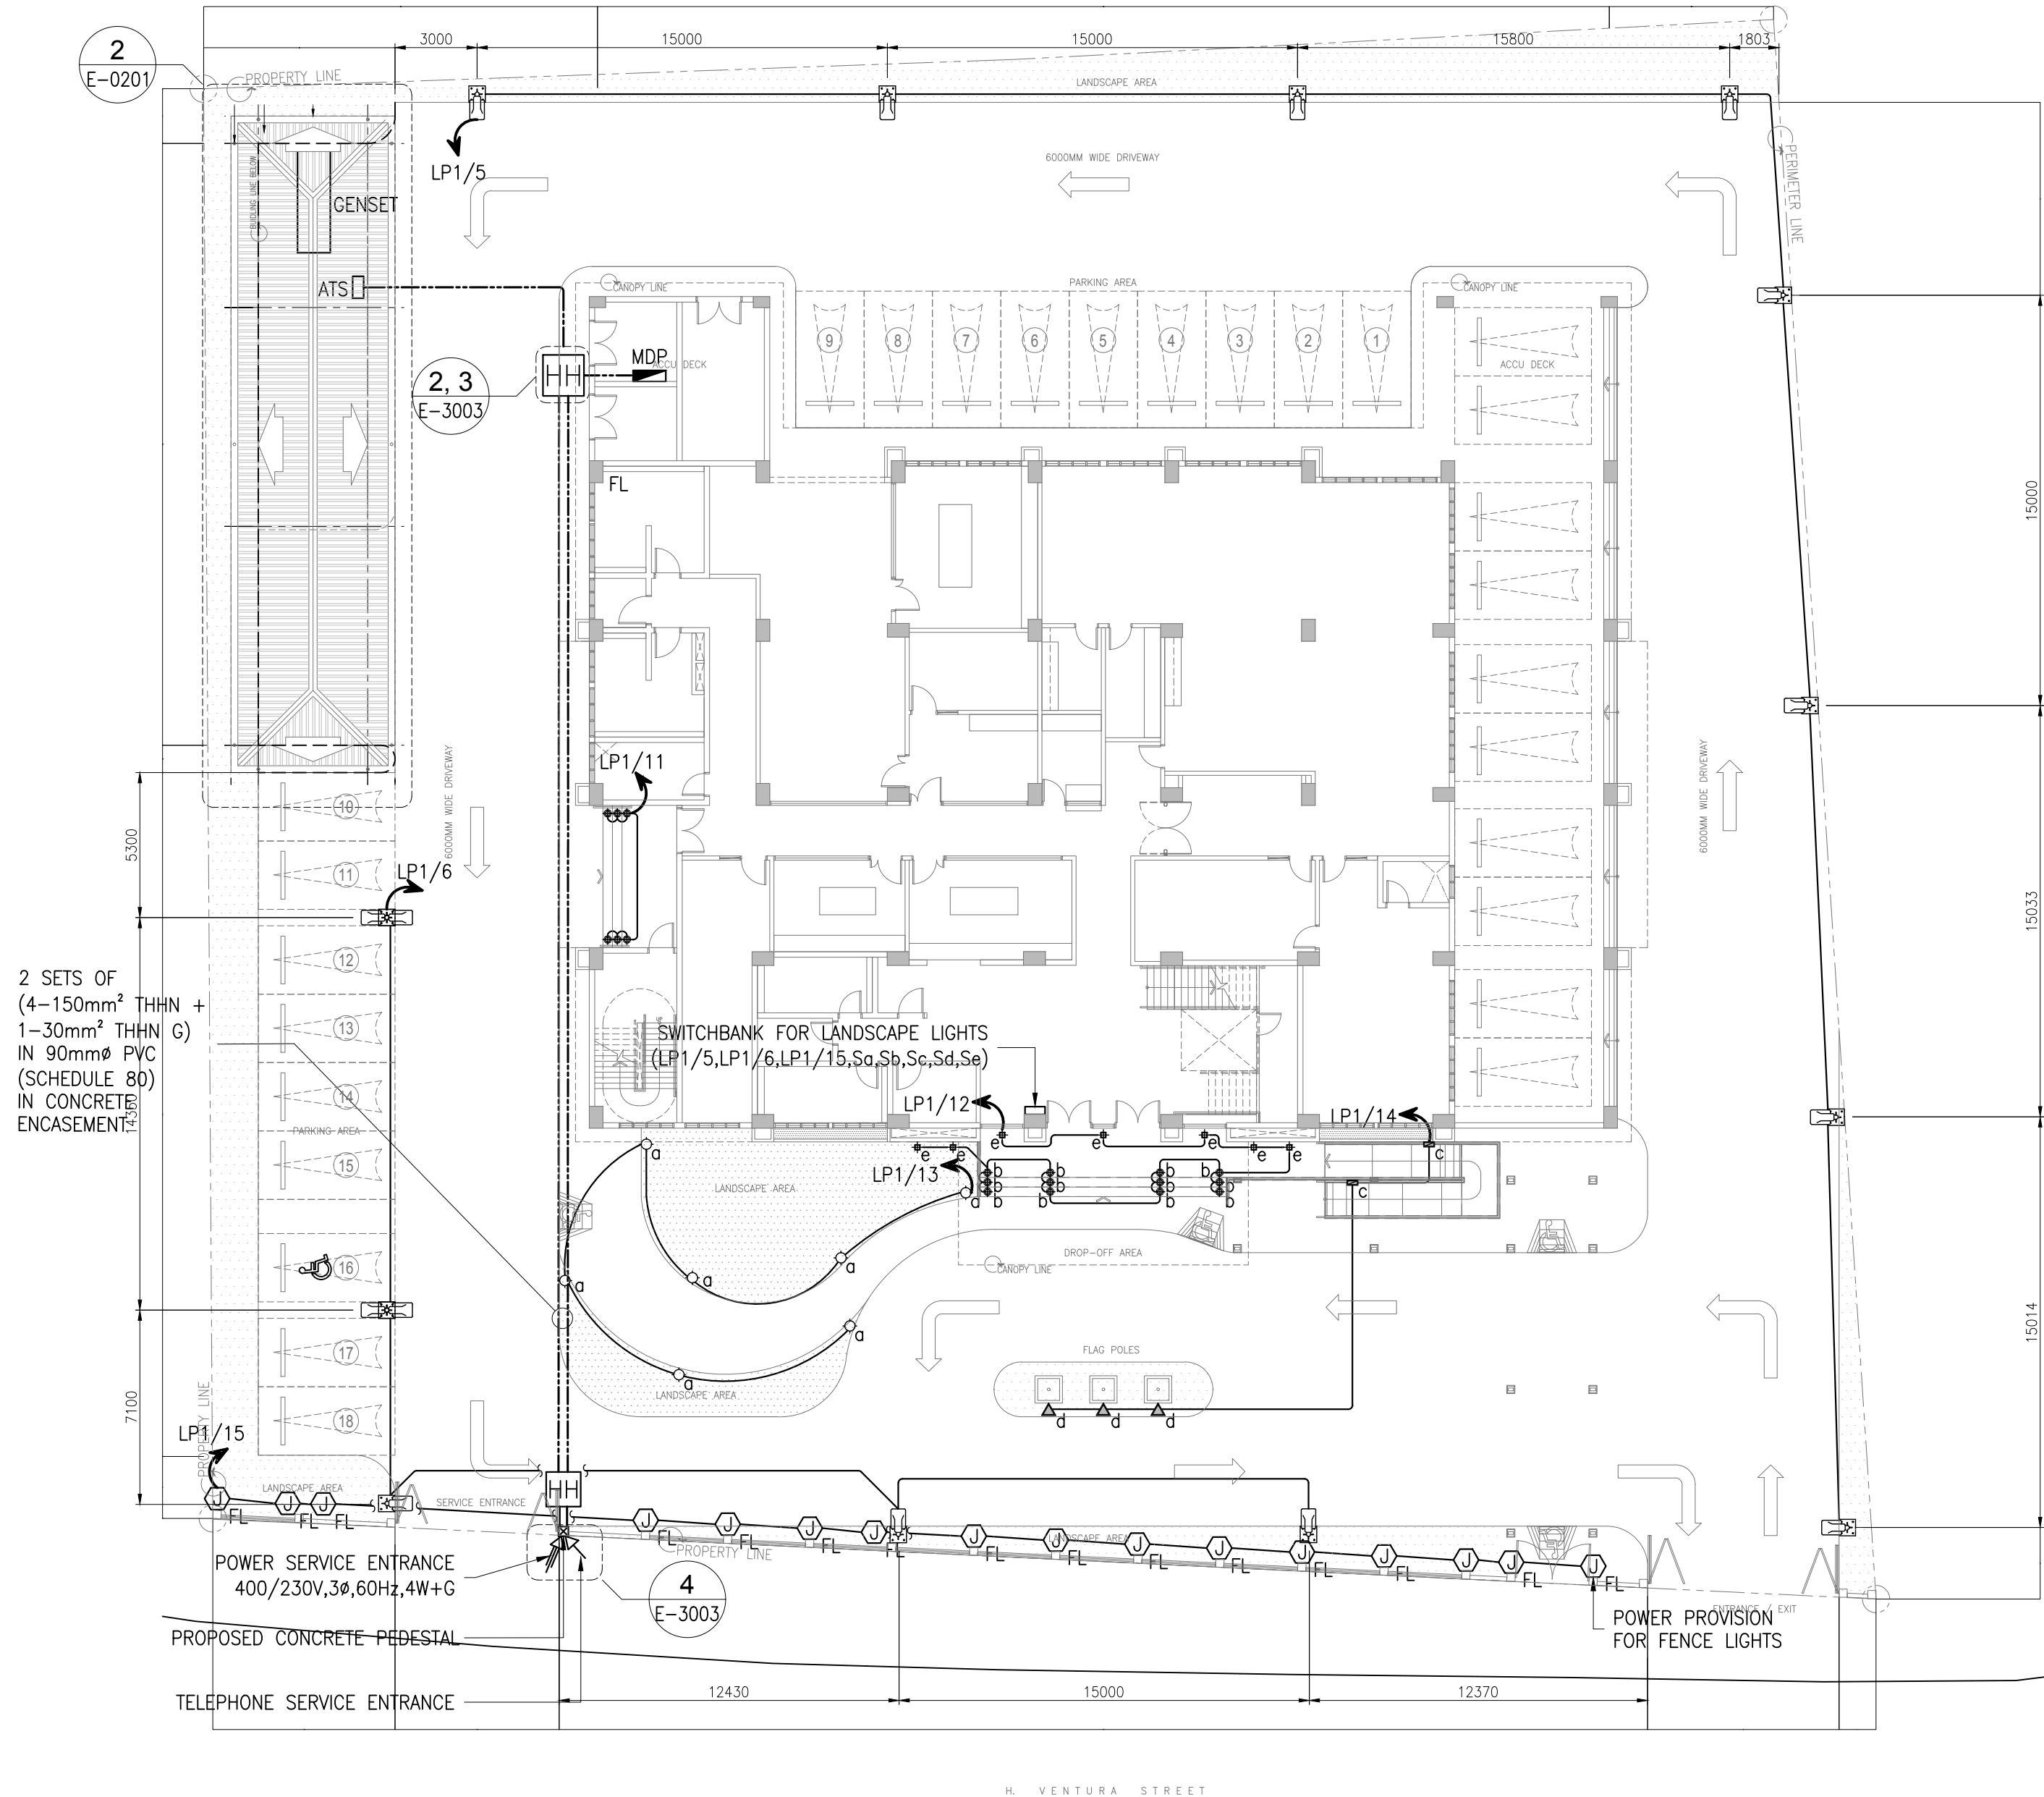


1 SITE UTILITIES AND LIGHTING LAYOUT
E-0301 SCALE 1:200M

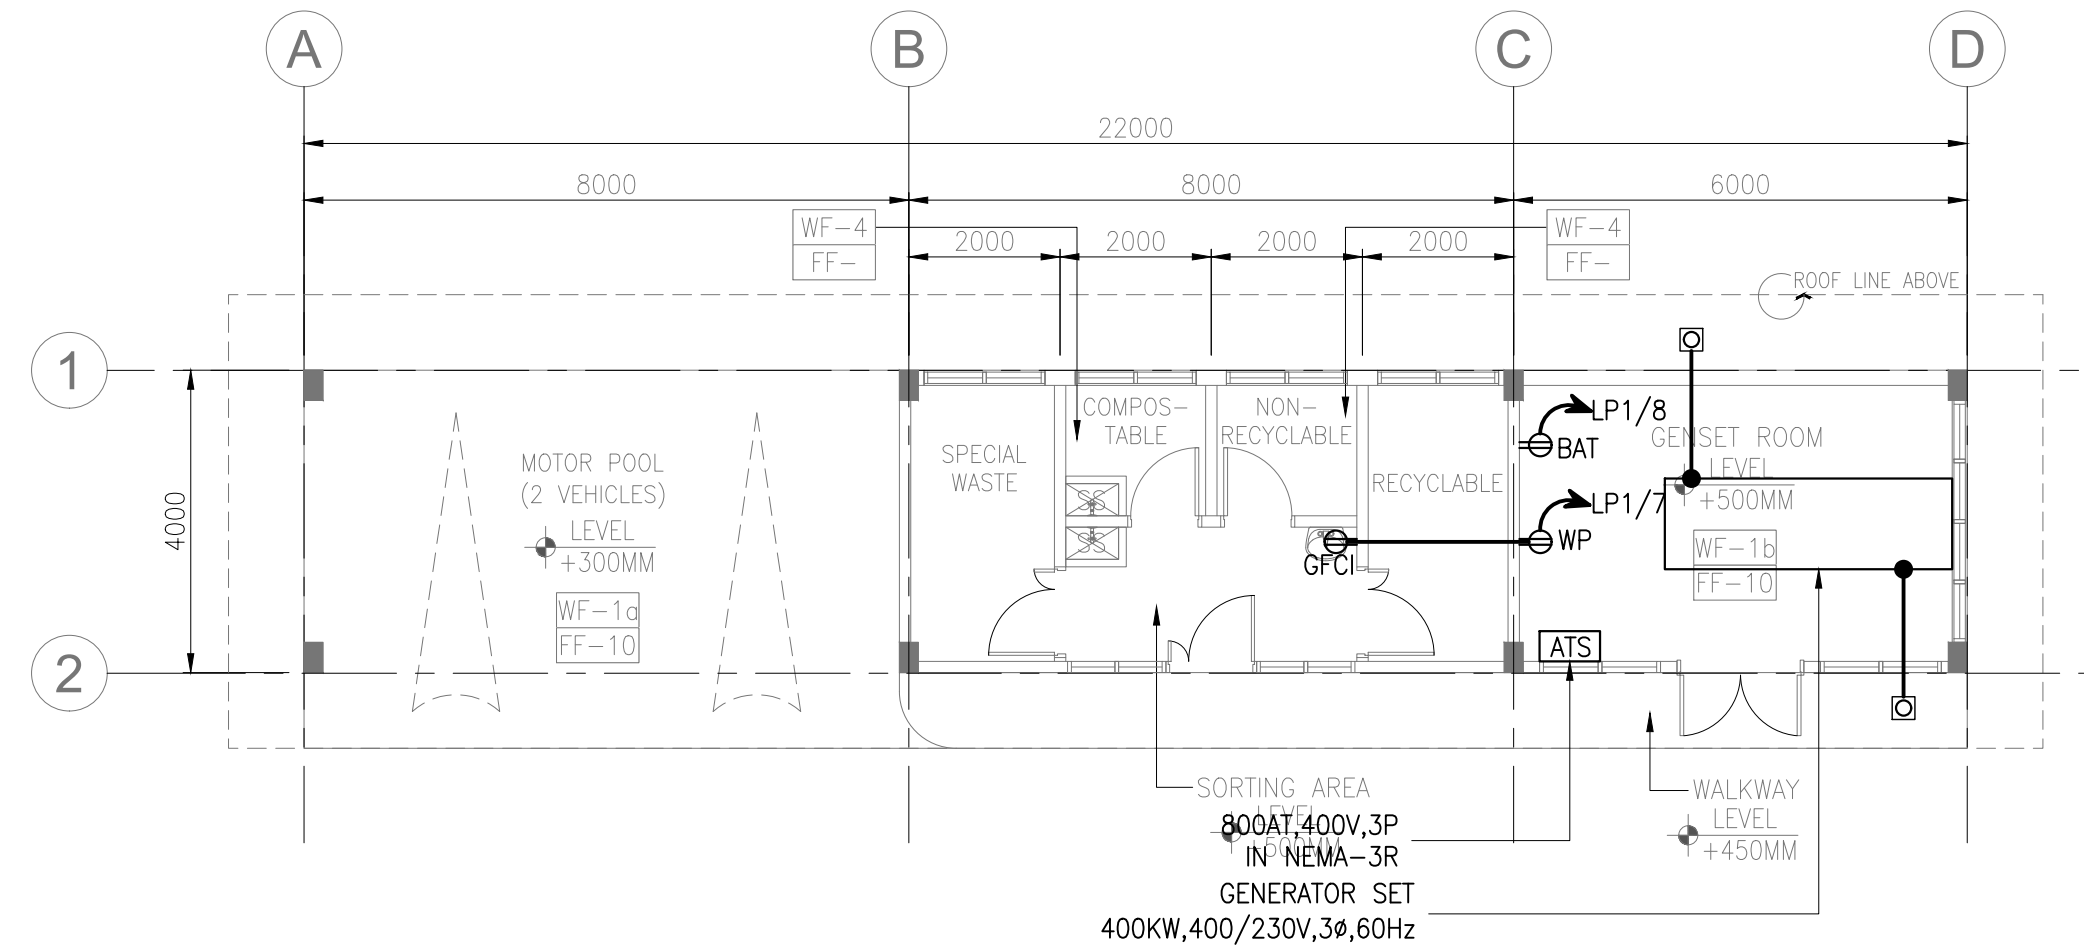


2 AUXILIARY POWER LAYOUT
E-0301 SCALE 1:100M

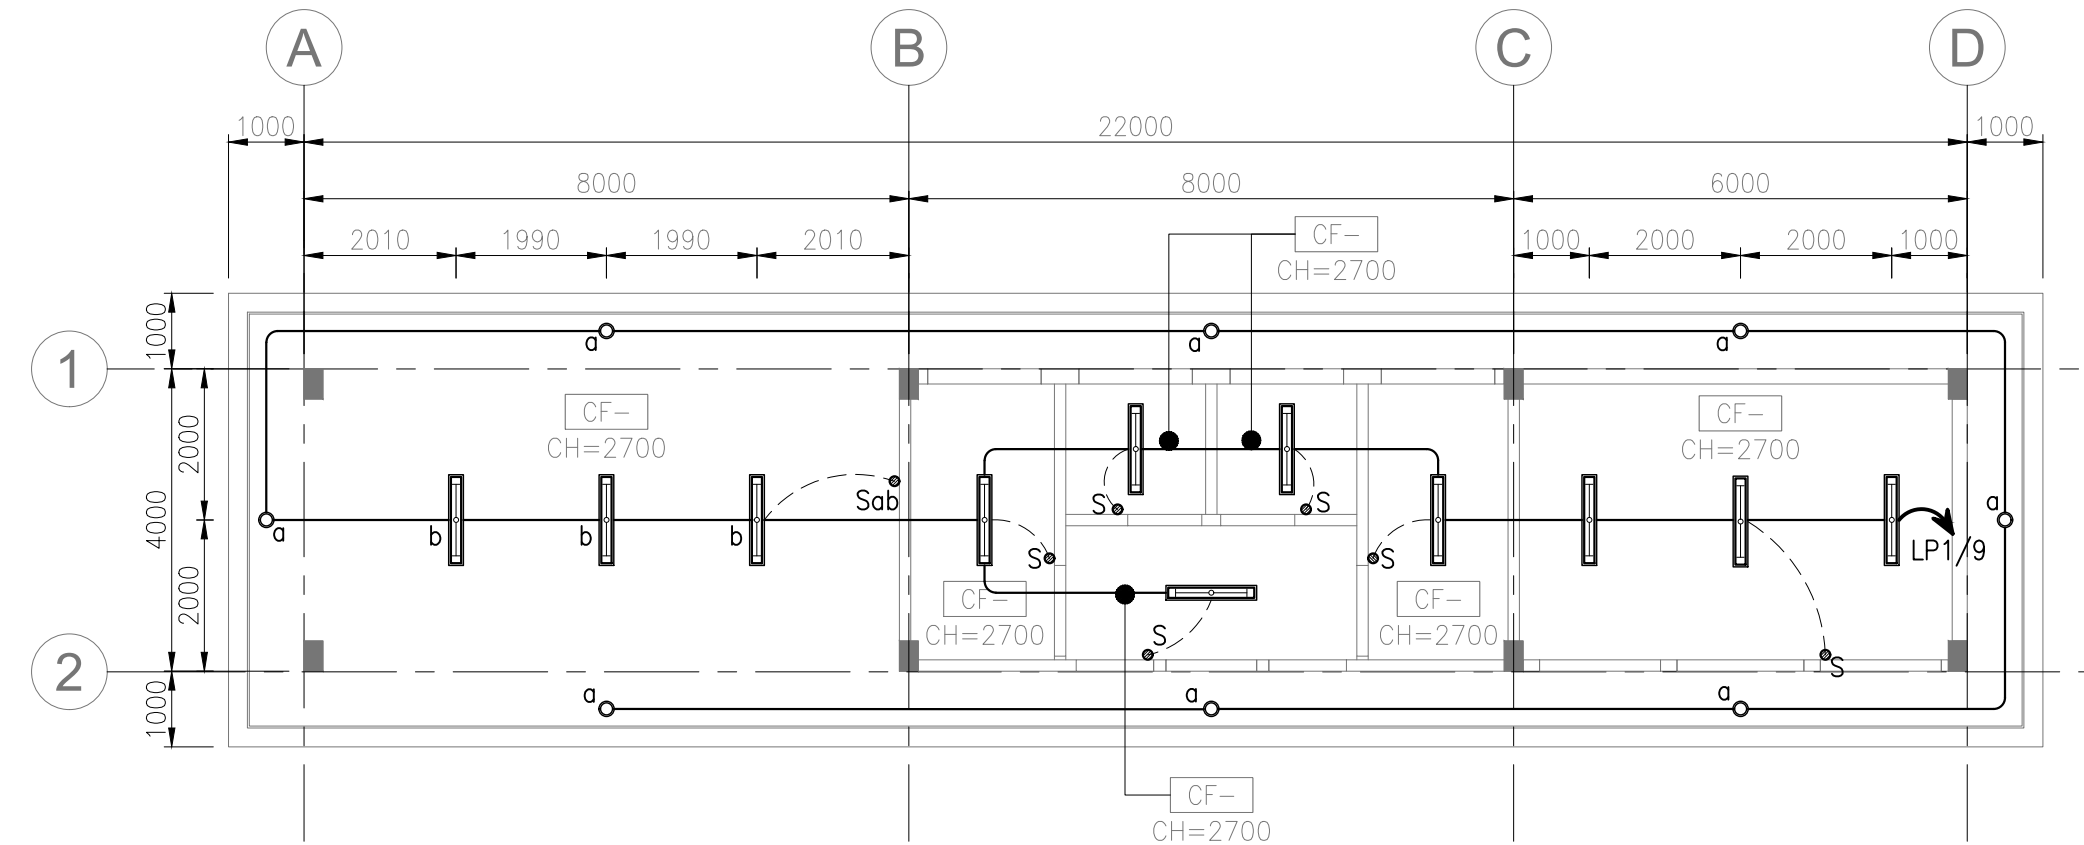


3 AUXILIARY LIGHTING LAYOUT
E-0301 SCALE 1:100M

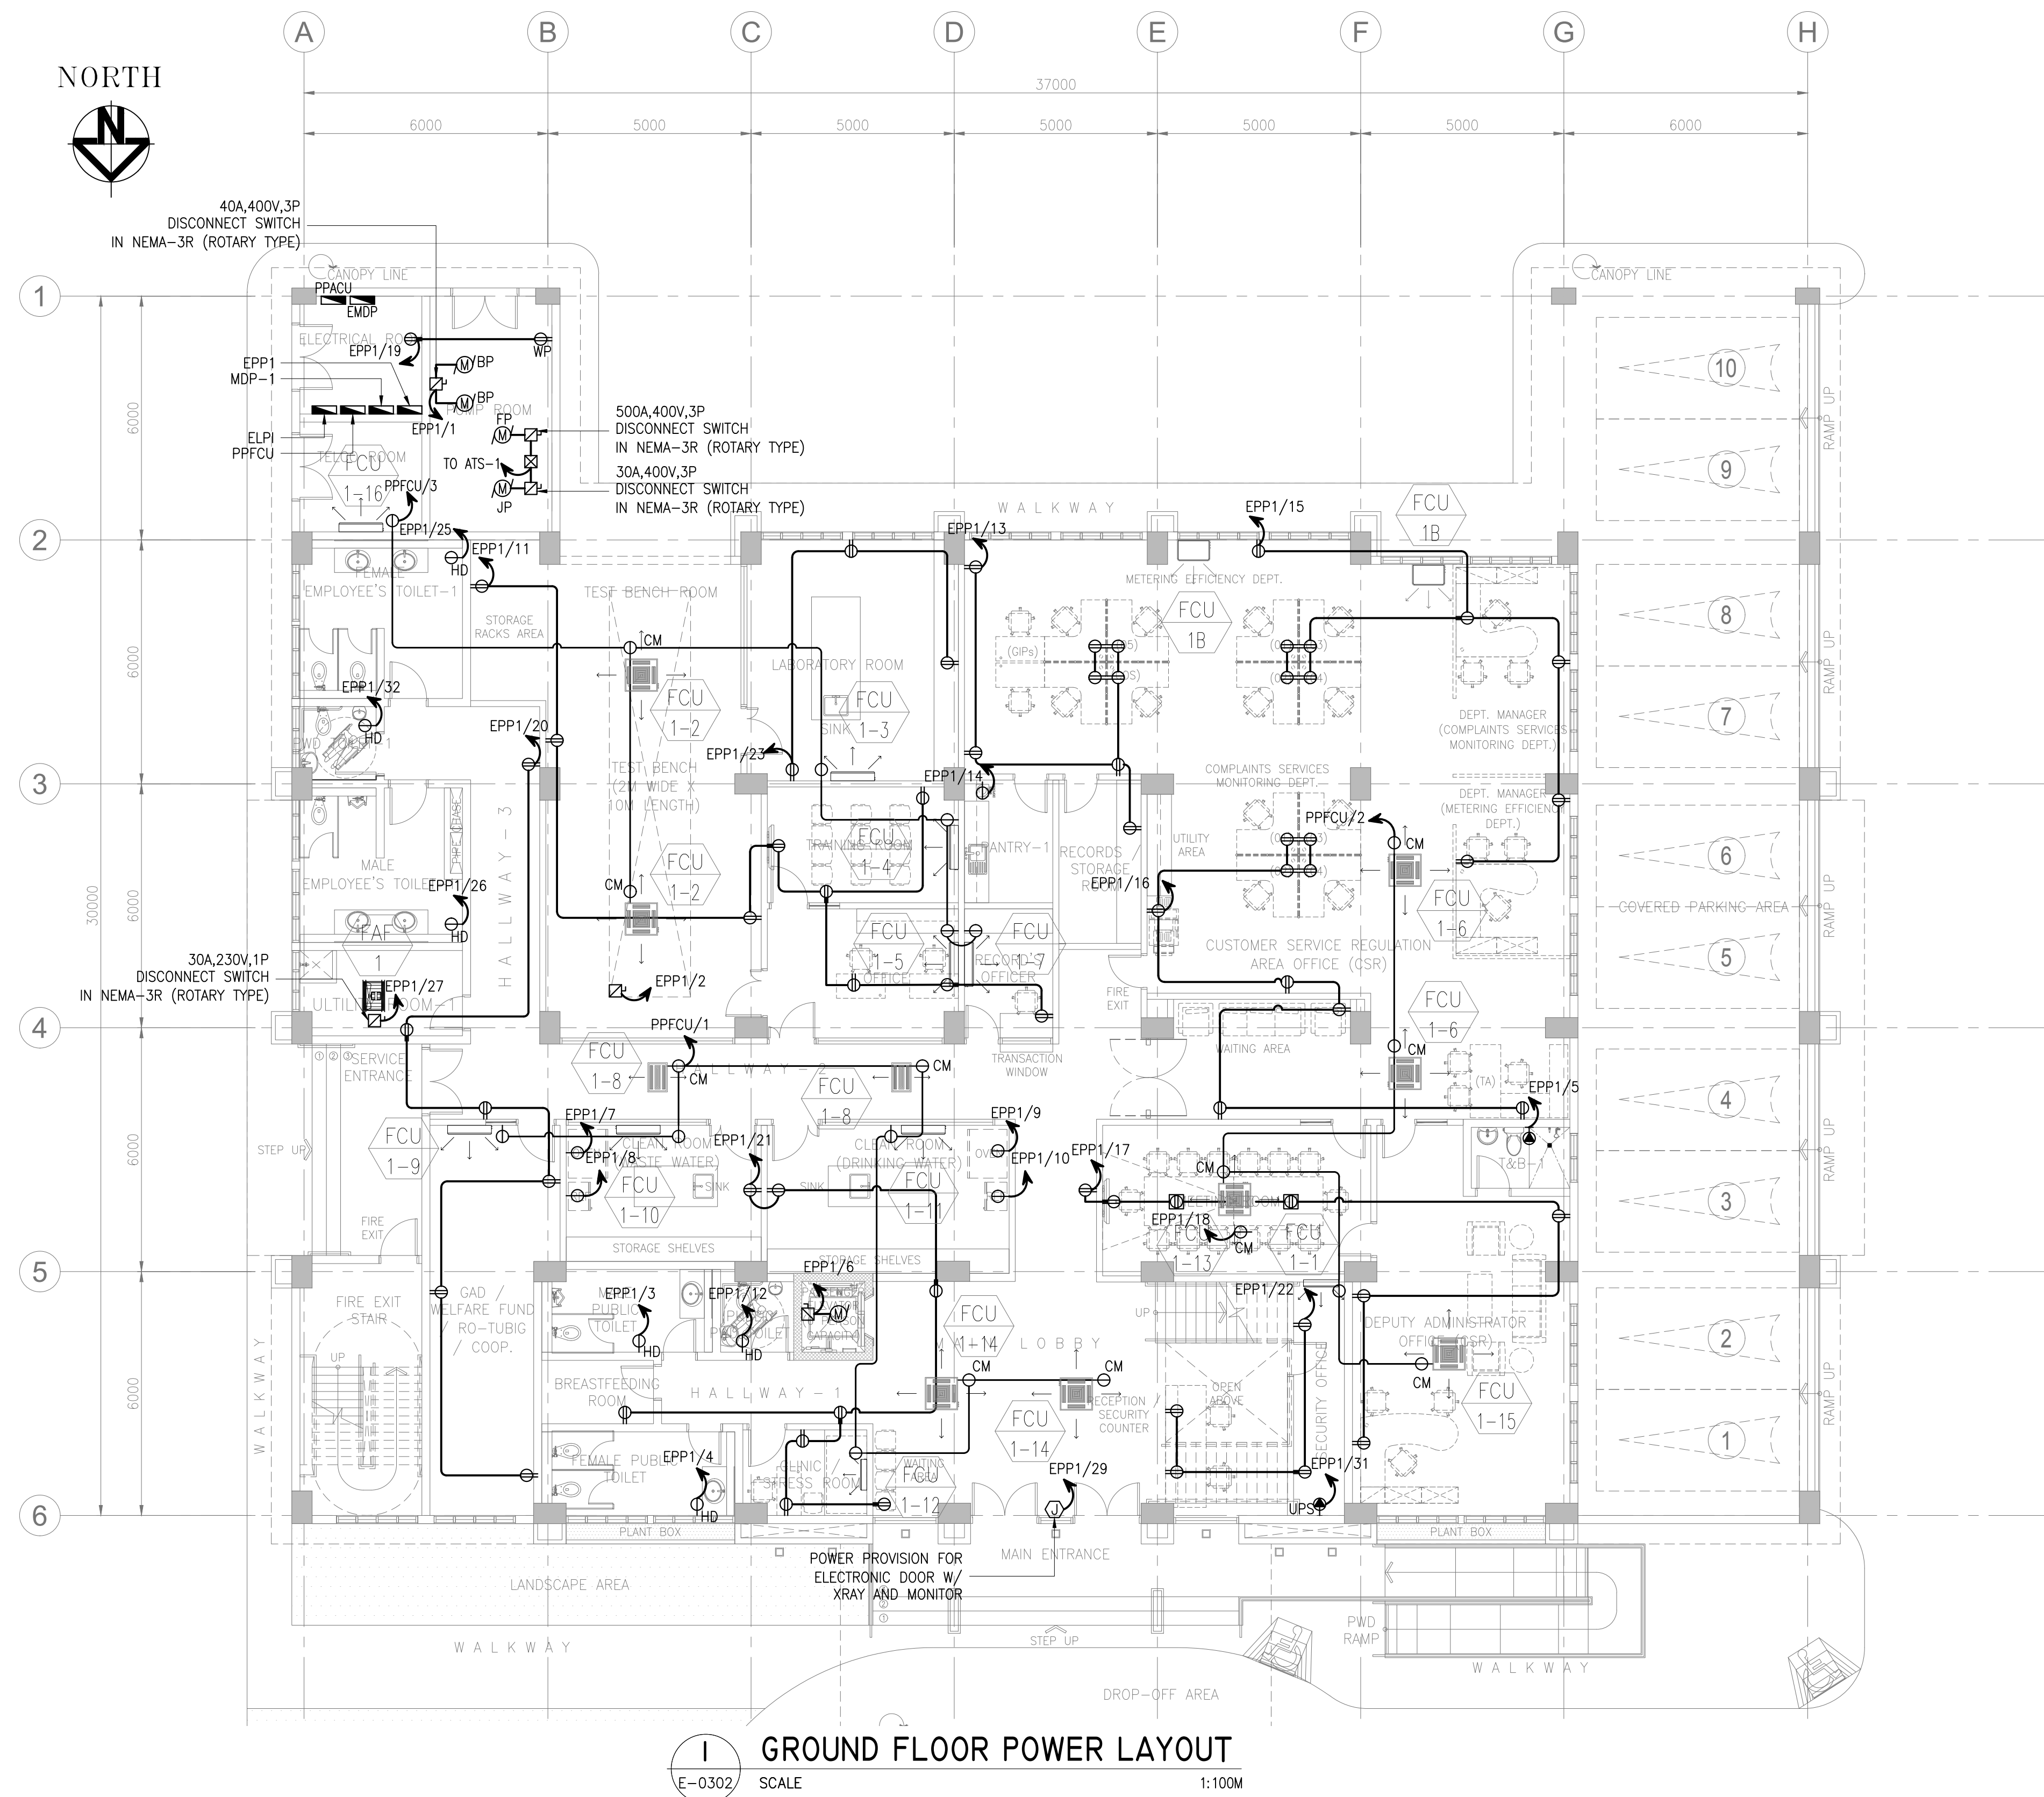

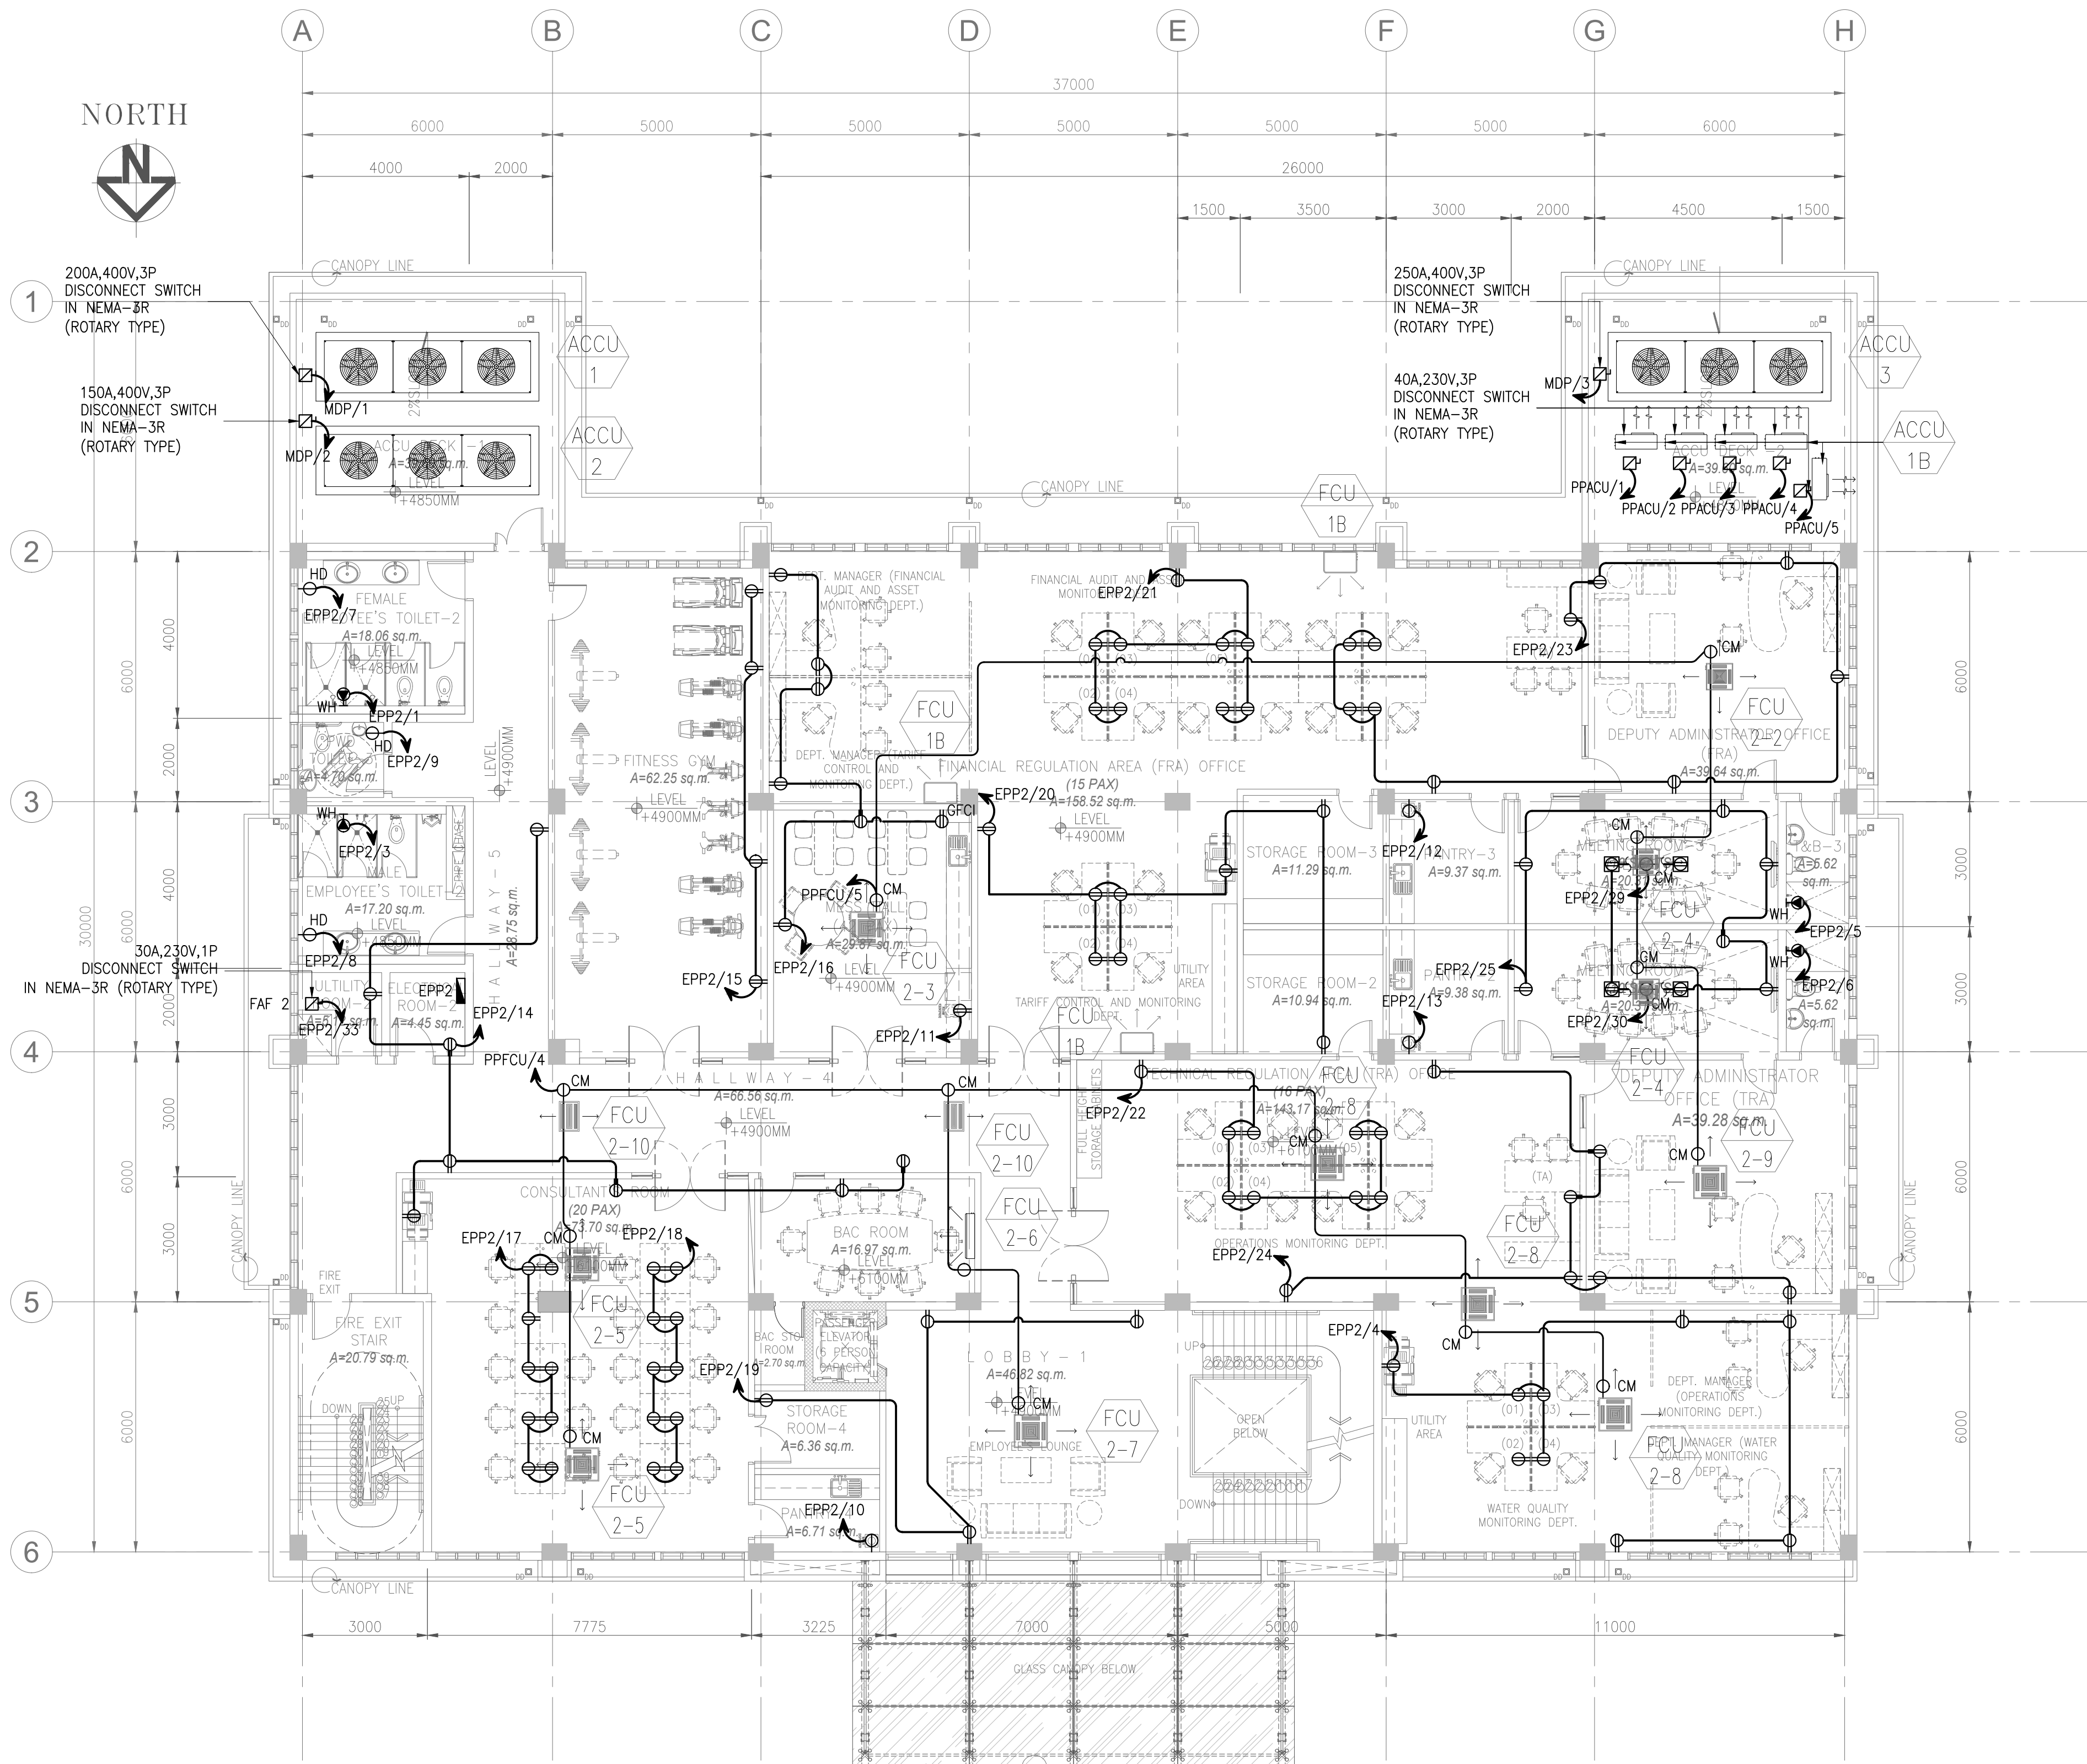


1 SECOND FLOOR POWER LAYOUT
E-0303 SCALE 1:100M

CERTIFIED BY	OWNER	PROJECT TITLE/LOCATION	CLIENT	SHEET CONTENTS	R.A. 9266 SEC. 33	CADD	DATE	NO.	REVISIONS	CHK	DATE	PAPER SIZE	SHEET NO.
RODEL JOSELITO B. MANABAT PROFESSIONAL ELECTRICAL ENGINEER	METROPOLITAN WATERWORKS AND SEWERAGE SYSTEM REGULATORY OFFICE	3-STOREY OFFICE BUILDING WITH ROOF DECK	PROJECT PROPONENT MELCHOR S. CORDOVA ALTERNATE END-USER FOR RO BUILDING	APPROVED BY: PATRICK LESTER N. TY CHIEF REGULATOR, MWSS RO	SECOND FLOOR POWER LAYOUT	DRAWINGS AND SPECIFICATIONS AND CONTRACT DOCUMENTS DULY SIGNED, STAMPED OR SEALED AS INSTRUMENTS FOR SERVICE ARE THE INTELLECTUAL PROPERTY AND DOCUMENTS OF ARCHITECT, WHETHER THE OBJECT FOR WHICH THEY ARE MADE IS EXECUTED OR NOT. IT SHALL BE UNLAWFUL FOR ANY PERSON TO DUPLICATE OR TO MAKE COPIES OF SAID DOCUMENTS FOR USE IN THE REPETITION OF AND FOR OTHER PROJECTS OR BUILDINGS, WHETHER EXECUTED PARTLY OR IN WHOLE, WITHOUT THE WRITTEN CONSENT OF THE ARCHITECT OR AUTHOR OF SAID DOCUMENTS.	AVL DESIGNED RRVP APPROVED RJB/M	JUL 2018 DATE JUL 2018 DATE JUL 2018				20X30 SCALE AS SHOWN	E-0303 PROJECT NO. SO-G-17-036

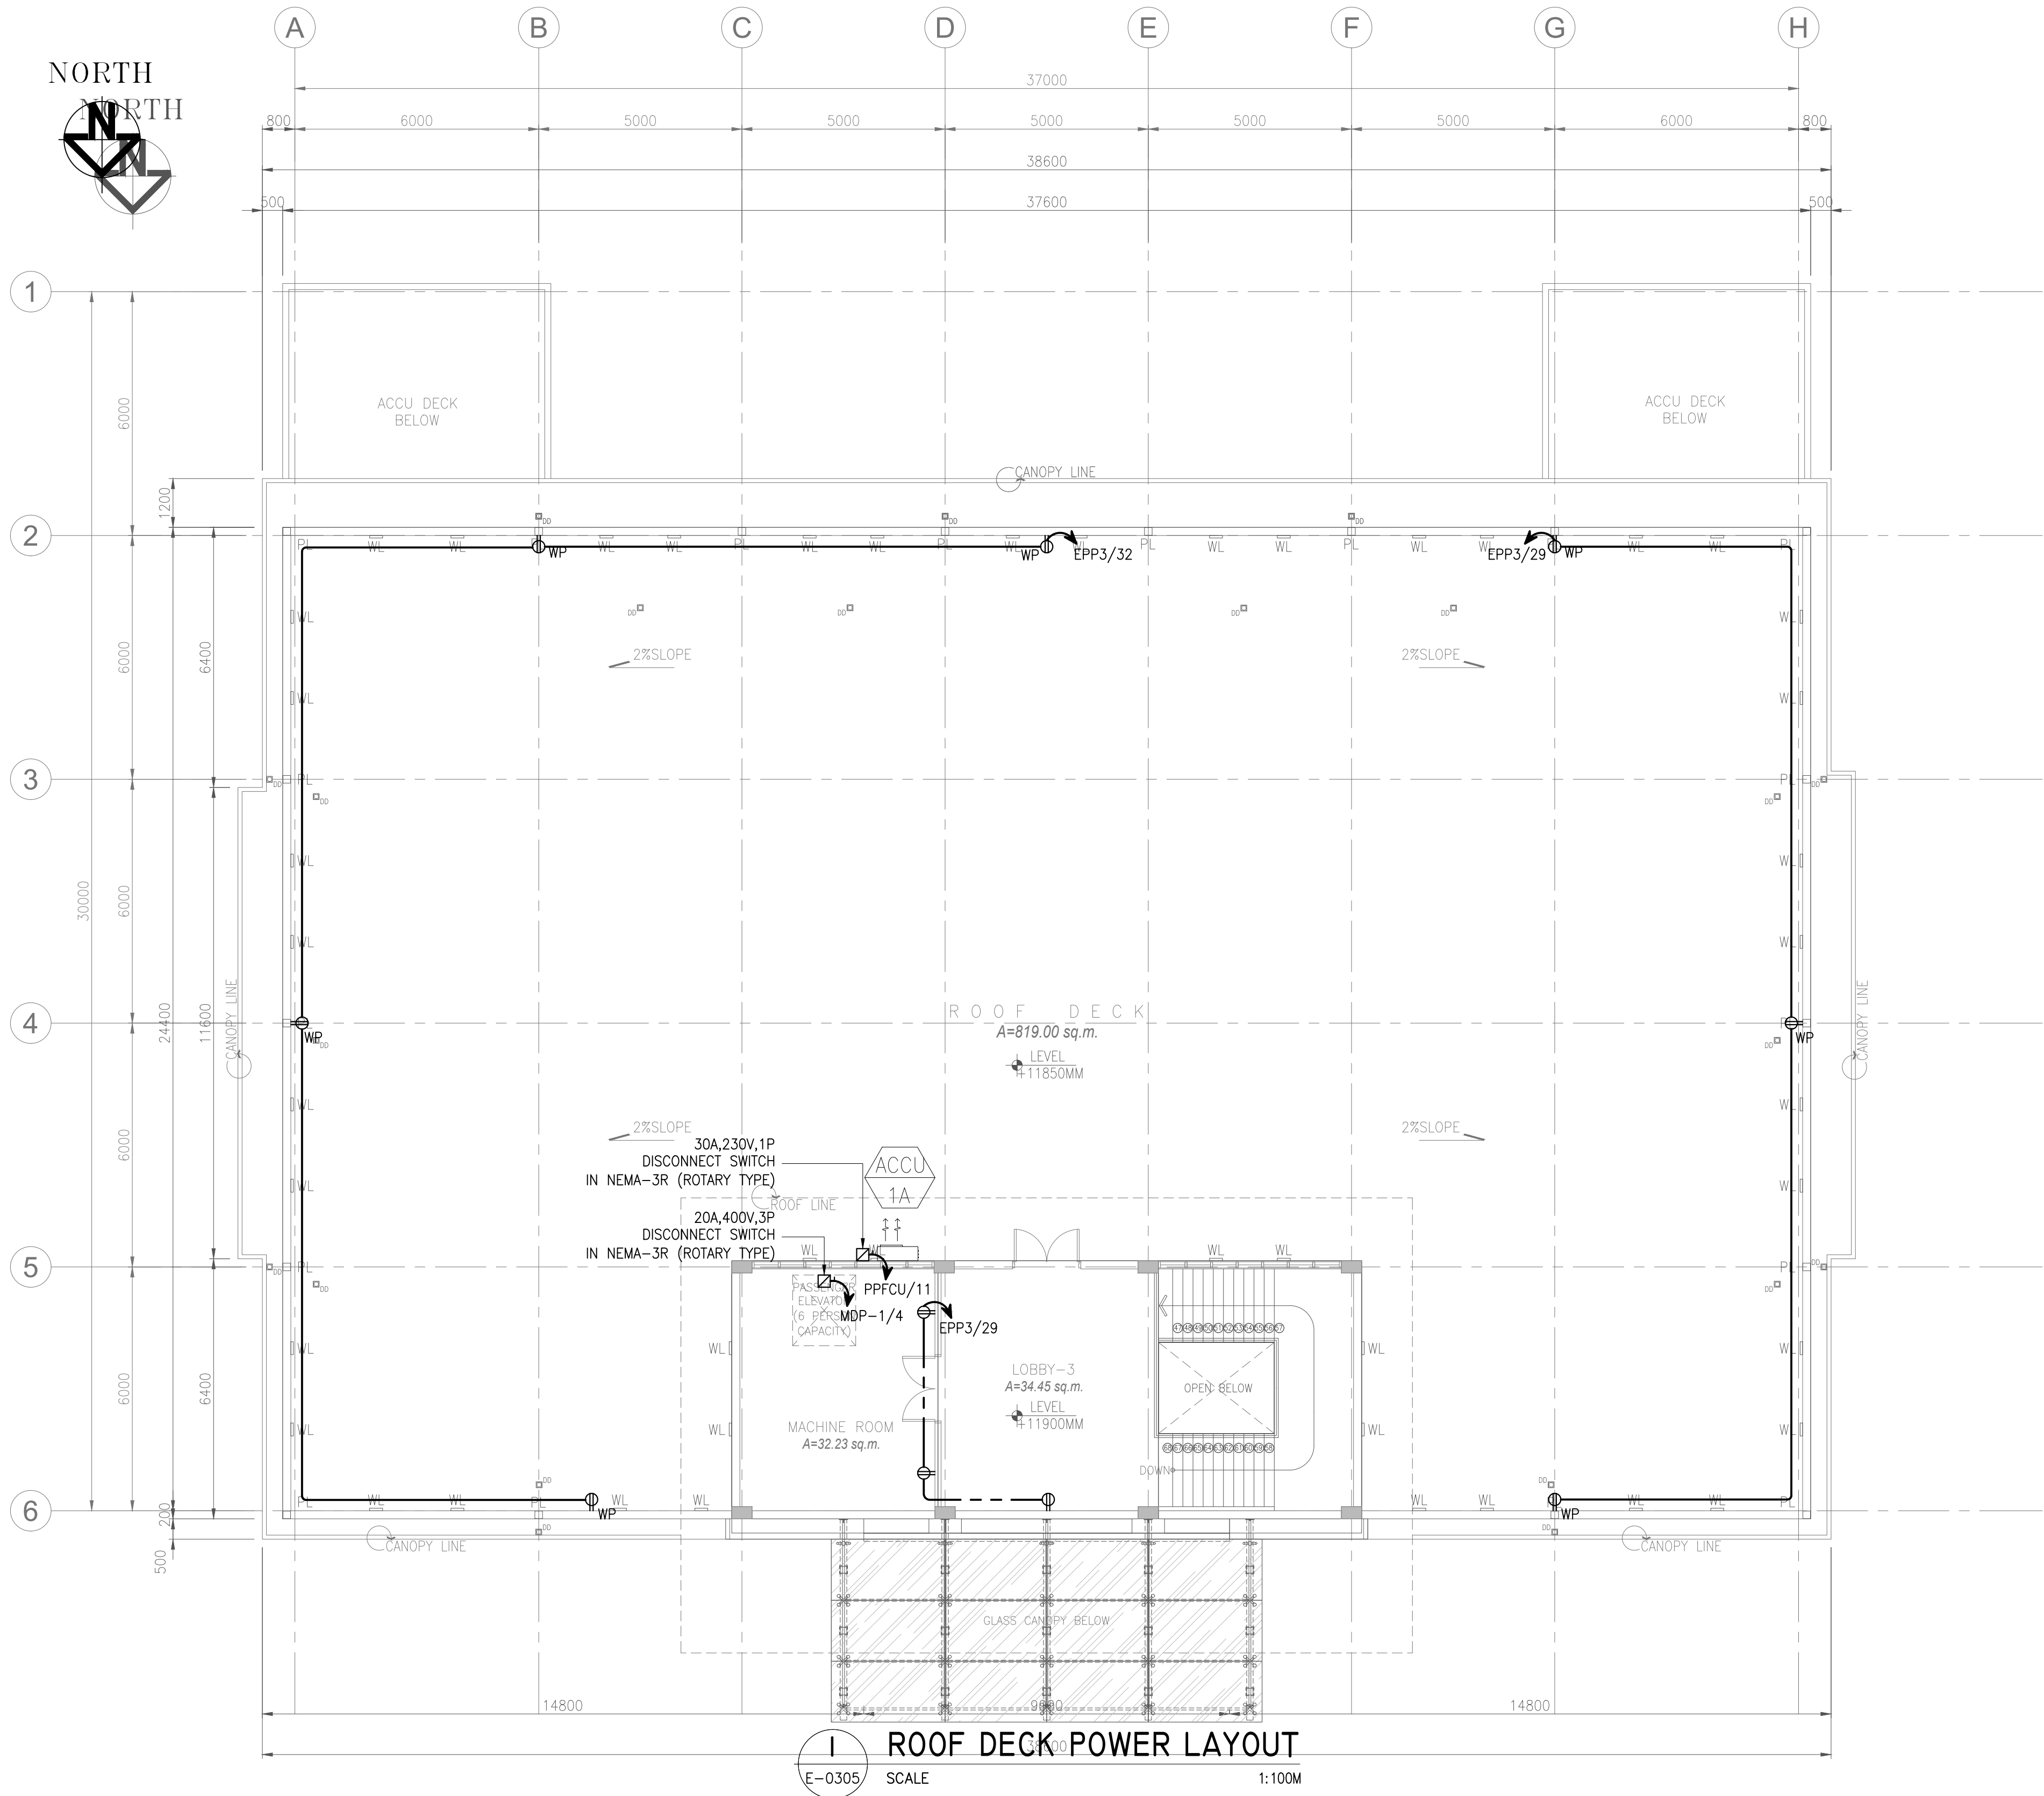


1 ROOF DECK POWER LAYOUT
E-0305 SCALE 1:100M

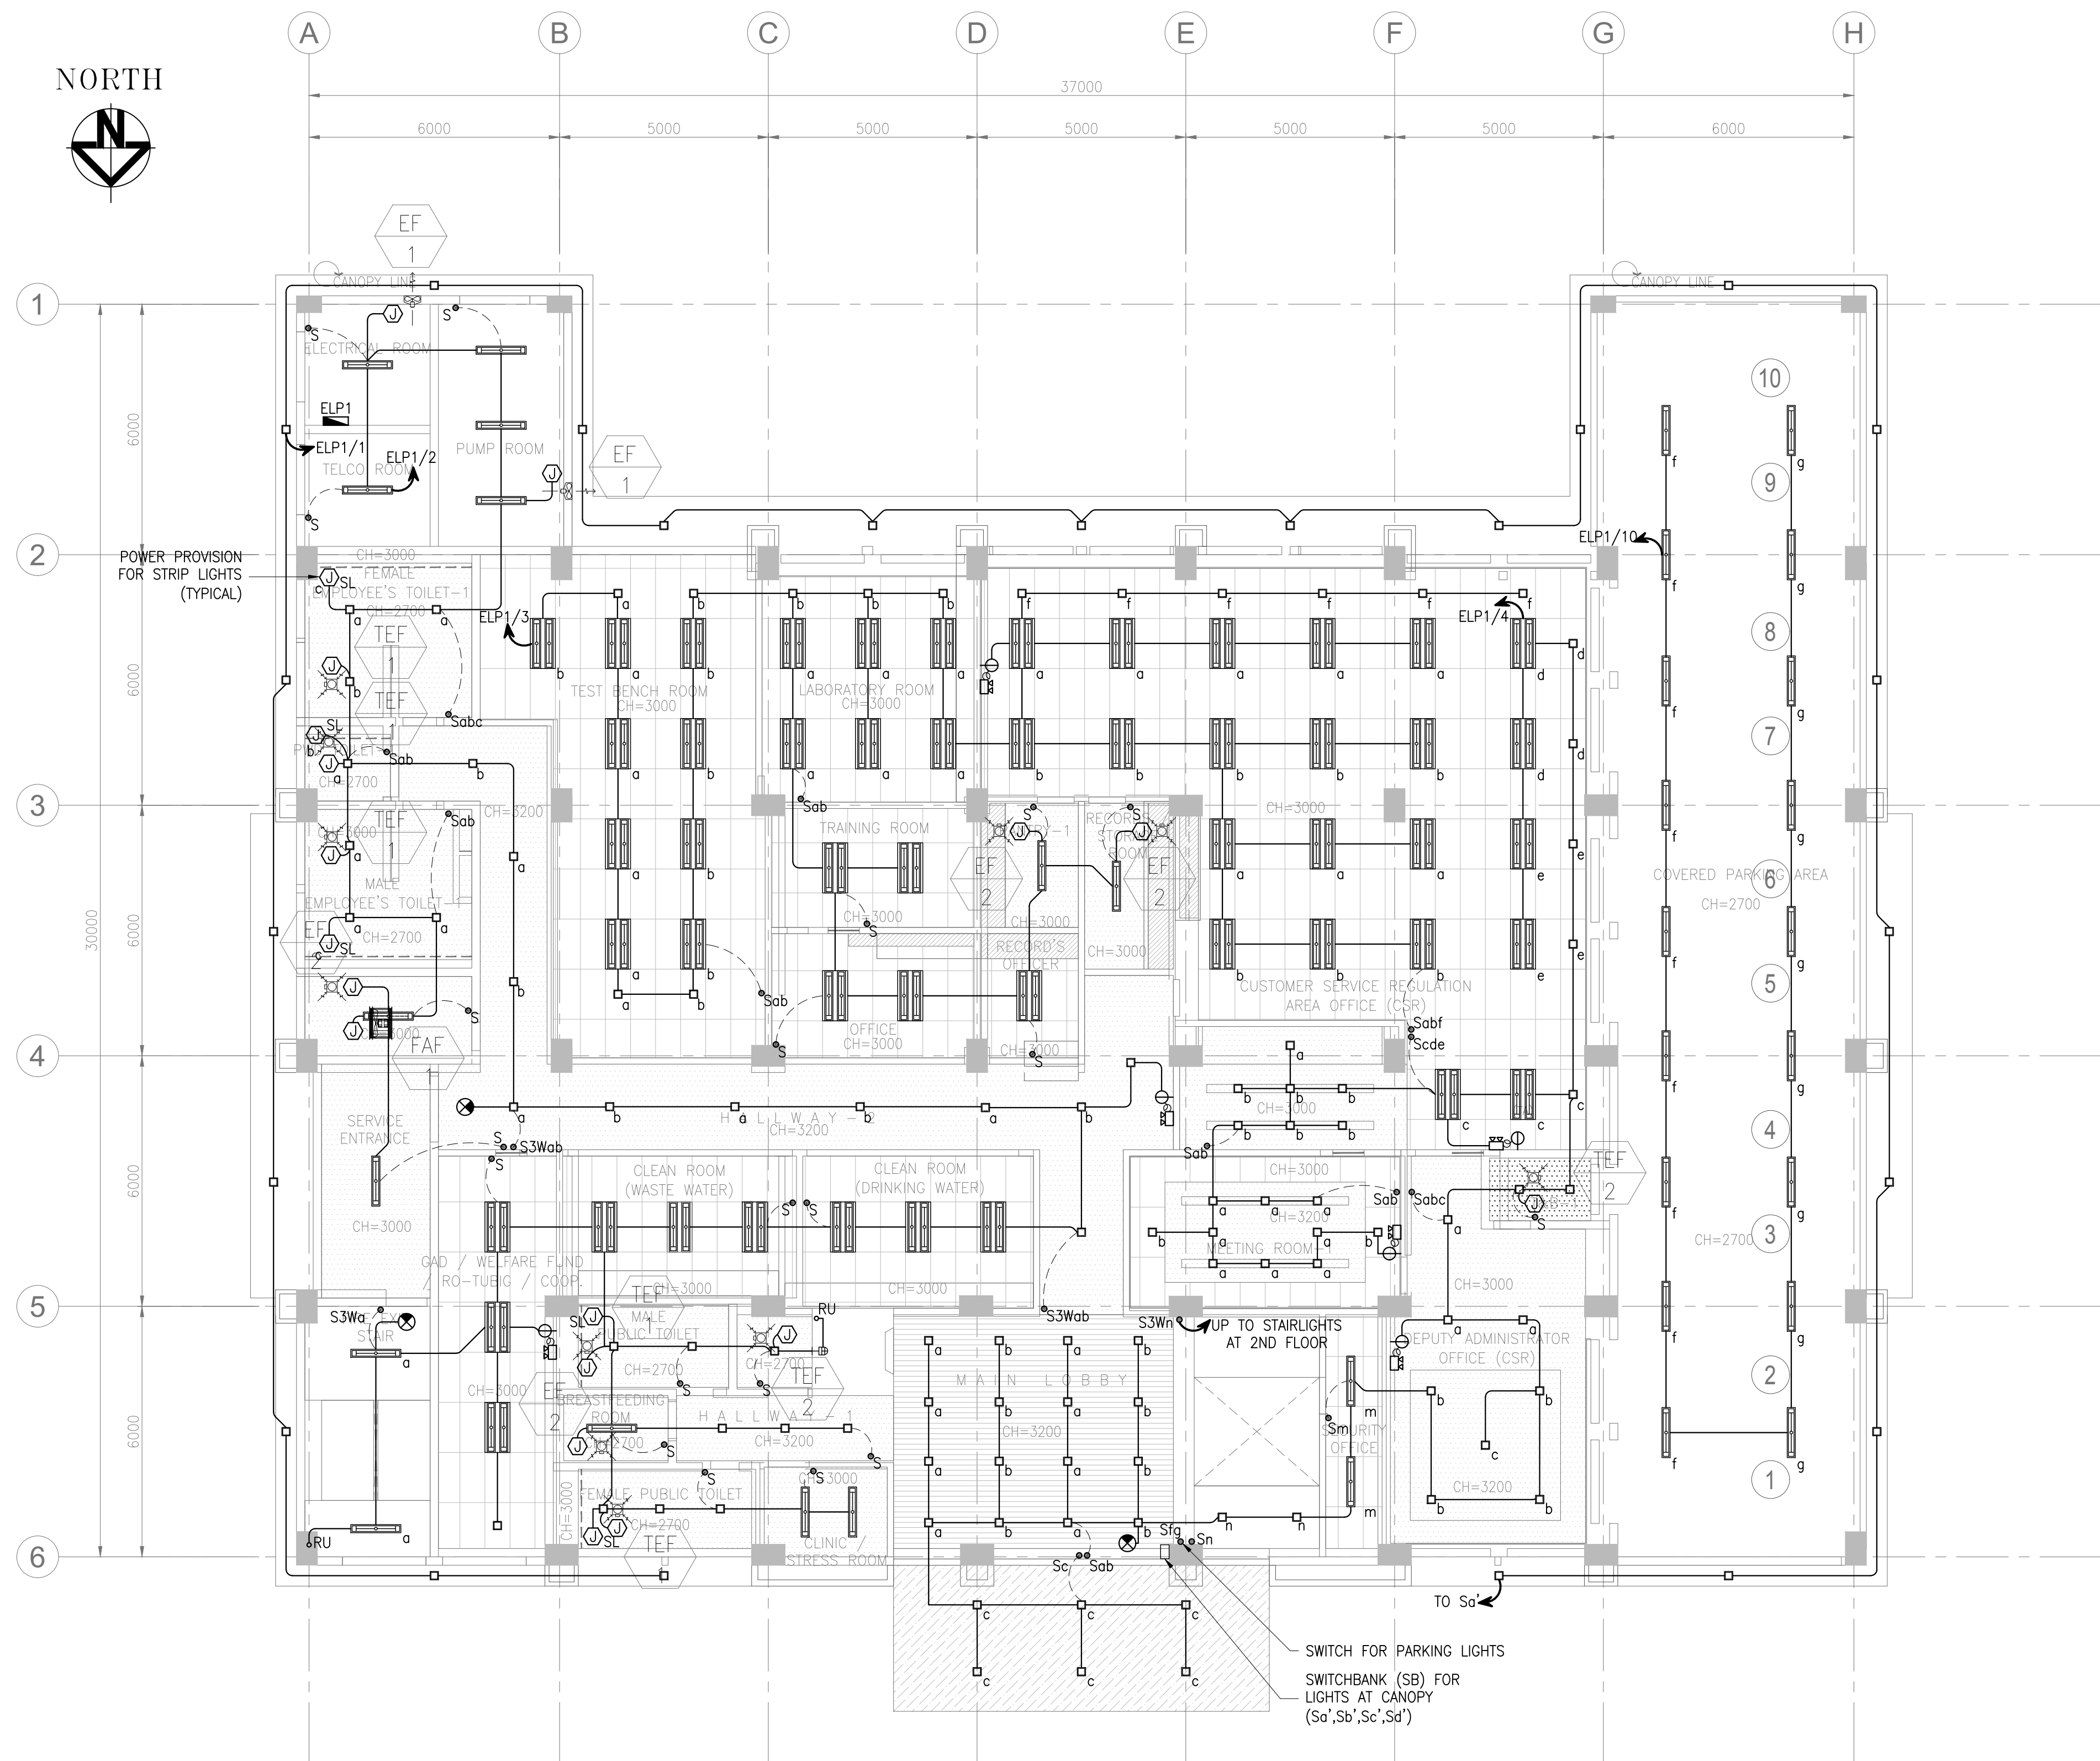

I GROUND FLOOR LIGHTING LAYOUT
E-0401 SCALE 1:100M

CERTIFIED BY		OWNER	PROJECT TITLE/LOCATION	CLIENT	SHEET CONTENTS	R.A. 9266 SEC. 33 DRAWINGS AND SPECIFICATIONS AND CONTRACT DOCUMENTS DULY SIGNED, STAMPED OR SEALED AS INSTRUMENTS FOR SERVICE ARE THE INTELLECTUAL PROPERTY AND DOCUMENTS OF ARCHITECT, WHETHER THE OBJECT FOR WHICH THEY ARE MADE IS EXECUTED OR NOT. IT SHALL BE UNLAWFUL FOR ANY PERSON TO DUPLICATE OR TO MAKE COPIES OF SAID DOCUMENTS FOR USE IN THE REPETITION OF AND FOR OTHER PROJECTS OR BUILDINGS, WHETHER EXECUTED PARTLY OR IN WHOLE, WITHOUT THE WRITTEN CONSENT OF THE ARCHITECT OR AUTHOR OF SAID DOCUMENTS.	CADD	DATE	NO.	REVISIONS	CHK	DATE	PAPER SIZE	SHEET NO.
RODEL JOSELITO B. MANABAT		METROPOLITAN WATERWORKS AND SEWERAGE SYSTEM REGULATORY OFFICE	3-STOREY OFFICE BUILDING WITH ROOF DECK	PROJECT PROPONENT	GROUND FLOOR LIGHTING LAYOUT		AVL	JUL 2018					20X30	E-0401
PROFESSIONAL ELECTRICAL ENGINEER				APPROVED BY:			DESIGNED	DATE					SCALE	PROJECT NO.
REG. NO.: 3402 TIN NO.: 158-336-047 PTR NO.: 2733331				MELCHOR S. CORDOVA ALTERNATE END-USER FOR RO BUILDING	PATRICK LESTER N. TY CHIEF REGULATOR, MWSS RO		RRVP	JUL 2018					AS SHOWN	SO-G-17-036
DATE : JANUARY 23, 2018 PLACE : MANDALUYONG CITY		MWSS COMPOUND, KATIPUNAN AVENUE, MATANGANG BALARA, QUEZON CITY	MWSS COMPOUND, KATIPUNAN AVENUE, MATANGANG BALARA, QUEZON CITY				APPROVED	DATE						


NORTH

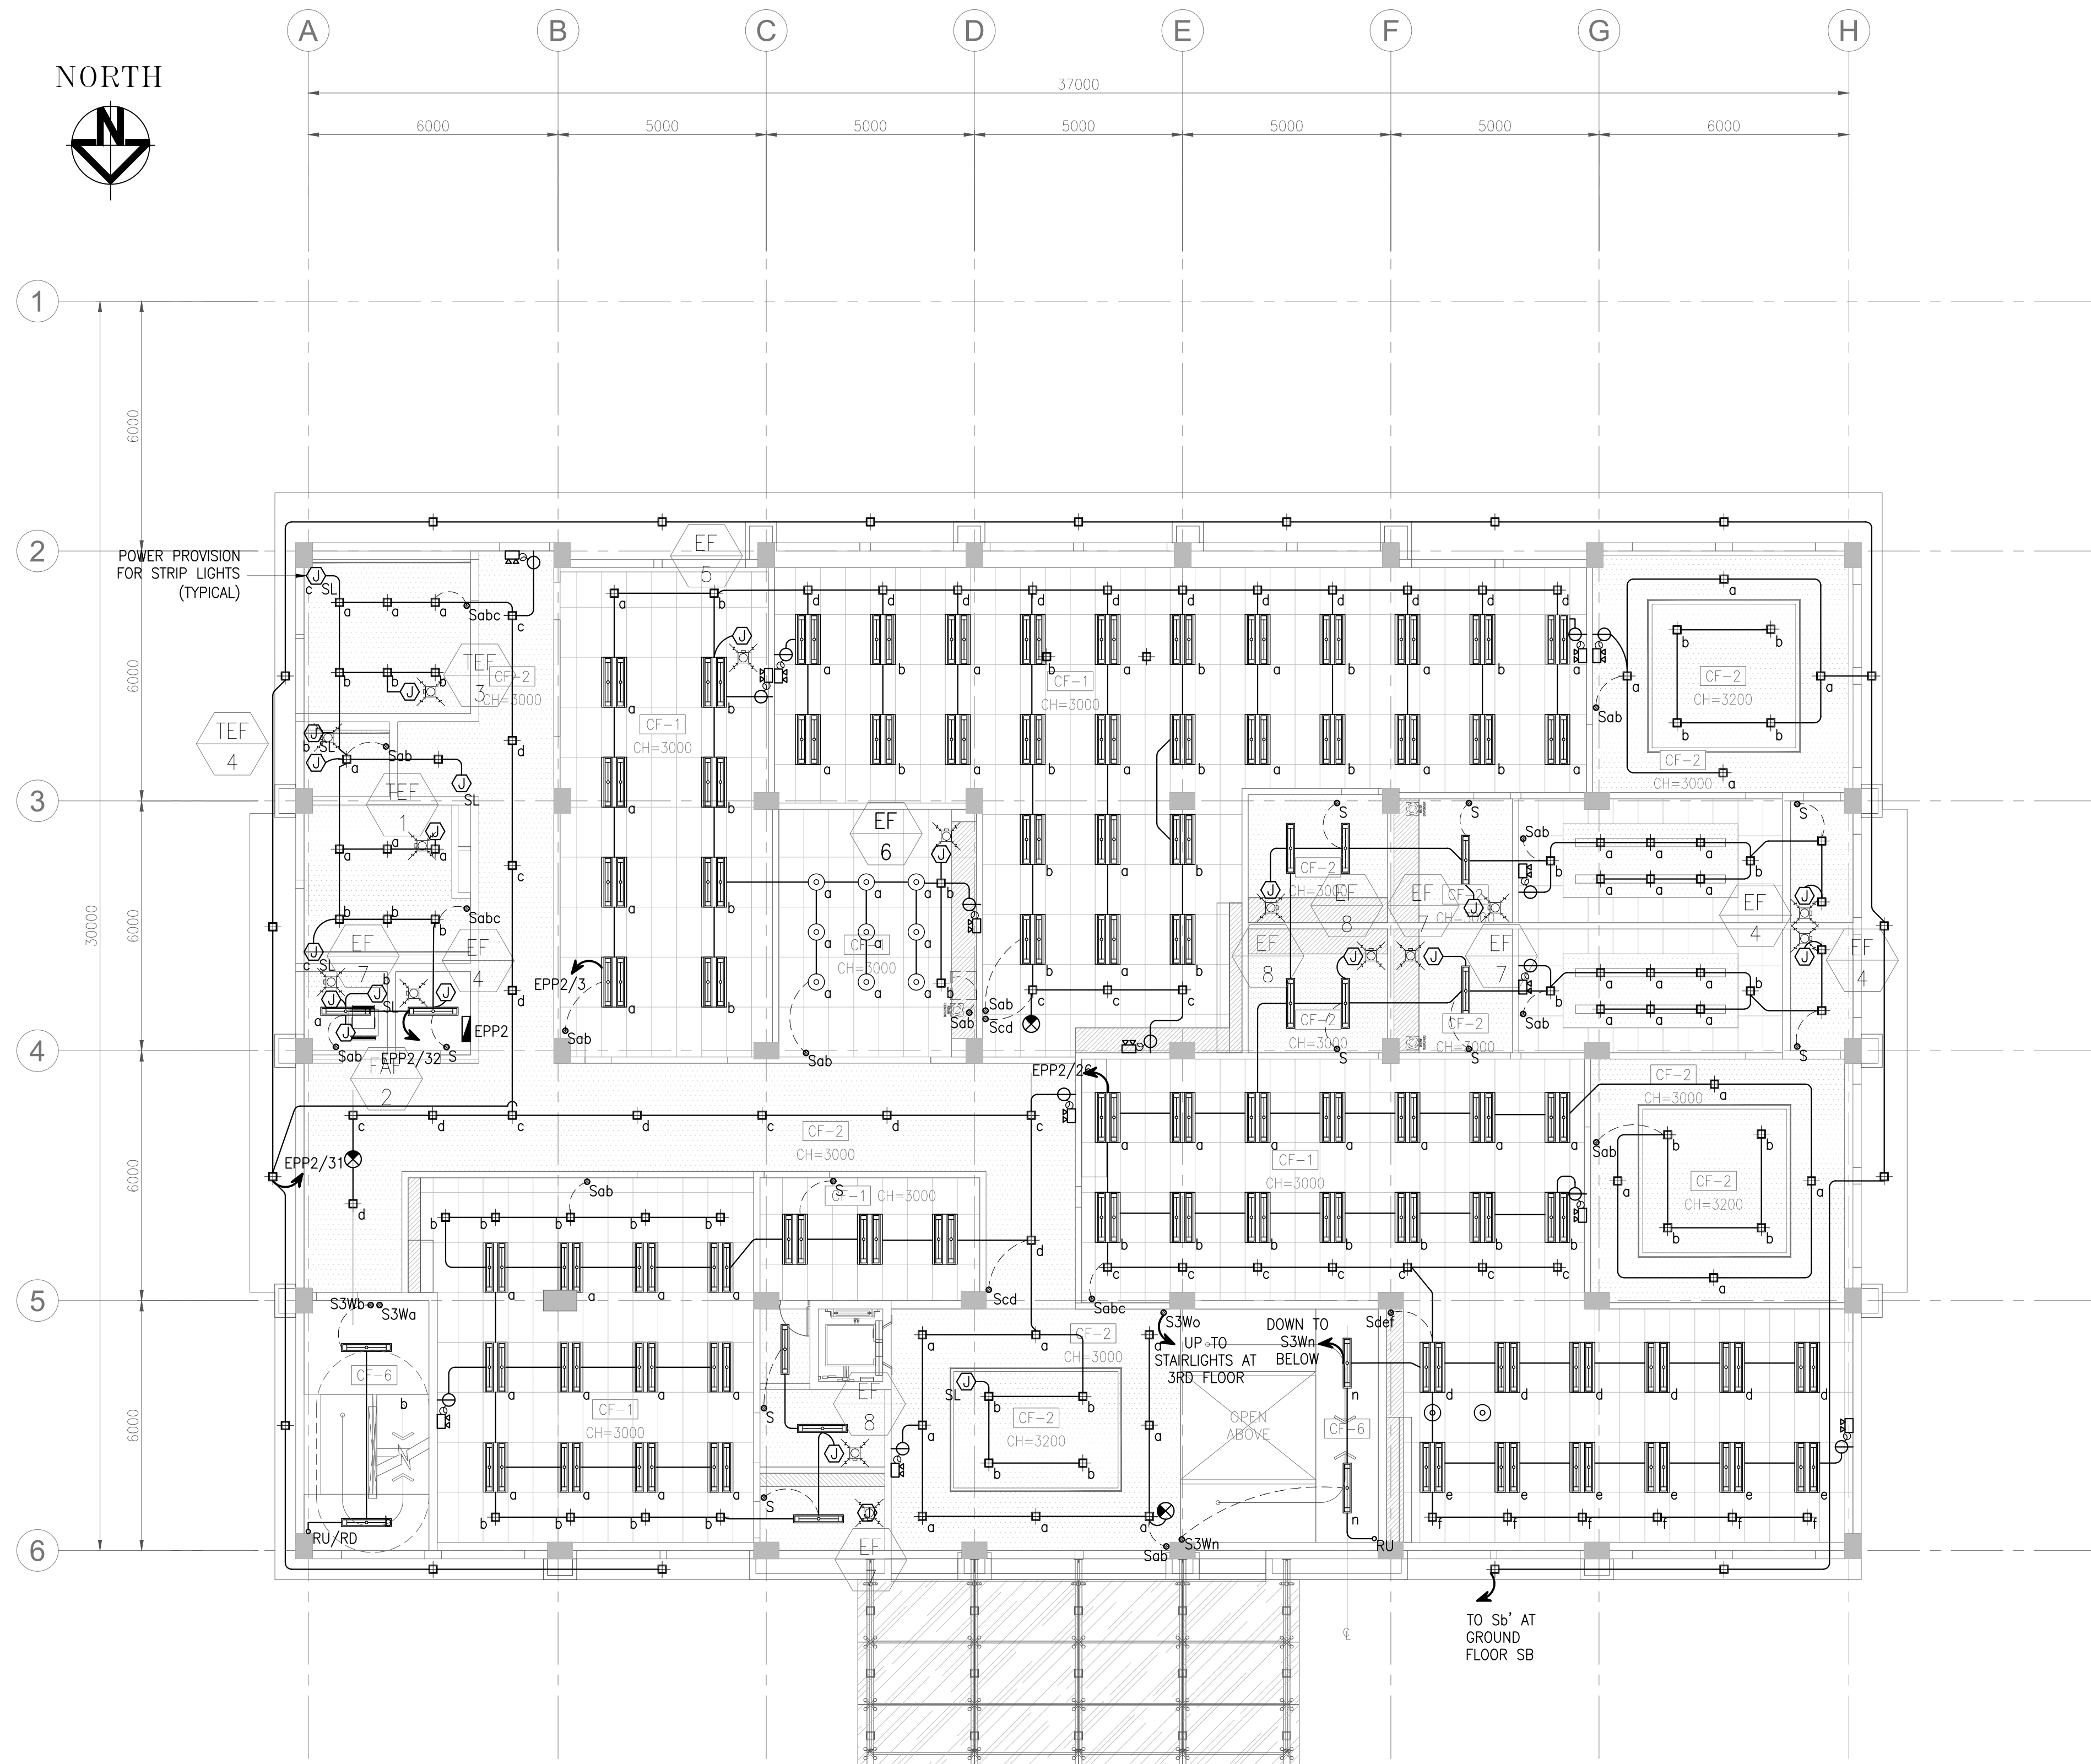

I SECOND FLOOR LIGHTING LAYOUT
E-0402 SCALE 1:100M


CERTIFIED BY		OWNER	PROJECT TITLE/LOCATION	CLIENT		SHEET CONTENTS	R.A. 9266 SEC. 33		CADD	DATE	NO.	REVISIONS		CHK	DATE	PAPER SIZE	SHEET NO.		
RODEL JOSELITO B. MANABAT PROFESSIONAL ELECTRICAL ENGINEER	REG. NO.: 3402	METROPOLITAN WATERWORKS AND SEWERAGE SYSTEM REGULATORY OFFICE	3-STOREY OFFICE BUILDING WITH ROOF DECK	PROJECT PROPONENT	APPROVED BY:	SECOND FLOOR LIGHTING LAYOUT	DRAWINGS AND SPECIFICATIONS AND CONTRACT DOCUMENTS DULY SIGNED, STAMPED OR SEALED AS INSTRUMENTS FOR SERVICE ARE THE INTELLECTUAL PROPERTY AND DOCUMENTS OF ARCHITECT, WHETHER THE OBJECT FOR WHICH THEY ARE MADE IS EXECUTED OR NOT. IT SHALL BE UNLAWFUL, FOR ANY PERSON TO DUPLICATE OR TO MAKE COPIES OF SAID DOCUMENTS FOR USE IN THE REPETITION OF AND FOR OTHER PROJECTS OR BUILDINGS, WHETHER EXECUTED PARTLY OR IN WHOLE, WITHOUT THE WRITTEN CONSENT OF THE ARCHITECT OR AUTHOR OF SAID DOCUMENTS.		AVL	JUL 2018						20X30	E-0402		
	TIN NO. : 158-336-047				DESIGNED		DATE												
	PTR NO. : 2733331				RRVP		JUL 2018												
	DATE : JANUARY 23, 2018			APPROVED	DATE													SCALE	PROJECT NO.
	PLACE : MANDALUYONG CITY	MWSS COMPOUND, KATIPUNAN AVENUE, MATANGANG BALARA, QUEZON CITY		MWSS COMPOUND, KATIPUNAN AVENUE, MATANGANG BALARA, QUEZON CITY	MELCHOR S. CORDOVA ALTERNATE END-USER FOR RO BUILDING		PATRICK LESTER N. TY CHIEF REGULATOR, MWSS RO					RJBM	JUL 2018					AS SHOWN	SO-G-17-036

NORTH

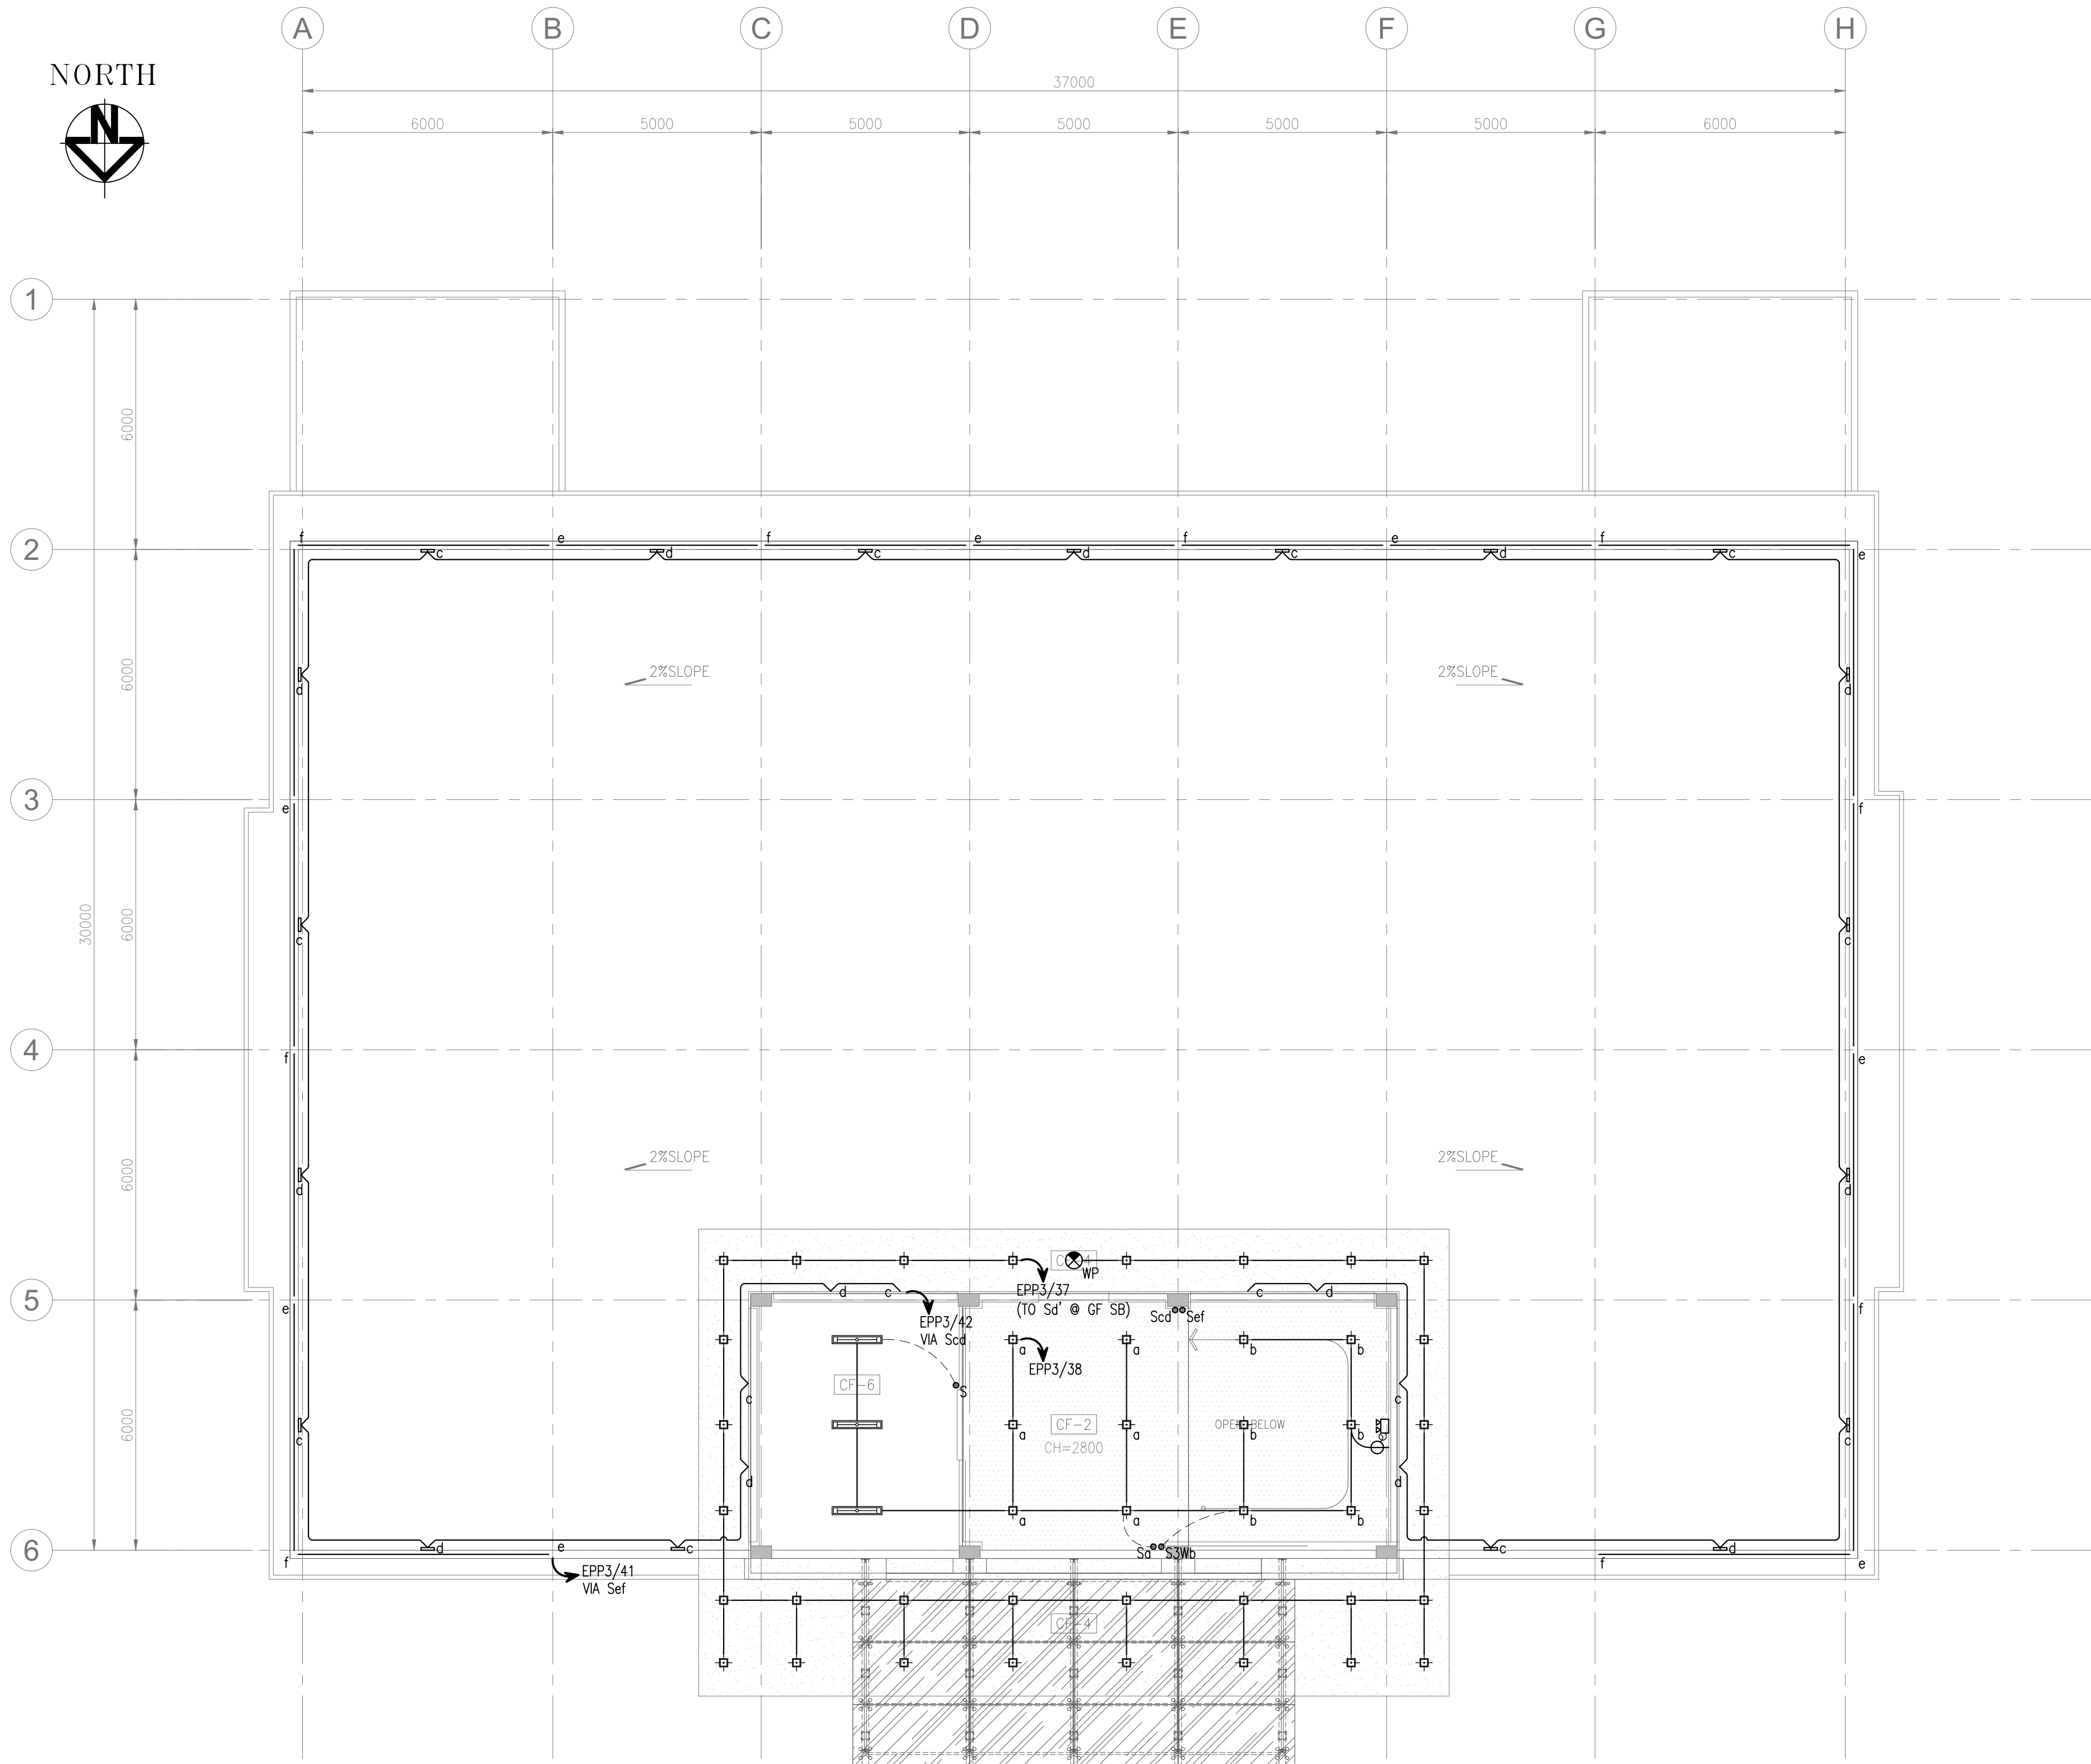


I ROOF DECK LIGHTING LAYOUT
E-0404 SCALE 1:100M


CERTIFIED BY		OWNER	PROJECT TITLE/LOCATION	CLIENT		SHEET CONTENTS	R.A. 9266 SEC. 33	CADD	DATE	NO.	REVISIONS	CHK	DATE	PAPER SIZE	SHEET NO.		
RODEL JOSELITO B. MANABAT PROFESSIONAL ELECTRICAL ENGINEER	REG. NO.: 3402	METROPOLITAN WATERWORKS AND SEWERAGE SYSTEM REGULATORY OFFICE	3-STOREY OFFICE BUILDING WITH ROOF DECK	PROJECT PROPONENT	APPROVED BY:	ROOF DECK LIGHTING LAYOUT	DRAWINGS AND SPECIFICATIONS AND CONTRACT DOCUMENTS DULY SIGNED, STAMPED OR SEALED AS INSTRUMENTS FOR SERVICE ARE THE INTELLECTUAL PROPERTY AND DOCUMENTS OF ARCHITECT, WHETHER THE OBJECT FOR WHICH THEY ARE MADE IS EXECUTED OR NOT. IT SHALL BE UNLAWFUL FOR ANY PERSON TO DUPLICATE OR TO MAKE COPIES OF SAID DOCUMENTS FOR USE IN THE REPETITION OF AND FOR OTHER PROJECTS OR BUILDINGS, WHETHER EXECUTED PARTLY OR IN WHOLE, WITHOUT THE WRITTEN CONSENT OF THE ARCHITECT OR AUTHOR OF SAID DOCUMENTS.	AVL	JUL 2018					20X30	E-0404		
	TIN NO. : 158-336-047																
	PTR NO. : 2733331																SCALE
	DATE : JANUARY 23, 2018															AS SHOWN	SO-G-17-036
	PLACE : MANDALUYONG CITY	MWSS COMPOUND, KATIPUNAN AVENUE, MATANDANG BALARA, QUEZON CITY	MWSS COMPOUND, KATIPUNAN AVENUE, MATANDANG BALARA, QUEZON CITY	MELCHOR S. CORDOVA ALTERNATE END-USER FOR RO BUILDING	PATRICK LESTER N. TY CHIEF REGULATOR, MWSS RO												

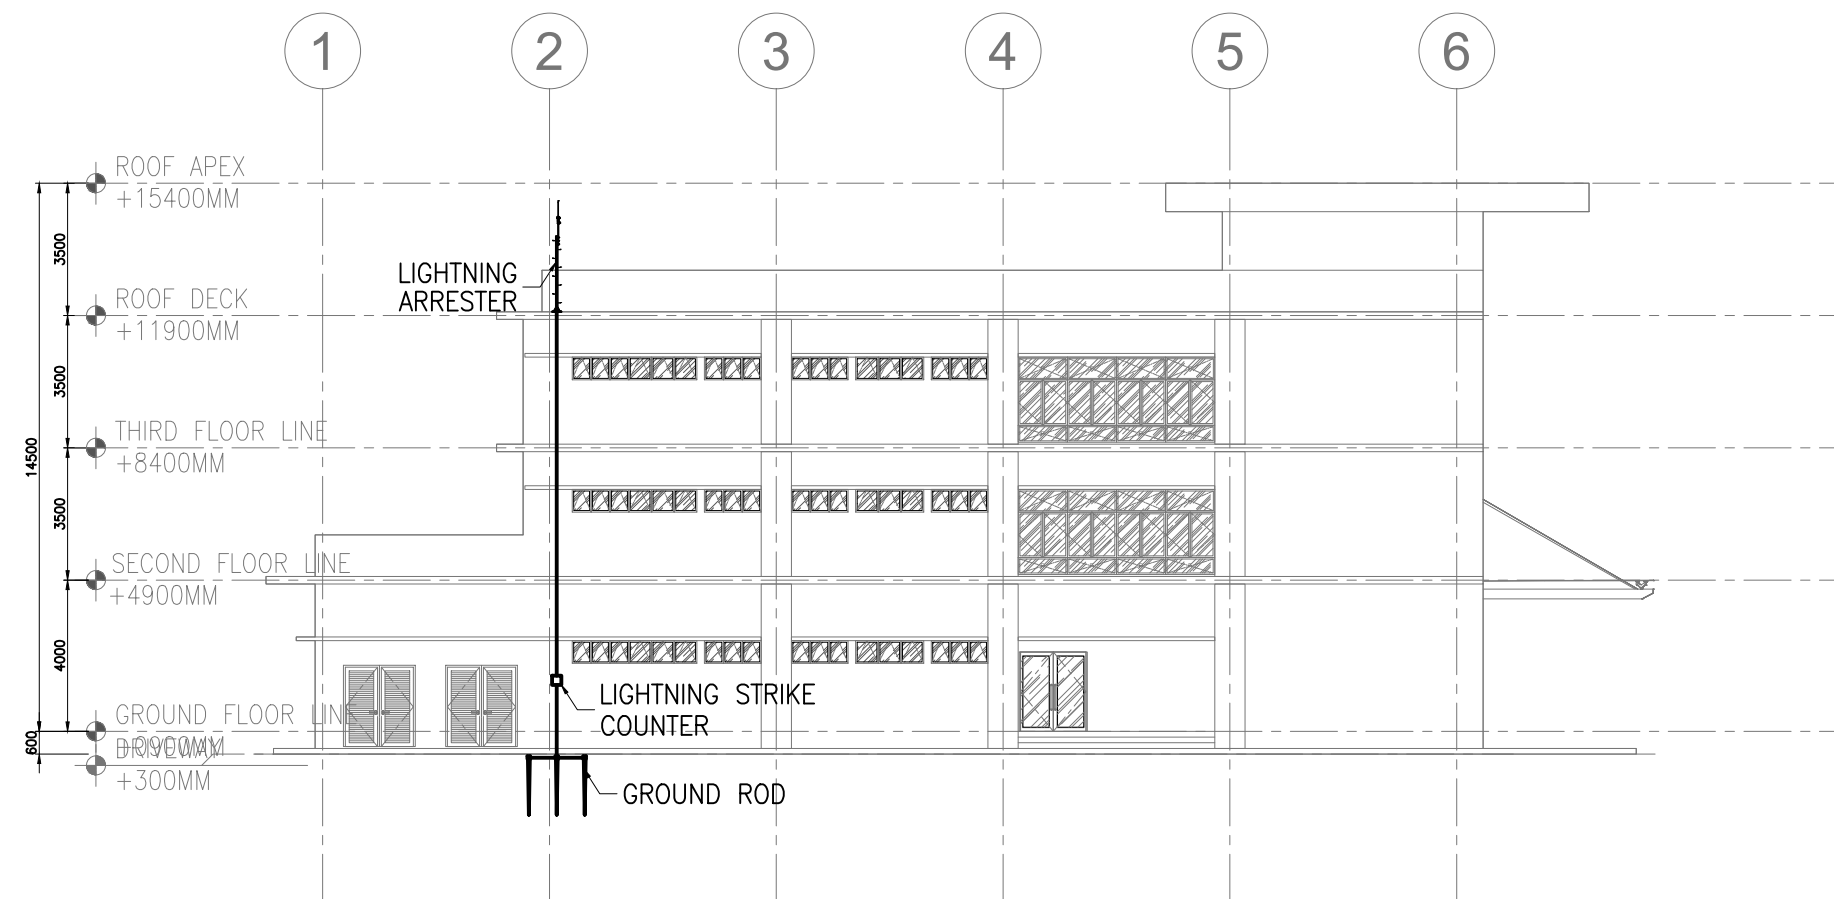

1 LIGHTNING PROTECTION SYSTEM RISER DIAGRAM
E-0501 SCALE 1:200M

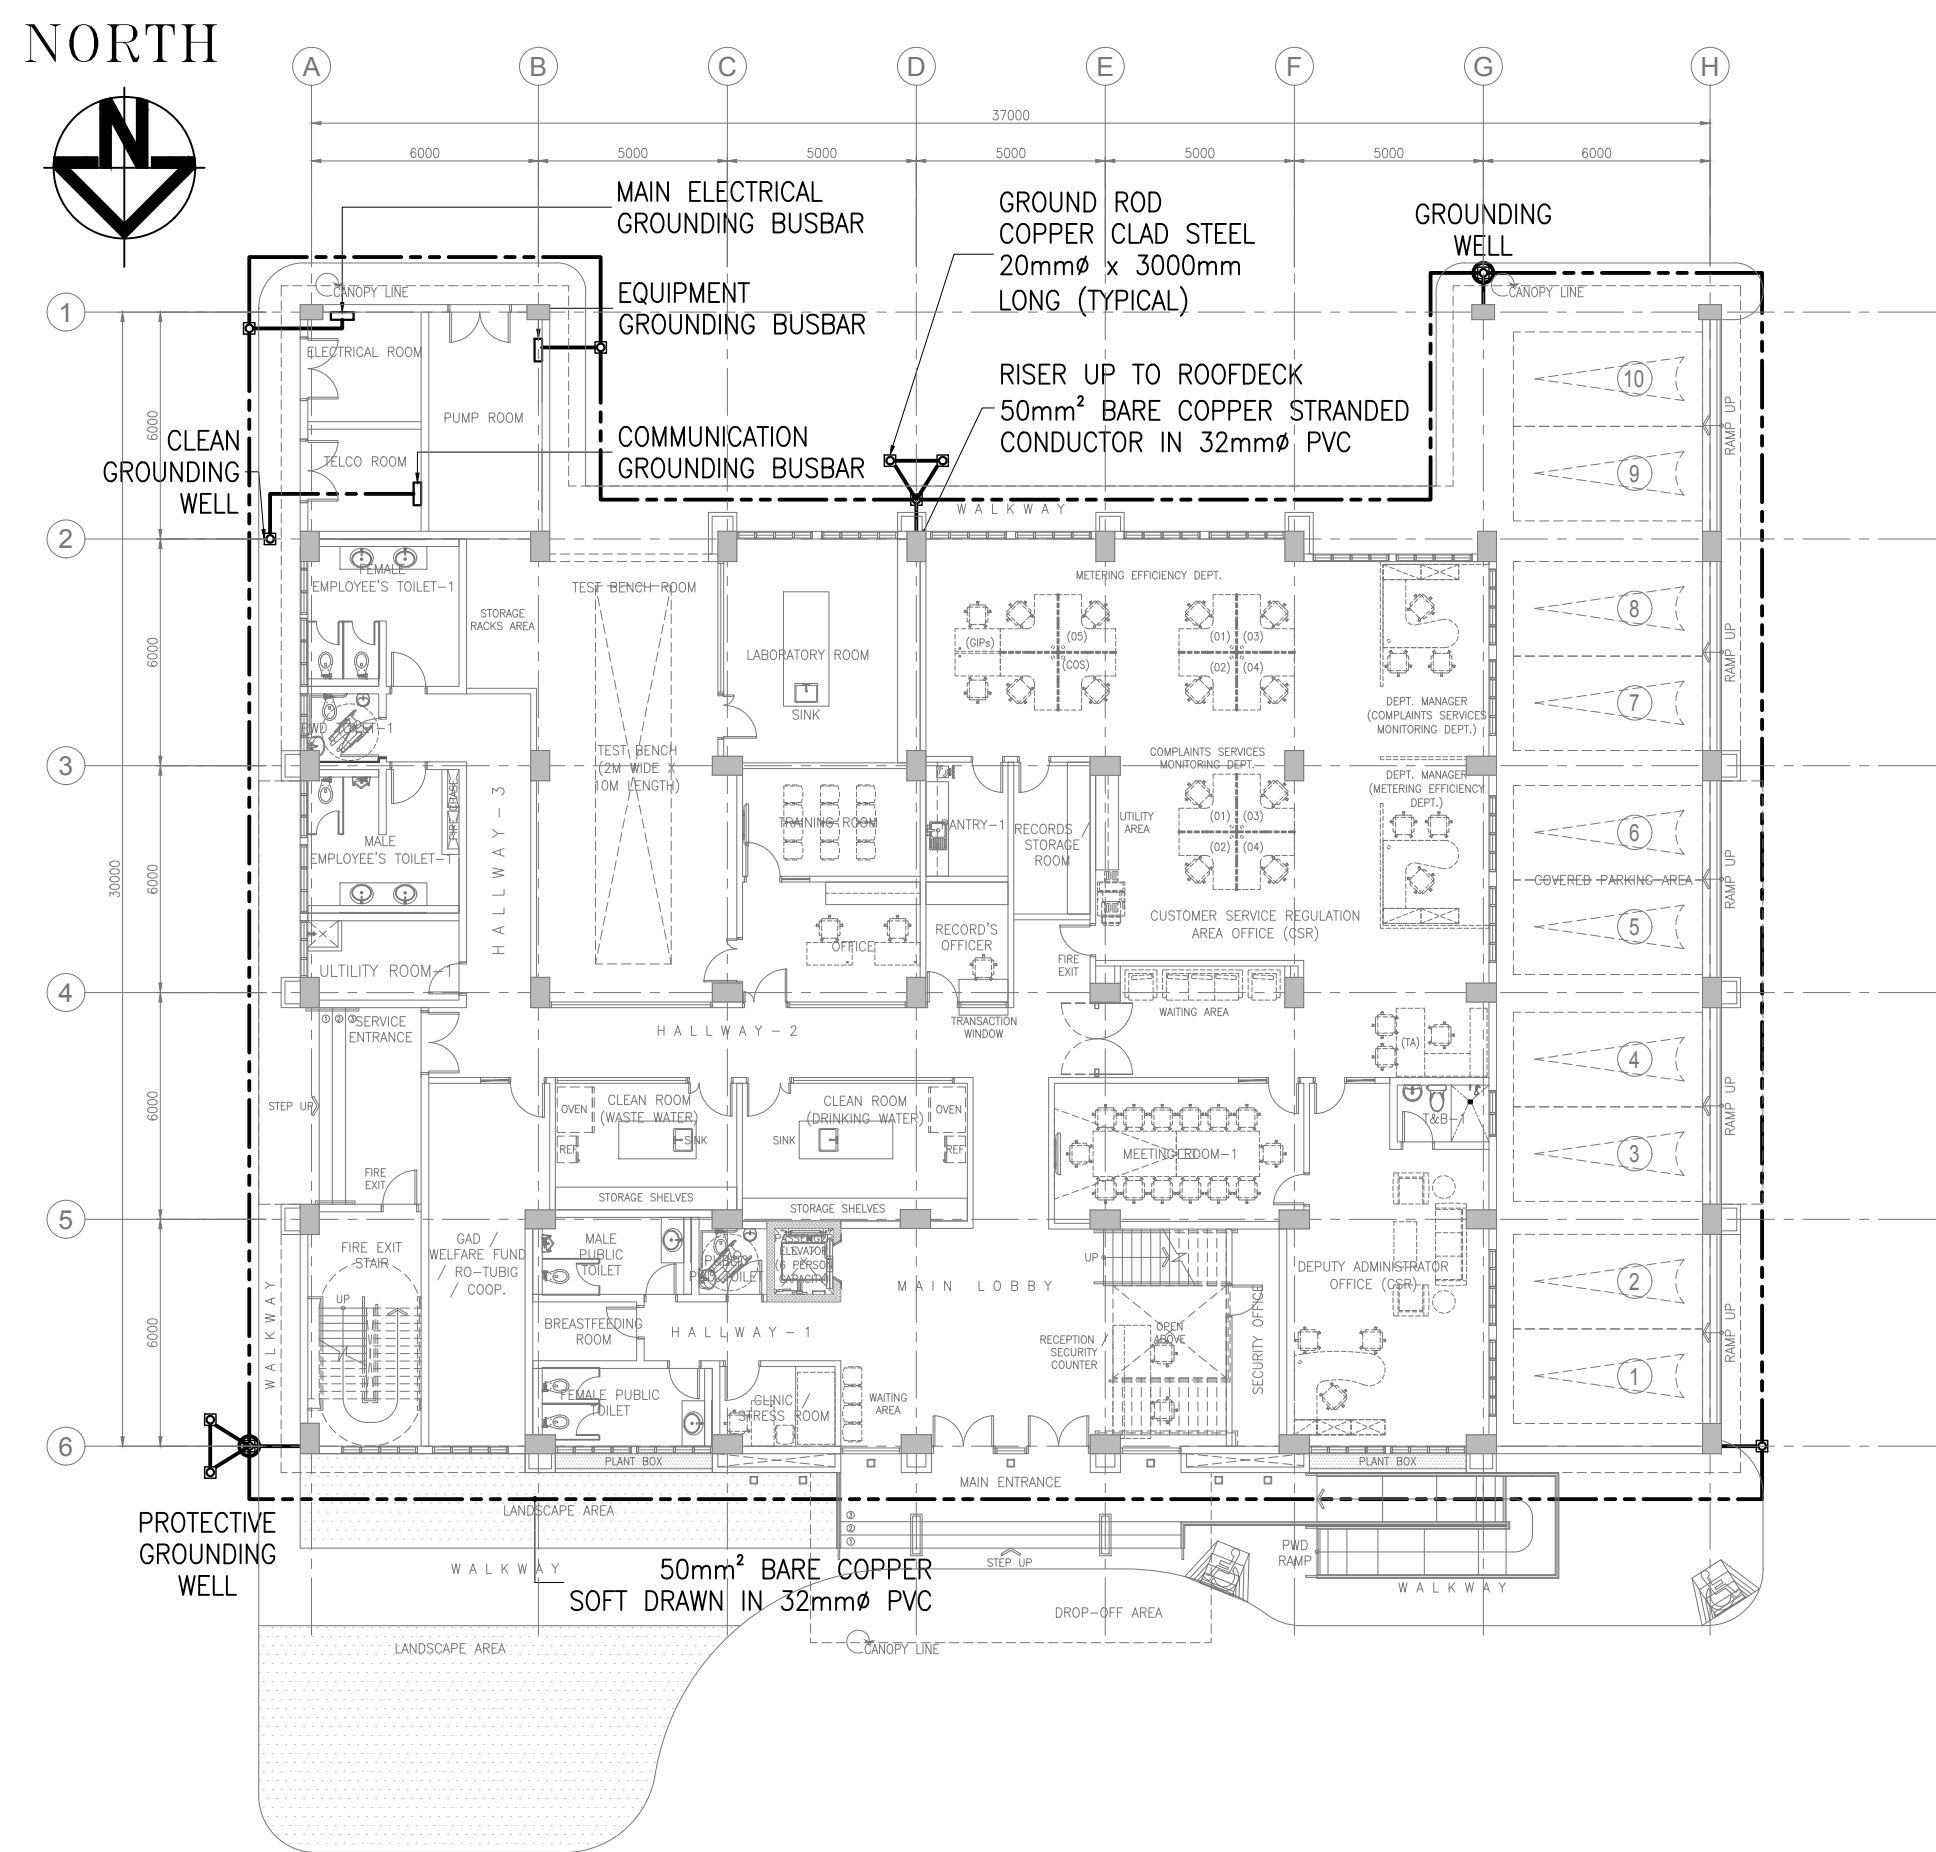

2 GROUND FLOOR LIGHTNING PROTECTION SYSTEM LAYOUT
E-0501 SCALE 1:200M

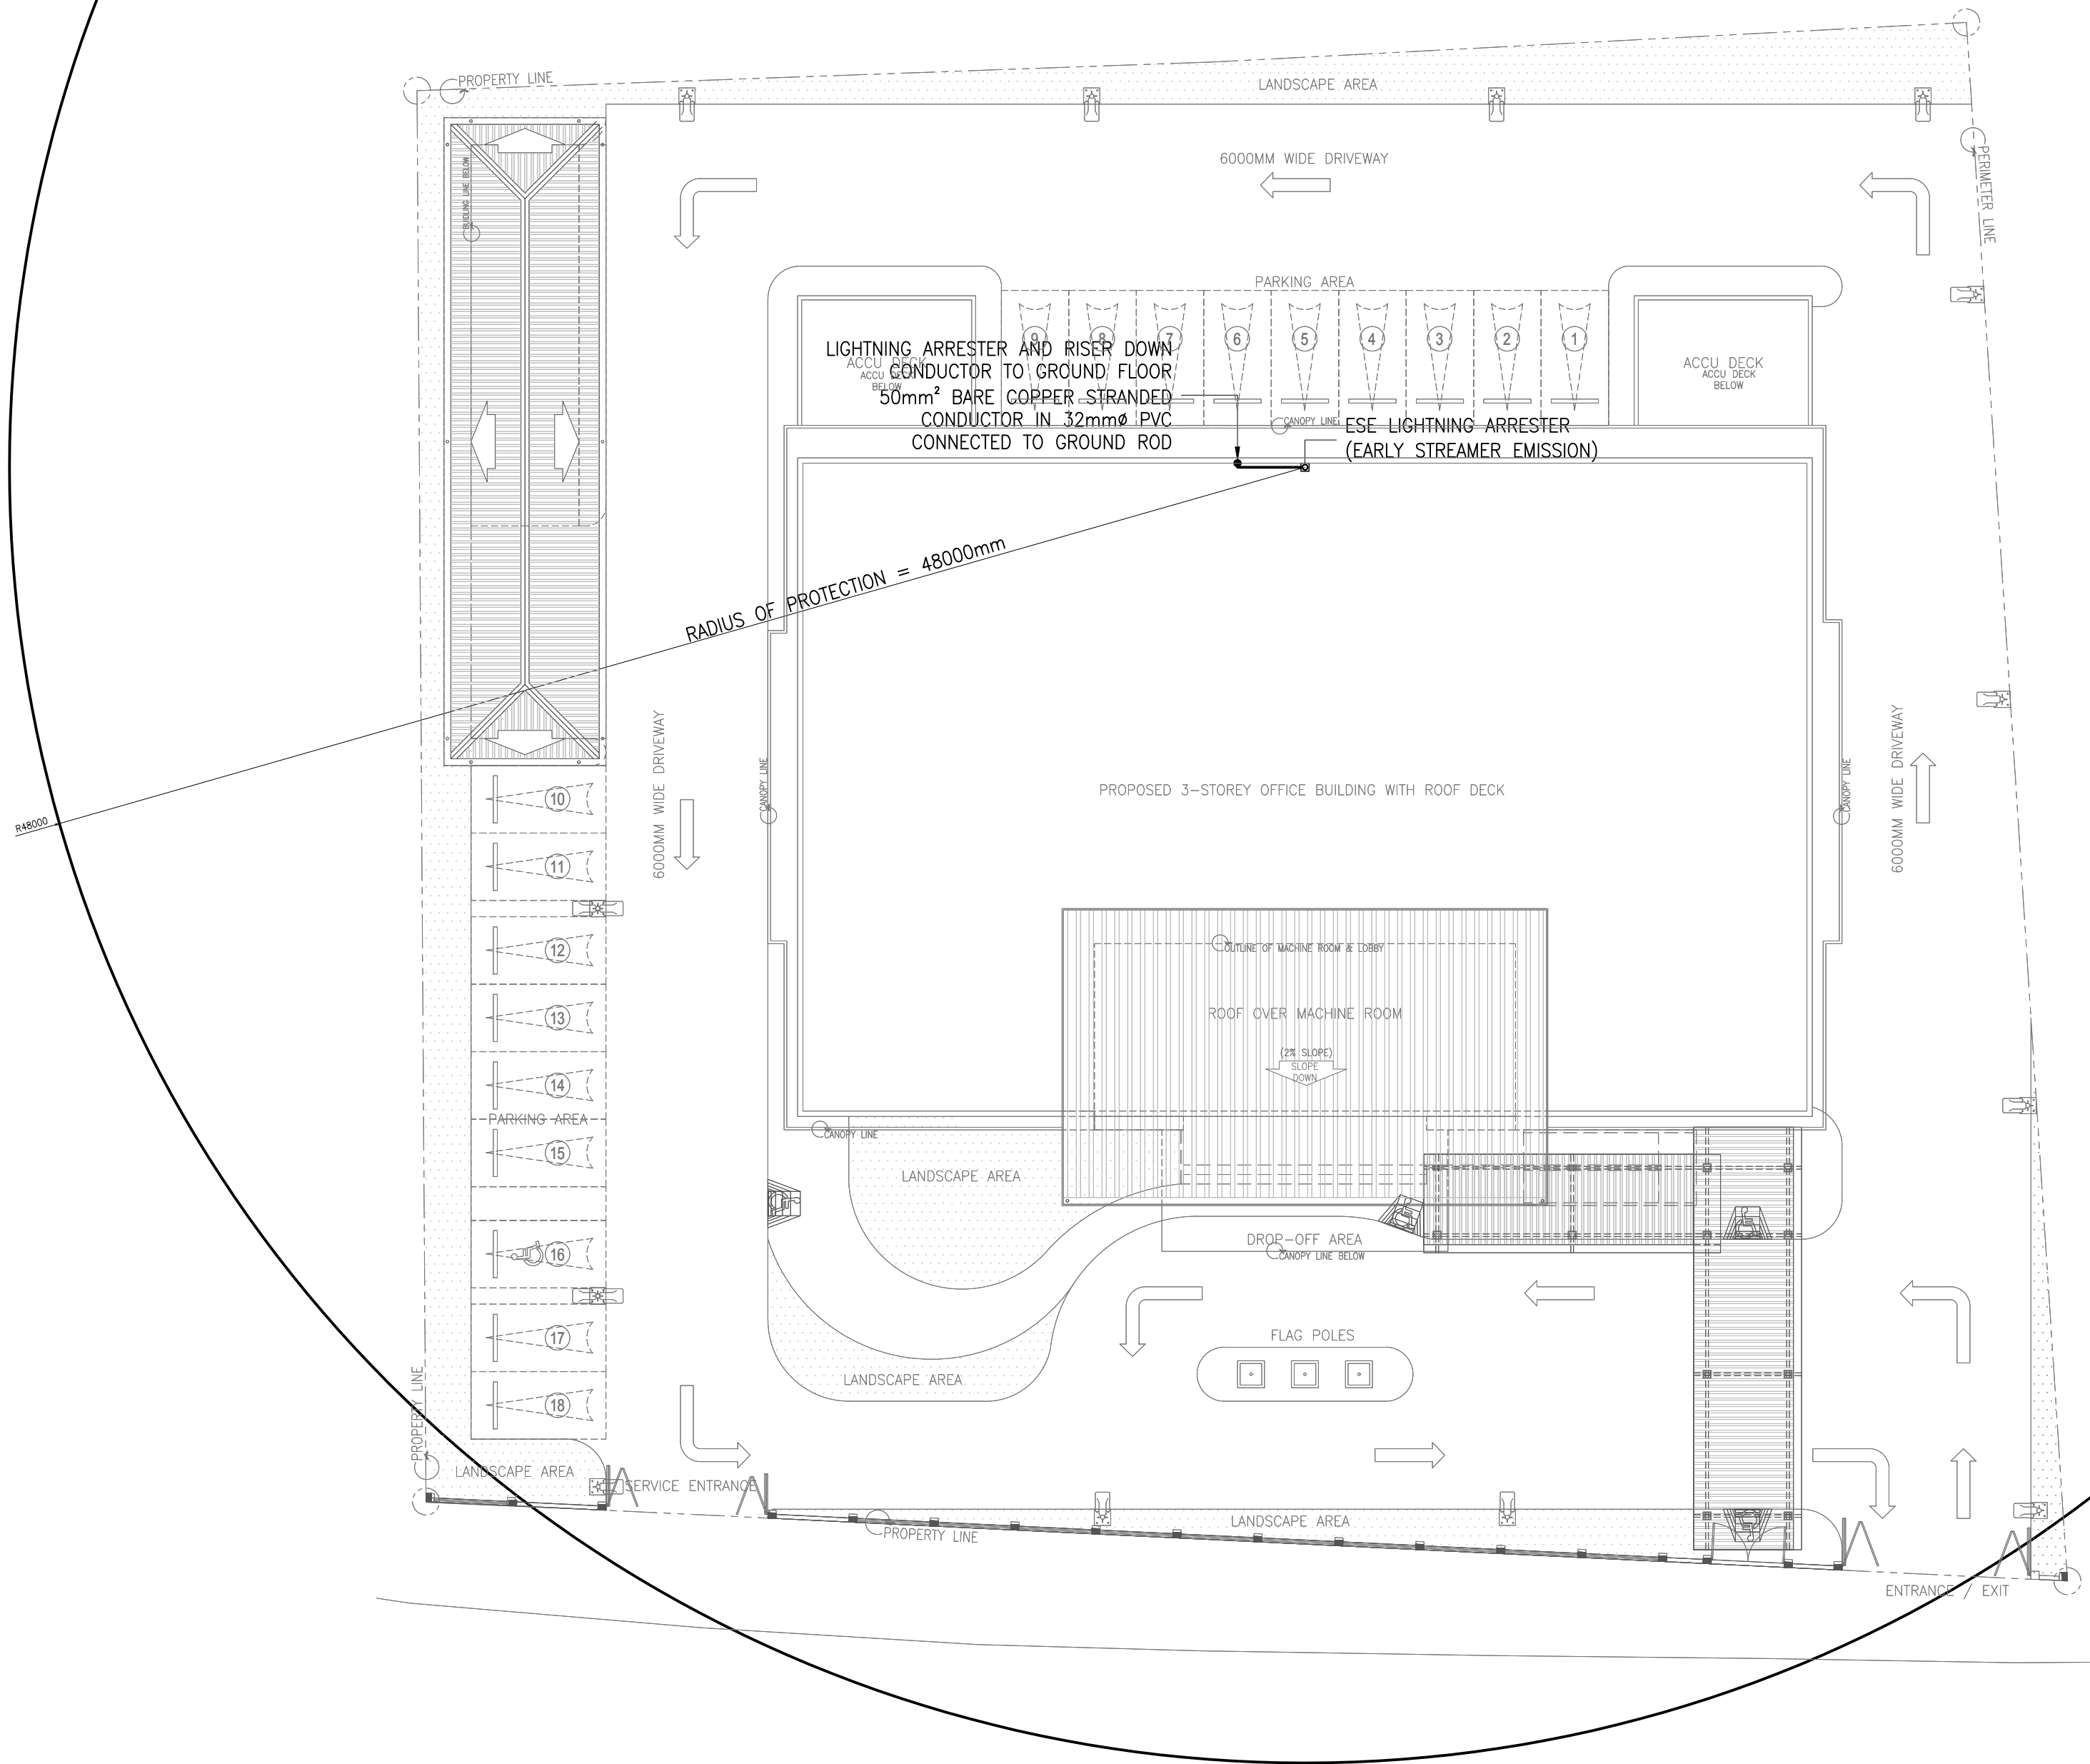

3 ROOF DECK LIGHTNING PROTECTION SYSTEM LAYOUT
E-0501 SCALE 1:200M

PANELBOARD NAME:				MDP-1		MAIN BREAKER:		AT	AF	POLE	VOLTAGE	TYPE: CENTER MAIN	
CIRCUIT NO.	VA	VOLTAGE	DEMAND FACTOR	DESCRIPTION	AMPERE				POLE	AMPERE TRIP (AT)	AMPERE FRAME (AF)	WIRE CODE	
					Ø AN	Ø BN	Ø CN	3Ø					
1	52125	400	80%	ACCU 1				75.24	3	200	225	Y80	
2	43750	400	80%	ACCU 2				63.15	3	150	225	Y50	
3	67500	400	80%	ACCU 3				97.43	3	250	400	Y125	
4	5000	400	65%	ELEVATOR				7.22	3	20	50	Y3.5	
5	33750	400	100%	PPACU	0.00	0.00	0.00	48.71	3	80	100	Y22	
6	170139	400	81%	EMDP	196.34	216.01	193.90	44.31	3	300	400	Y150	
7	11448	400	100%	PPFCU	16.84	14.86	18.07	0.00	3	50	50	Y8.0	
8		400		TVSS				0.00	3	30	50	Y5.5	
9		400		SPARE				0.00	3	50	50	-	
10		400		SPARE				0.00	3	50	50	-	
	383712			TOTAL	213.18	230.88	211.98	336.06	30				
PANELBOARD DESCRIPTION								FEEDER WIRE SIZE:		3Y125	(SEE WIRING AND CONDUIT CODE)		
LOCATION:		ELECTRICAL ROOM @ GF		MAIN KAIC:		42 KAIC							
ENCLOSURE:		NEMA 1		BRANCH KAIC:		22 KAIC		NOTES:		1. USE INDUSTRIAL TYPE CIRCUIT BREAKERS.			
MOUNTING:		SURFACE MOUNTED		BUS BRACING:		42 kA				2. PROVIDE GROUND TERMINAL BUS W/ CRIMP LUGS.			
VOLTAGE:		400 V		DEM. FACTOR:		83%				3. BUS BARS SHALL BE SILVER PLATED.			
AMPERES:		468.22		FED FROM:		POWER UTILITY				4. ALL EQUIPMENT SHALL BE RATED 60Hz.			

PANELBOARD NAME:				EMDP		MAIN BREAKER:		AT	AF	POLE	VOLTAGE	TYPE: CENTER MAIN	
CIRCUIT NO.	VA	VOLTAGE	DEMAND FACTOR	DESCRIPTION	AMPERE				POLE	AMPERE TRIP (AT)	AMPERE FRAME (AF)	WIRE CODE	
					Ø AN	Ø BN	Ø CN	3Ø					
1	75247	400	79%	EPP1	61.52	71.82	60.35	44.31	3	150	225	Y50	
2	48020	400	82%	EPP2	66.30	75.18	67.30	0.00	3	100	100	Y30	
3	46872	400	82%	EPP3	68.52	69.02	66.25	0.00	3	100	100	Y30	
4		400		SPARE				0.00	3	50	50	-	
	170139			TOTAL	196.34	216.01	193.90	44.31	12				
PANELBOARD DESCRIPTION								FEEDER WIRE SIZE:		Y150	(SEE WIRING AND CONDUIT CODE)		
LOCATION:		ELECTRICAL ROOM @ GF		MAIN KAIC:		22 KAIC							
ENCLOSURE:		NEMA 1		BRANCH KAIC:		22 KAIC		NOTES:		1. USE INDUSTRIAL TYPE CIRCUIT BREAKERS.			
MOUNTING:		SURFACE MOUNTED		BUS BRACING:		22 kA				2. PROVIDE GROUND TERMINAL BUS W/ CRIMP LUGS.			
VOLTAGE:		400 V		DEM. FACTOR:		81%				3. BUS BARS SHALL BE SILVER PLATED.			
AMPERES:		210.77		FED FROM:		MDP-1				4. ALL EQUIPMENT SHALL BE RATED 60Hz.			

PANELBOARD NAME:				FIRE PUMP & JOCKEY PUMP (NON-PANEL)		MAIN BREAKER:		AT	AF	POLE	VOLTAGE	TYPE:	CENTER MAIN
								600	600	3	400		
CIRCUIT NO.	VA	VOLTAGE	DEMAND FACTOR	DESCRIPTION	AMPERE				POLE	AMPERE TRIP (AT)	AMPERE FRAME (AF)	WIRE CODE	
					Ø AN	Ø BN	Ø CN	3Ø					
1	71358	400	100%	FIRE PUMP (50 HP)				83.00	3	500	600	Y50	
2	2979	400	100%	JOCKEY PUMP (2 HP)				4.30	3	30	50	Y3.5	
	74337			TOTAL	0.00	0.00	0.00	87.30	6				
PANELBOARD DESCRIPTION									FEEDER WIRE SIZE:		Y60	(SEE WIRING AND CONDUIT CODE)	
LOCATION:		UTILITY RM @ GF			MAIN KAIC:		42 KAIC		NOTES: 1. PROVIDE PANEL GROUNDING. 2. ALL EQUIPMENT SHALL BE RATED 60Hz.				
ENCLOSURE:		NEMA 1			BRANCH KAIC:		42 KAIC						
MOUNTING:					BUS BRACING:		42 KA						
VOLTAGE:		400 V			DEM. FACTOR:		100%						
AMPERES:		87.30			FED FROM:		ATS						


PANELBOARD NAME:				PPFCU		MAIN BREAKER:		AT	AF	POLE	VOLTAGE	TYPE:	CENTER MAIN
CIRCUIT NO.	VA	VOLTAGE	DEMAND FACTOR	DESCRIPTION	AMPERE				POLE	AMPERE TRIP (AT)	AMPERE FRAME (AF)		
					Ø AN	Ø BN	Ø CN	3Ø					
					1	855	230	100%				FCU(1-14,1-12,1-11,1-10,1-8,1-9)	3.72
2	839	230	100%	FCU(1-6,1-13,1-1,1-15)	3.65				1	20	50	S3.5	
3	1801	230	100%	FCU (1-16,1-2,1-3,1-4,1-5,1-7)		7.83			1	20	50	S3.5	
4	1618	230	100%	FCU (2-5,2-6,2-7,2-10,2-8)		7.03			1	20	50	S3.5	
5	615	230	100%	FCU (2-2,2-4,2-3,2-9)			2.67		1	20	50	S3.5	
6	792	230	100%	FCU(3-4,3-5,3-6,3-7,3-8)			3.44		1	20	50	S3.5	
7	1248	230	100%	FCU(3-11,3-9,3-10,3-12)	5.42				1	20	50	S3.5	
8	931	230	100%	FCU(3-14,3-13,3-1,3-2,3-3)	4.05				1	20	50	S3.5	
9		230		SPARE		0.00			1	20	50	-	
10		230		SPARE		0.00			1	20	50	-	
11	2750	230	100%	ACCU 1A/FCU 1A			11.96		1	20	50	S5.5	
12		230		SPARE			0.00		1	20	50	-	
	11448			TOTAL	16.84	14.86	18.07	0.00	12				
PANELBOARD DESCRIPTION								FEEDER WIRE SIZE:		Y8.0	(SEE WIRING AND CONDUIT CODE)		
LOCATION:				MAIN KAIC:		18 kAIC							
ENCLOSURE:				NEMA 1		BRANCH KAIC:		10 kAIC		NOTES:			
MOUNTING:				SURFACE MOUNTED		BUS BRACING:		18 kA		1. USE INDUSTRIAL TYPE CIRCUIT BREAKERS.			
VOLTAGE:				400 V		DEM. FACTOR:		100%		2. PROVIDE GROUND TERMINAL BUS W/ CRIMP LUGS.			
AMPERES:				18.07		FED FROM:		MDP-1		3. BUS BARS SHALL BE SILVER PLATED.			
										4. ALL EQUIPMENT SHALL BE RATED 60Hz.			

PANELBOARD NAME:				PPACU		MAIN BREAKER:		AT	AF	POLE	VOLTAGE	TTPE: CENTER MAIN	
								125	225	3	230		
CIRCUIT NO.	VA	VOLTAGE	DEMAND FACTOR	DESCRIPTION	AMPERE			POLE	AMPERE TRIP (AT)	AMPERE FRAME (AF)	WIRE CODE		
					Ø AB	Ø BC	Ø CA					3Ø	
1	6750	230	100%	ACCU 1B				16.94	3	40	50	T5.5	
2	6750	230	100%	ACCU 1B				16.94	3	40	50	T5.5	
3	6750	230	100%	ACCU 1B				16.94	3	40	50	T5.5	
4	6750	230	100%	ACCU 1B				16.94	3	40	50	T8.0	
5	6750	230	100%	ACCU 1B				16.94	3	40	50	T8.0	
6		230		SPARE				0.00	3	40	50	-	
33750				TOTAL	0.00	0.00		0.00	84.72	18			
PANELBOARD DESCRIPTION									FEEDER WIRE SIZE:		T38	(SEE WIRING AND CONDUIT CODE)	
LOCATION:		ELECTRICAL ROOM @ 2F		MAIN KAIC:		22 KAIC							
ENCLOSURE:		NEMA 1		BRANCH KAIC:		10 KAIC		NOTES:		1. USE INDUSTRIAL TTPE CIRCUIT BREAKERS.			
MOUNTING:		SURFACE MOUNTED		BUS BRACING:		22 kA				2. PROVIDE GROUND TERMINAL BUS W/ CRIMP LUGS.			
VOLTAGE:		230 V		DEM. FACTOR:		100%				3. BUS BARS SHALL BE SILVER PLATED.			
AMPERES:		84.72		FED FROM:		MDP-1				4. ALL EQUIPMENT SHALL BE RATED 60Hz.			

PANELBOARD NAME:				EPP1		MAIN BREAKER:		AT	AF	POLE	VOLTAGE	TYPE: CENTER MAIN	
CIRCUIT NO.	VA	VOLTAGE	DEMAND FACTOR	DESCRIPTION	AMPERE				POLE	AMPERE TRIP (AT)	AMPERE FRAME (AF)	WIRE CODE	
					Ø AN	Ø BN	Ø CN	3Ø					
1	9699	400	65%	BOOSTER PUMP				14.00	3	40	50	Y8.0	
2	21000	400	80%	WATER METER TEST BENCH				30.31	3	80	100	Y22	
3	1500	230	65%	HAND DRYER @ FEMALE PUBLIC TOILET	6.52				1	20	50	S3.5	
4	1500	230	65%	HAND DRYER @ MALE PUBLIC TOILET	6.52				1	20	50	S3.5	
5	3500	230	80%	WATER HEATER @ DEPUTY OFFICE		15.22			1	20	50	S5.5	
6	1127	230	80%	ELEVATOR SUMP PIT PUMP		4.90			1	20	50	S3.5	
7	2000	230	80%	OVEN @ CLEAN ROOM (WASTE WATER)			8.70		1	20	50	S3.5	
8	1000	230	80%	REF @ CLEAN ROOM (WASTE WATER)			4.35		1	20	50	S3.5	
9	2000	230	80%	OVEN @ CLEAN ROOM (DRINKING WATER)	8.70				1	20	50	S3.5	
10	1000	230	80%	REF @ CLEAN ROOM (DRINKING WATER)	4.35				1	20	50	S3.5	
11	1620	230	80%	9 CONVENIENCE OUTLETS @ TEST BENCH, LAB ROOM, TRAINING RM, OFFICE		7.04			1	20	50	S3.5	
12	1500	230	65%	HAND DRYER @ PUBLIC PWD		6.52			1	20	50	S3.5	
13	1440	230	80%	8 CONVENIENCE OUTLETS @ METERING EFFICIENCY DEPT, RECORDS/STORAGE RM			6.26		1	20	50	S3.5	
14	500	230	80%	WATER DISPENSER @ PANTRY - 1			2.17		1	20	50	S3.5	
15	1620	230	80%	9 CONVENIENCE OUTLETS @ METERING EFFICIENCY DEPT, DEPT MANAGER OFFICE	7.04				1	20	50	S3.5	
16	1620	230	80%	9 CONVENIENCE OUTLETS @ COMPLAINTS SERVICES MONITORING DEPT	7.04				1	20	50	S3.5	
17	1260	230	80%	7 CONVENIENCE OUTLETS @ DEPUTY OFFICE		5.48			1	20	50	S3.5	
18	500	230	80%	PROJECTOR		2.17			1	20	50	S3.5	
19	360	230	80%	2 CONVENIENCE OUTLETS @ ELECTRICAL AND PUMP RM			1.57		1	20	50	S3.5	
20	1080	230	80%	6 CONVENIENCE OUTLETS @ GAD/WELFARE FUND/RO-TUBIG/COOP, UTILITY RM			4.70		1	20	50	S3.5	
21	1440	230	80%	8 CONVENIENCE OUTLETS @ CLEAN RM, CLINIC	6.26				1	20	50	S3.5	
22	720	230	80%	4 CONVENIENCE OUTLETS @ SECURITY OFFICE	3.13				1	20	50	S3.5	
23	540	230	80%	3 CONVENIENCE OUTLETS @ LABORATORY		2.35			1	20	50	S3.5	
24	5471	230	99%	ELP1		23.79			1	30	50	S5.5	
25	1500	230	65%	HAND DRYER @ FEMALE EMPLOYEE'S TOILET			6.52		1	20	50	S3.5	
26	1500	230	65%	HAND DRYER @ MALE EMPLOYEE'S TOILET			6.52		1	20	50	S3.5	
27		230		SPARE	0.00				1	20	50	-	
28		230		SPARE	0.00				1	20	50	-	
29	1000	230	100%	POWER PROVISION FOR ELECTRONIC DOOR WITH XRAY AND MONITOR		4.35			1	20	50	S3.5	
30		230		SPARE		0.00			1	20	50	-	
31	3000	230	100%	UPS			13.04		1	20	50	S5.5	
32	1500	230	65%	HAND DRYER @ PWD			6.52		1	20	50	S3.5	
33	2750	230	100%	FAF 1	11.96				1	30	50	S3.5	
34		230		SPARE	0.00				1	20	50	-	
35		230		SPARE		0.00			1	20	50	-	
36		230		SPARE		0.00			1	20	50	-	
	75247			TOTAL	61.52	71.82	60.35	44.31	40				
PANELBOARD DESCRIPTION								FEEDER WIRE SIZE:		Y50	(SEE WIRING AND CONDUIT CODE)		
LOCATION:		ELECTRICAL ROOM @ GF		MAIN KAIC:		22 kAIC							
ENCLOSURE:		NEMA 1		BRANCH KAIC:		18 kAIC		NOTES:		1. USE INDUSTRIAL TYPE CIRCUIT BREAKERS.			
MOUNTING:		SURFACE MOUNTED		BUS BRACING:		22 kA				2. PROVIDE GROUND TERMINAL BUS W/ CRIMP LUGS.			
VOLTAGE:		400 V		DEM. FACTOR:		79%				3. BUS BARS SHALL BE SILVER PLATED.			
AMPERES:		92.24		FED FROM:		EMDP				4. ALL EQUIPMENT SHALL BE RATED 60Hz.			

PANELBOARD NAME:				ELP1		MAIN BREAKER:		AT 30	AF 50	POLE 1	VOLTAGE 230	TYPE:	CENTER MAIN		
CIRCUIT NO.	VA	VOLTAGE	DEMAND FACTOR	DESCRIPTION	AMPERE				POLE	AMPERE TRIP (AT)	AMPERE FRAME (AF)	WIRE CODE			
					Ø AN	Ø BN	Ø CN	1Ø							
1	207	230	100%	LIGHTS @ CANOPY				0.90	1	20	50	\$3.5			
2	940	230	100%	LIGHTS @ GF				4.09	1	20	50	\$3.5			
3	1209	230	100%	LIGHTS @ GF				5.26	1	20	50	\$3.5			
4	714	230	100%	LIGHTS @ GF				3.10	1	20	50	\$3.5			
5	480	230	100%	PARKING LIGHTS				2.09	1	20	50	\$3.5			
6	300	230	100%	PARKING LIGHTS				1.30	1	20	50	\$3.5			
7	360	230	80%	2 CONVENIENCE OUTLETS				1.57	1	20	50	\$3.5			
8	180	230	100%	BATTERY CHARGER				0.78	1	20	50	\$3.5			
9	237	230	100%	LIGHTS @ AUXILIARY BUILDING				1.03	1	20	50	\$3.5			
10	324	230	100%	PARKING LIGHTS				1.41	1	20	50	\$3.5			
11	54	230	100%	STEP LIGHTS				0.23	1	20	50	\$3.5			
12	108	230	100%	STEP LIGHTS				0.47	1	20	50	\$3.5			
13	81	230	100%	LANDSCAPE LIGHTS				0.35	1	20	50	\$3.5			
14	85	230	100%	LIGHTS @ FLAGPOLE AND RAMP				0.37	1	20	50	\$3.5			
15	192	230	100%	FENCE LIGHTS				0.83	1	20	50	\$3.5			
16		230		SPARE				0.00	1	20	50	-			
17		230		SPARE				0.00	1	20	50	-			
18		230		SPARE				0.00	1	20	50	-			
	5471			TOTAL	0.00	0.00		0.00	23.79	18					
PANELBOARD DESCRIPTION									FEEDER WIRE SIZE:		S5.5		(SEE WIRING AND CONDUIT CODE)		
LOCATION:		ELECTRICAL ROOM @ GF		MAIN KAIC:		10' KAIC									
ENCLOSURE:		NEMA 1		BRANCH KAIC:		10' KAIC		NOTES:		1. USE INDUSTRIAL TYPE CIRCUIT BREAKERS.					
MOUNTING:		SURFACE MOUNTED		BUS BRACING:		10' kA				2. PROVIDE GROUND TERMINAL BUS W/ CRIMP LUGS.					
VOLTAGE:		230 V		DEM. FACTOR:		99%				3. BUS BARS SHALL BE SILVER PLATED.					
AMPERES:		23.47		FED FROM:		EPP1				4. ALL EQUIPMENT SHALL BE RATED 60Hz.					

PANELBOARD NAME:				EPP2		MAIN BREAKER:		AT	AF	POLE	VOLTAGE	TYPE:	CENTER MAIN						
CIRCUIT NO.	VA	VOLTAGE	DEMAND FACTOR	DESCRIPTION	AMPERE				POLE	AMPERE TRIP (AT)	AMPERE FRAME (AF)	WIRE CODE							
					Ø AN	Ø BN	Ø CN	3Ø											
1	3500	230	80%	WATER HEATER @ FEMALE EMPLOYEE'S TOILET	15.22				1	20	50	\$3.5							
2	3500	230		SPARE	0.00				1	20	50	-							
3	3500	230	80%	WATER HEATER @ MALE EMPLOYEE'S TOILET		15.22			1	20	50	\$3.5							
4	1620	230	80%	9 CONVENIENCE OUTLETS @ WATER QUALITY MONITORING DEPT		7.04			1	20	50	\$3.5							
5	3500	230	80%	WATER HEATER @ DEPUTY ADMIN OFFICE			15.22		1	20	50	\$3.5							
6	3500	230	80%	WATER HEATER @ DEPUTY ADMIN OFFICE			15.22		1	20	50	\$3.5							
7	1500	230	80%	HAND DRYER @ FEMALE EMPLOYEE'S TOILET	6.52				1	20	50	\$3.5							
8	1500	230	80%	HAND DRYER @ MALE EMPLOYEE'S TOILET	6.52				1	20	50	\$3.5							
9	1500	230	80%	HAND DRYER @ PWD		6.52			1	20	50	\$3.5							
10	500	230	80%	WATER DISPENSER @ PANTRY - 4		2.17			1	20	50	\$3.5							
11	500	230	80%	WATER DISPENSER @ MESS HALL			2.17		1	20	50	\$3.5							
12	500	230	80%	WATER DISPENSER @ PANTRY - 3			2.17		1	20	50	\$3.5							
13	500	230	80%	WATER DISPENSER @ PANTRY - 2	2.17				1	20	50	\$3.5							
14	1440	230	80%	8 CONVENIENCE OUTLETS @ BAC RM, CONSULTANT'S RM, UTILITY RM	6.26				1	20	50	\$3.5							
15	720	230	80%	4 CONVENIENCE OUTLETS @ FITNESS GYM		3.13			1	20	50	\$3.5							
16	1260	230	80%	7 CONVENIENCE OUTLETS @ MESS HALL, DEPT MANAGER		5.48			1	20	50	\$3.5							
17	1620	230	80%	9 CONVENIENCE OUTLETS @ CONSULTANT'S RM			7.04		1	20	50	\$3.5							
18	1800	230	80%	10 CONVENIENCE OUTLETS @ CONSULTANT'S RM			7.83		1	20	50	\$3.5							
19	720	230	80%	4 CONVENIENCE OUTLETS @ STORAGE, LOBBY	3.13				1	20	50	\$3.5							
20	1440	230	80%	8 CONVENIENCE OUTLETS @ TARIFF CONTROL AND MONITORING DEPT, STORAGE	6.26				1	20	50	\$3.5							
21	1620	230	80%	9 CONVENIENCE OUTLETS @ FINANCIAL AUDIT AND ASSET MONITORING DEPT		7.04			1	20	50	\$3.5							
22	1620	230	80%	9 CONVENIENCE OUTLETS @ OPERATIONS MONITORING DEPT		7.04			1	20	50	\$3.5							
23	1800	230	80%	10 CONVENIENCE OUTLETS @ DEPUTY ADMINISTRATOR OFFICE			7.83		1	20	50	\$3.5							
24	1260	230	80%	7 CONVENIENCE OUTLETS @ DEPUTY ADMIN OFFICE, OPERATIONS MONITORING DEPT			5.48		1	20	50	\$3.5							
25	1800	230	80%	10 CONVENIENCE OUTLETS @ MEETING ROOM	7.83				1	20	50	\$3.5							
26	1170	230	100%	LIGHTS @ 2F	5.09				1	20	50	\$3.5							
27	2750	230	80%	FAF 2		11.96			1	20	50	\$3.5							
28	1031	230	100%	LIGHTS @ 2F		4.48			1	20	50	\$3.5							
29	500	230	80%	PROJECTOR			2.17		1	20	50	\$3.5							
30	500	230	80%	PROJECTOR			2.17		1	20	50	\$3.5							
31	1095	230	100%	LIGHTS @ 2F	4.76				1	20	50	\$3.5							
32	584	230	100%	LIGHTS @ 2F	2.54				1	20	50	\$3.5							
33	1170	230	100%	LIGHTS @ 2F		5.09			1	20	50	\$3.5							
34		230	100%	SPARE		0.00			1	20	50	-							
35		230		SPARE			0.00		1	20	50	-							
36		230		SPARE			0.00		1	20	50	-							
37		230		SPACE	0.00				1		50	-							
38		230		SPACE	0.00				1		50	-							
39		230		SPACE			0.00		1		50	-							
40		230		SPACE			0.00		1		50	-							
41		230		SPACE		0.00			1		50	-							
42		230		SPACE		0.00			1		50	-							
48020				TOTAL	66.30	75.18	67.30	0.00	42										
PANELBOARD DESCRIPTION														FEEDER WIRE SIZE:		Y30		(SEE WIRING AND CONDUIT CODE)	
LOCATION:		ELECTRICAL ROOM @ 2F		MAIN KAIC:		18 KAIC													
ENCLOSURE:		NEMA 1		BRANCH KAIC:		10 KAIC		NOTES:		1. USE INDUSTRIAL TYPE CIRCUIT BREAKERS.									
MOUNTING:		SURFACE MOUNTED		BUS BRACING:		18 KA				2. PROVIDE GROUND TERMINAL BUS W/ CRIMP LUGS.									
VOLTAGE:		400 V		DEM. FACTOR:		82%				3. BUS BARS SHALL BE SILVER PLATED.									
AMPERES:		61.72		FED FROM:		EMDP				4. ALL EQUIPMENT SHALL BE RATED 60Hz.									

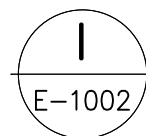







SCHEDULE OF LOADS

SCALE

NTS

a.c.o.n.g.
CONSULTING INC.
Engineering + Management
ISO 9001:2015 Certified
2F LTA Building 118 Perera Street, Legaspi Village, 1229 Makati City, Philippines
Tel. Nos. : +63 8 935827 Fax No. : +63 2 8935829
Email: acoconsulting@aco.com.ph Website: www.aco.com.ph

CERTIFIED BY		OWNER	PROJECT TITLE/LOCATION	CLIENT		SHEET CONTENTS	R.A. 9266 SEC. 33	CADD	DATE	NO.	REVISIONS	CHK	DATE	PAPER SIZE	SHEET NO.
RODEL JOSELITO B. MANABAT PROFESSIONAL ELECTRICAL ENGINEER	REG. NO.: 3402	METROPOLITAN WATERWORKS AND SEWERAGE SYSTEM REGULATORY OFFICE	3-STOREY OFFICE BUILDING WITH ROOF DECK	PROJECT PROPONENT	APPROVED BY:	SCHEDULE OF LOADS	DRAWINGS AND SPECIFICATIONS AND CONTRACT DOCUMENTS DULY SIGNED, STAMPED OR SEALED AS INSTRUMENTS FOR SERVICE ARE THE INTELLECTUAL PROPERTY AND DOCUMENTS OF ARCHITECT; WHETHER THE OBJECT FOR WHICH THEY ARE MADE IS EXECUTED OR NOT SHALL BE UNLAWFUL FOR ANY PERSON TO DUPLICATE OR TO MAKE COPIES OF SAID DOCUMENTS FOR USE IN THE REPERITION OF AND FOR OTHER PROJECTS OR BUILDINGS, WHETHER EXECUTED PARTLY OR IN WHOLE, WITHOUT THE WRITTEN CONSENT OF THE ARCHITECT OR AUTHOR OF SAID DOCUMENTS.	AVL	JUL 2018					20X30	E-1002
	TIN NO.: 158-336-047							DESIGNED	DATE					SCALE	PROJECT NO.
	PTR NO.: 2733331							RRVP	JUL 2018						
	DATE : JANUARY 23, 2018				<u>MELCHOR S. CORDOVA</u>	<u>PATRICK LESTER N. TY</u>		APPROVED	DATE					AS SHOWN	SO-G-17-036
	PLACE : MANDALUYONG CITY	MWSS COMPOUND, KATIPUNAN AVENUE, MATANGAND BALARA, QUEZON CITY	MWSS COMPOUND, KATIPUNAN AVENUE, MATANGAND BALARA, QUEZON CITY		ALTERNATE END-USUR FOR RO BUILDING	CHIEF REGULATOR, MWSS RO		RJBM	JUL 2018						

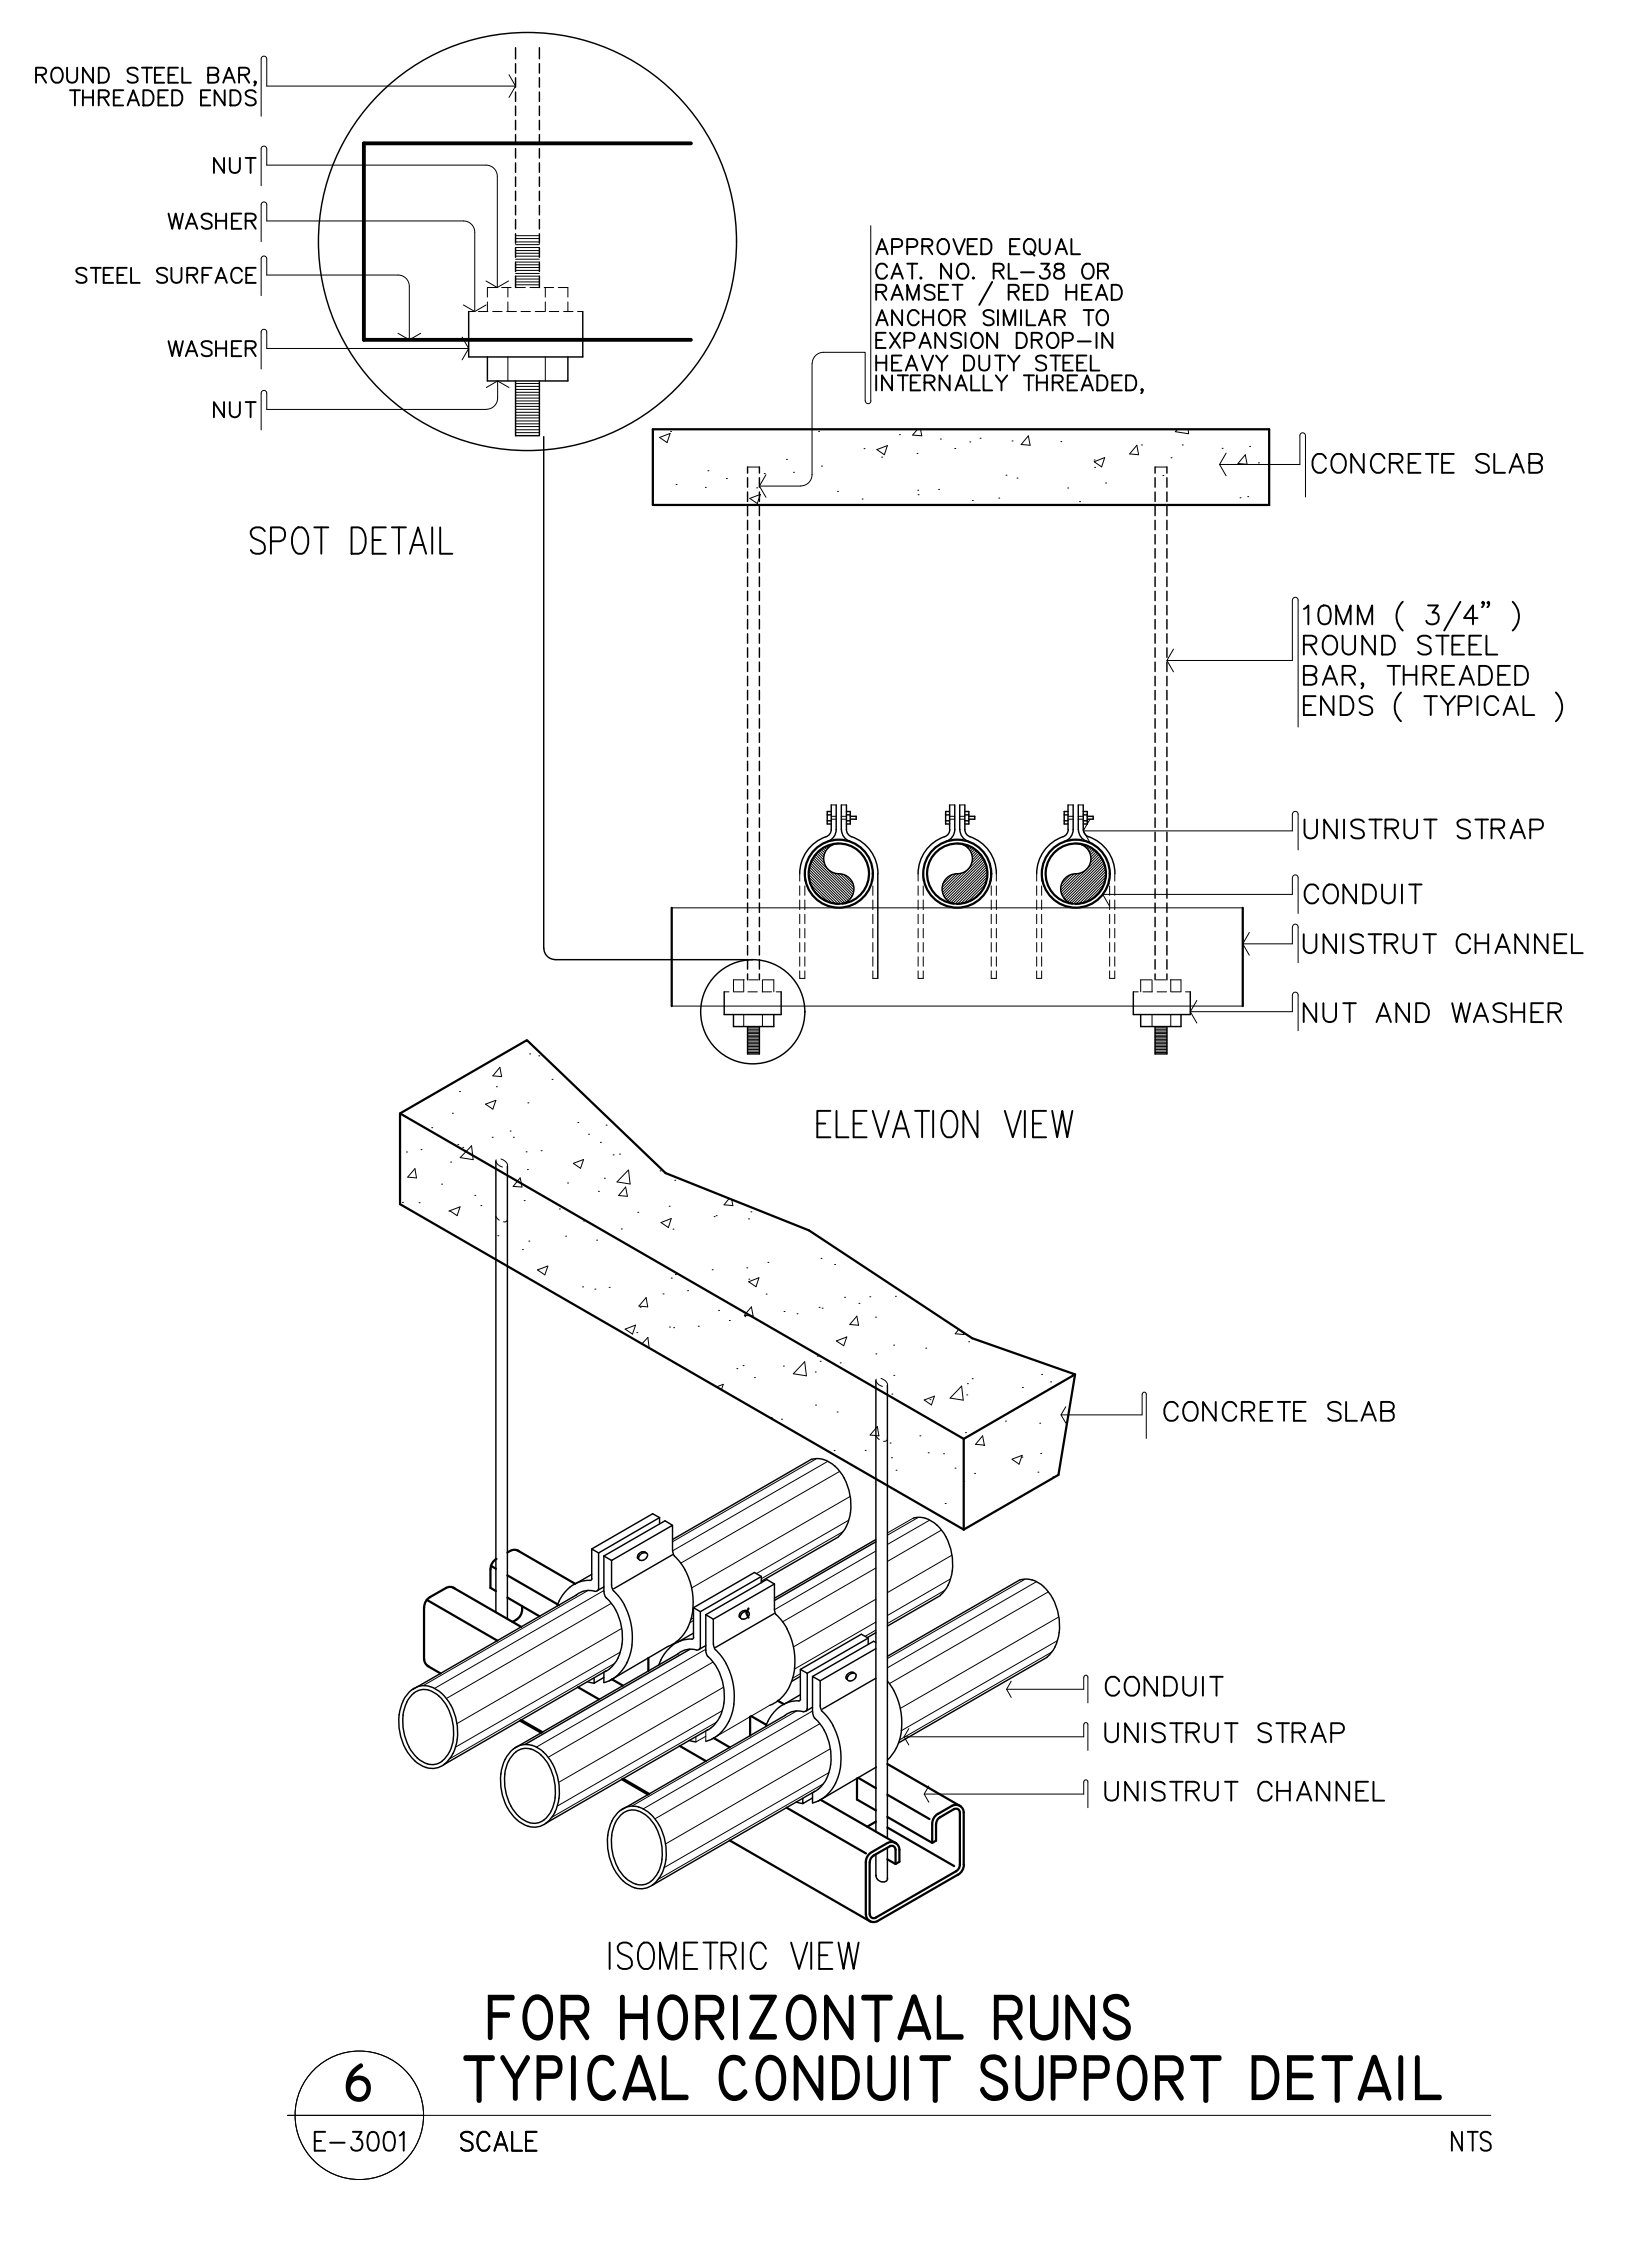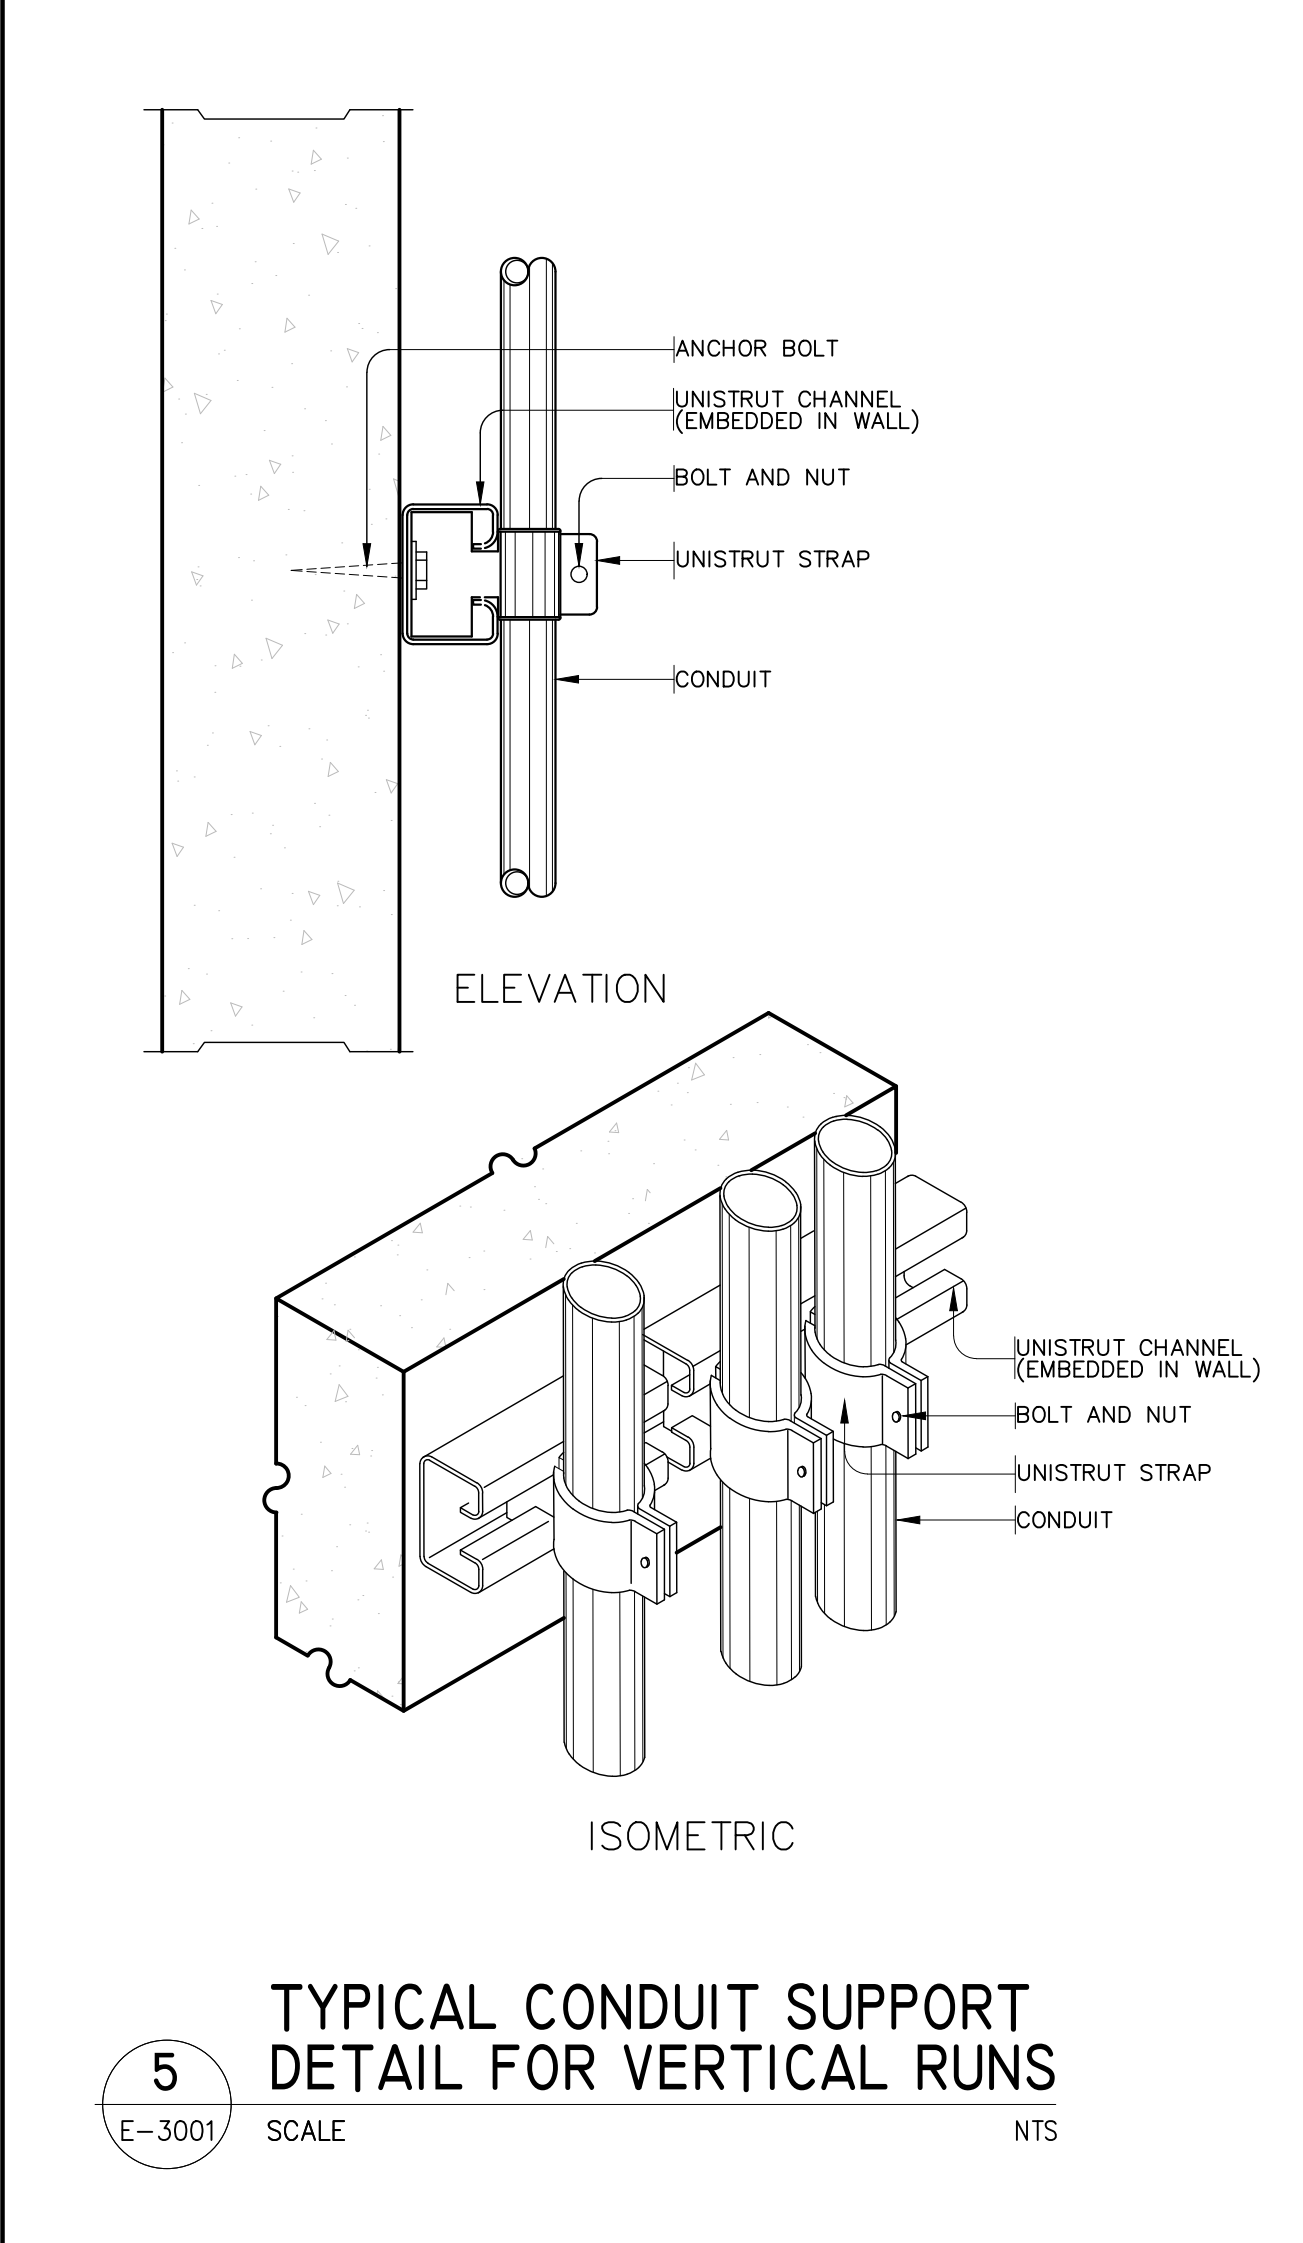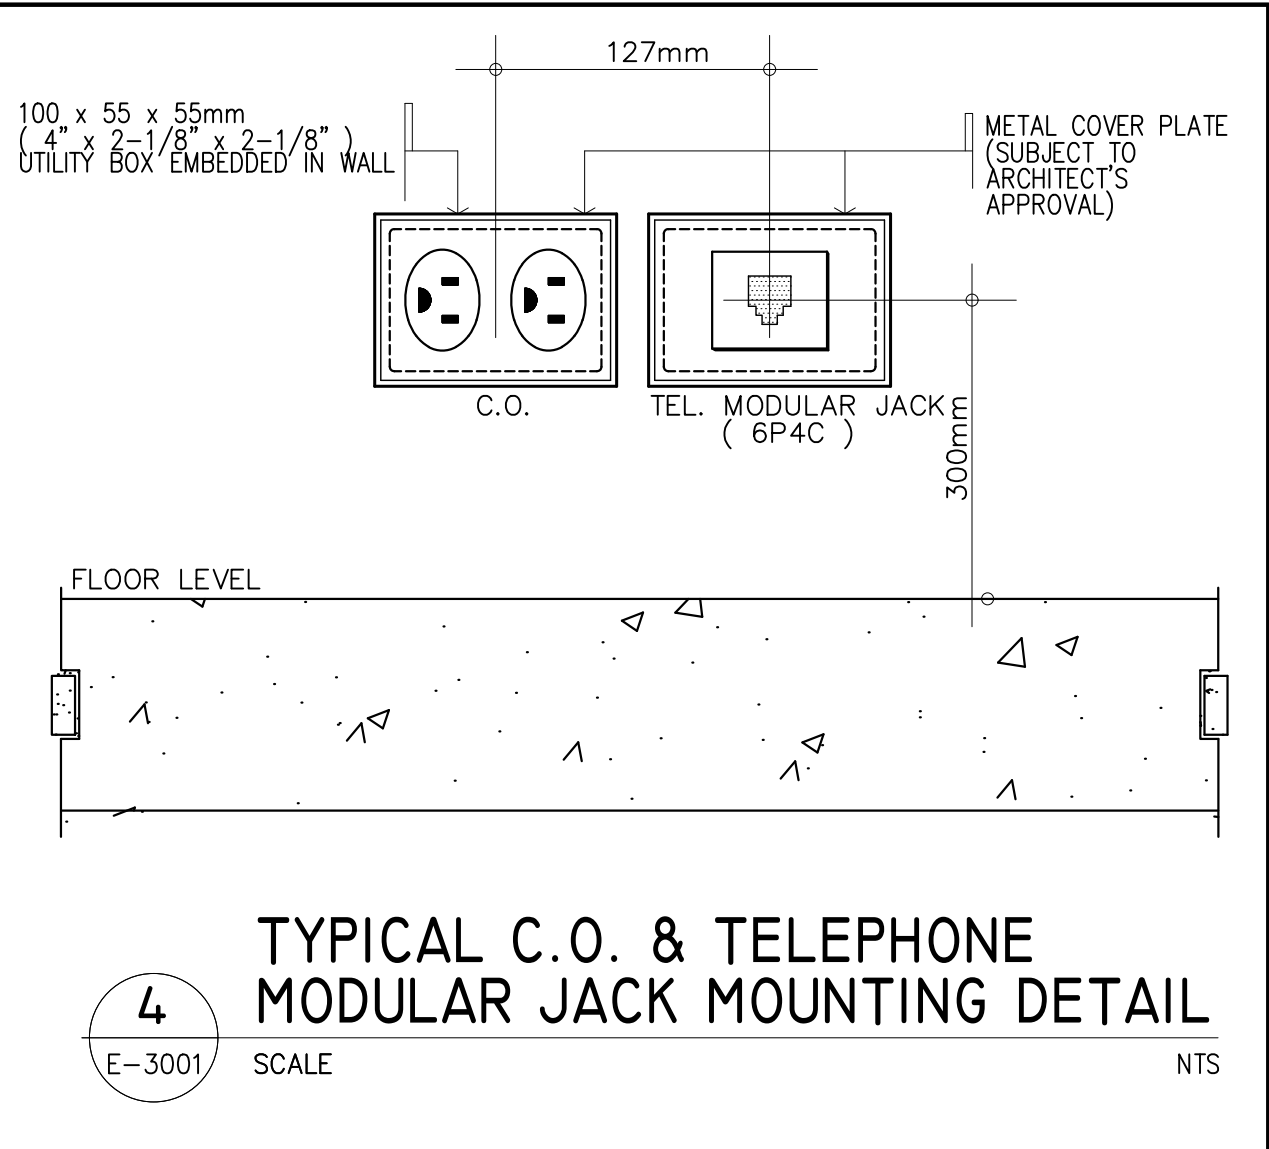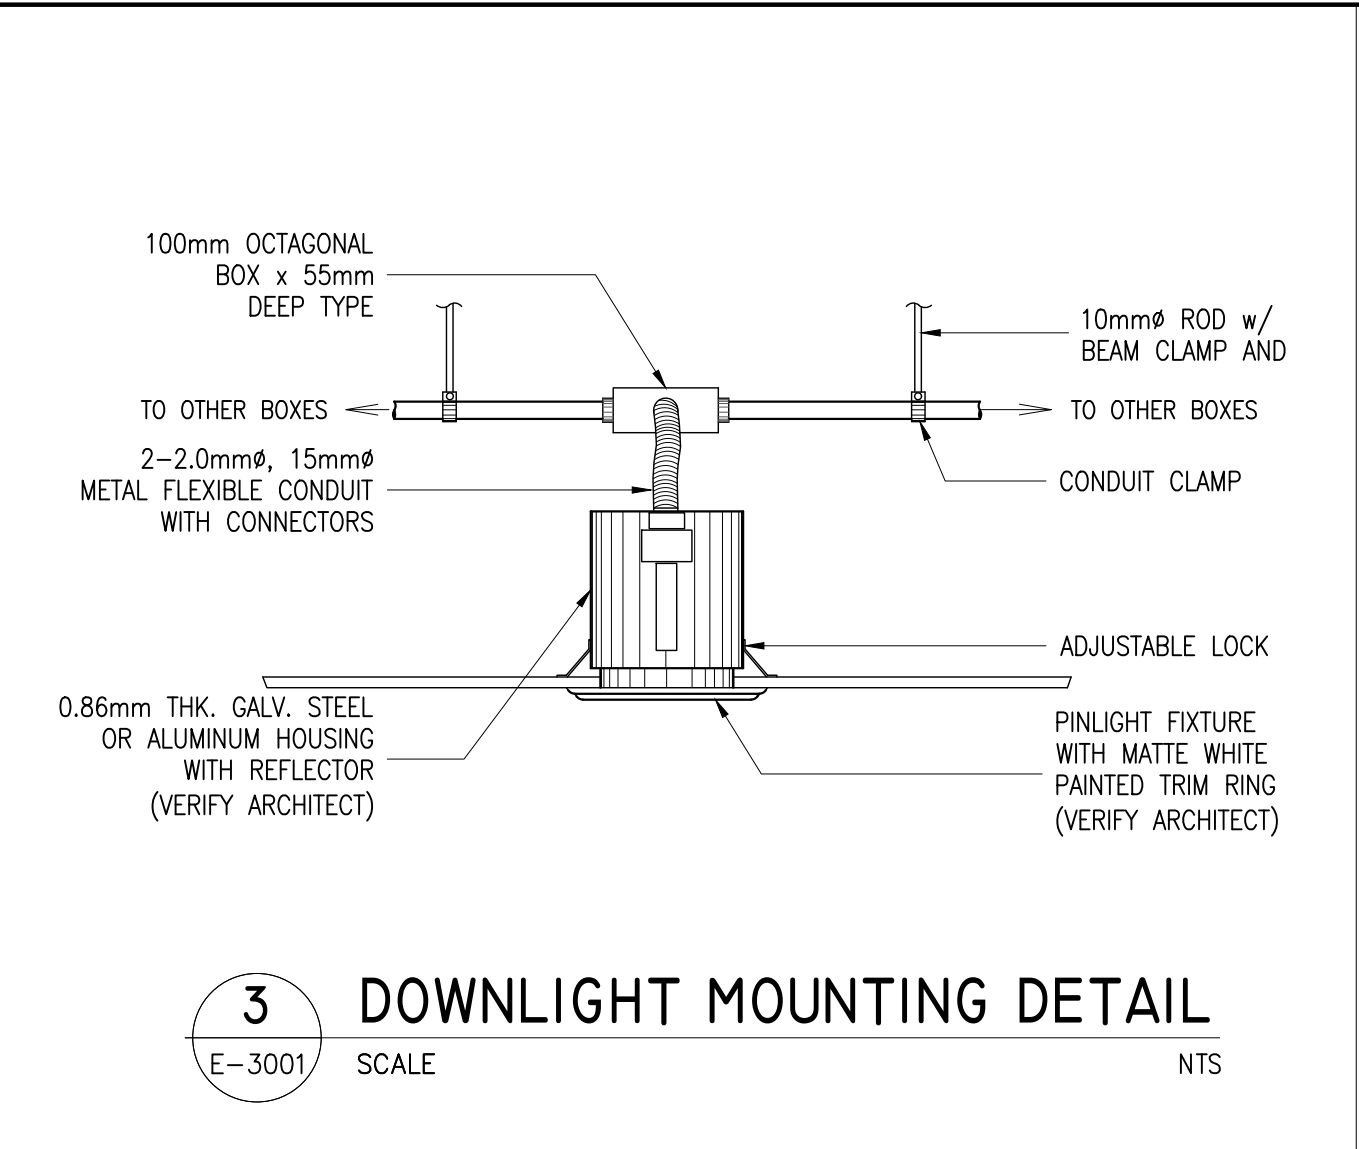
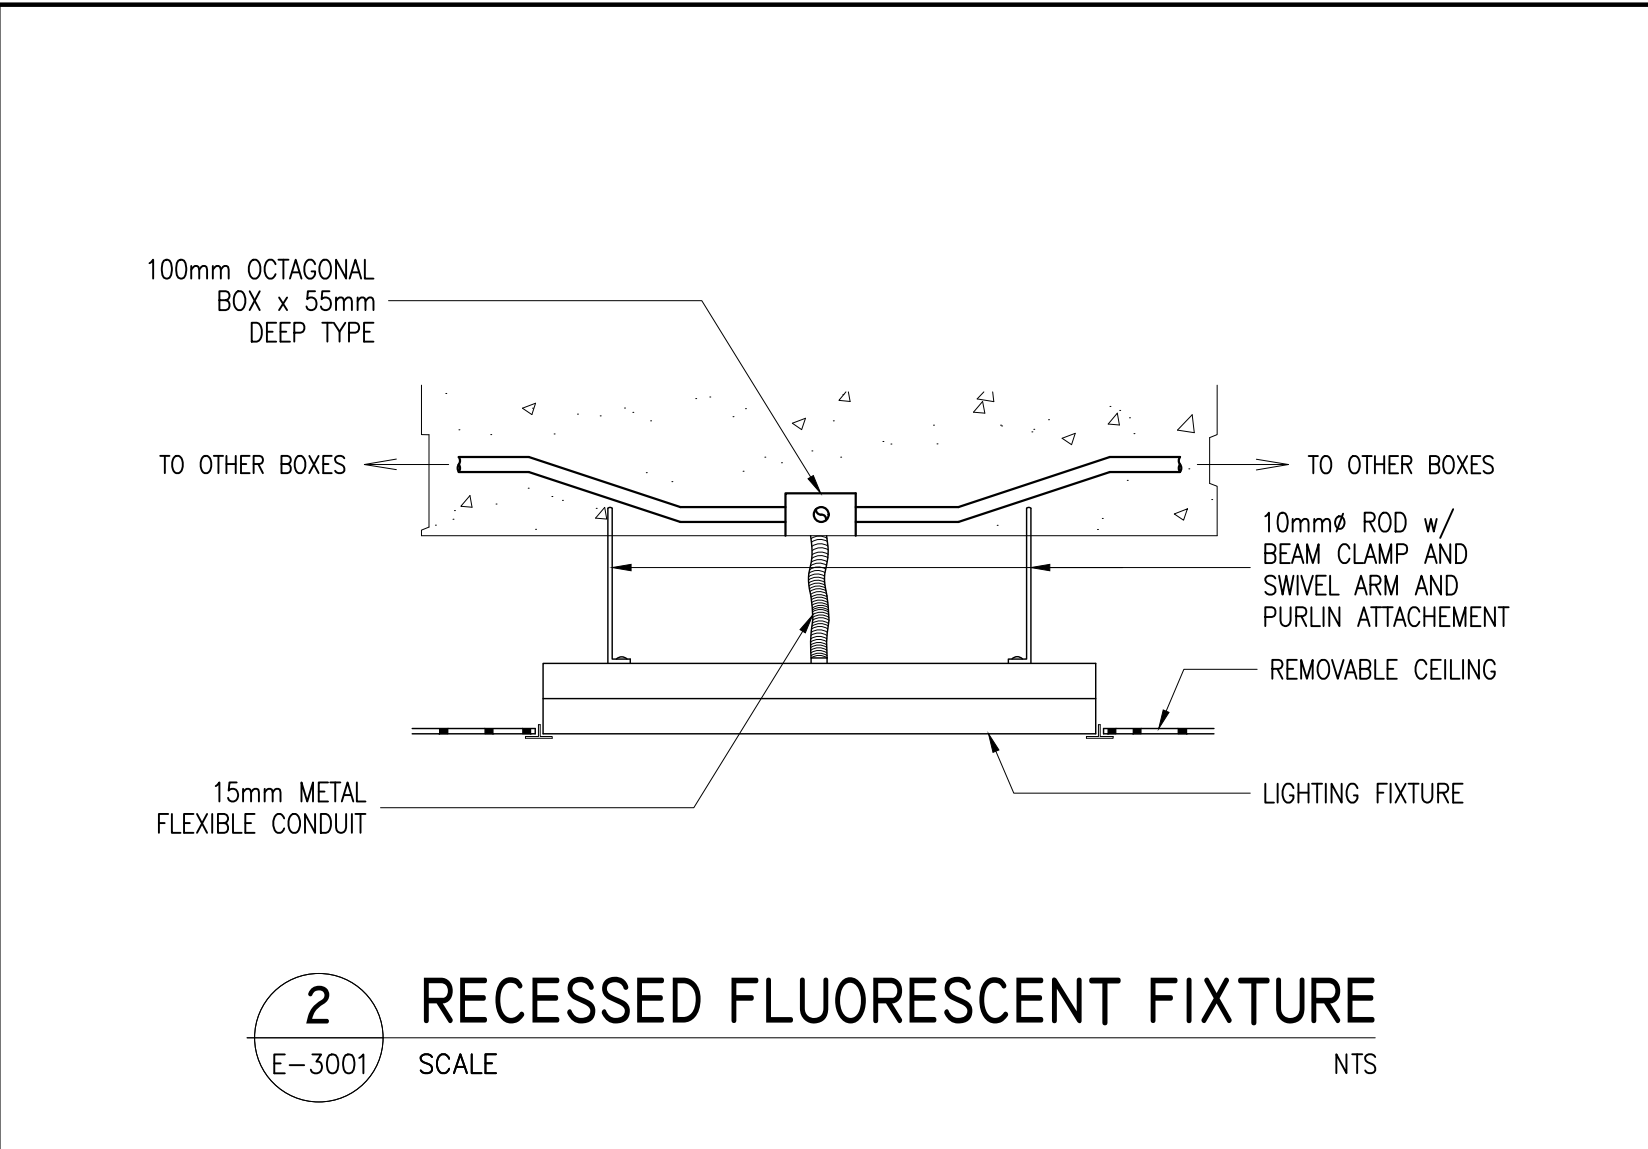
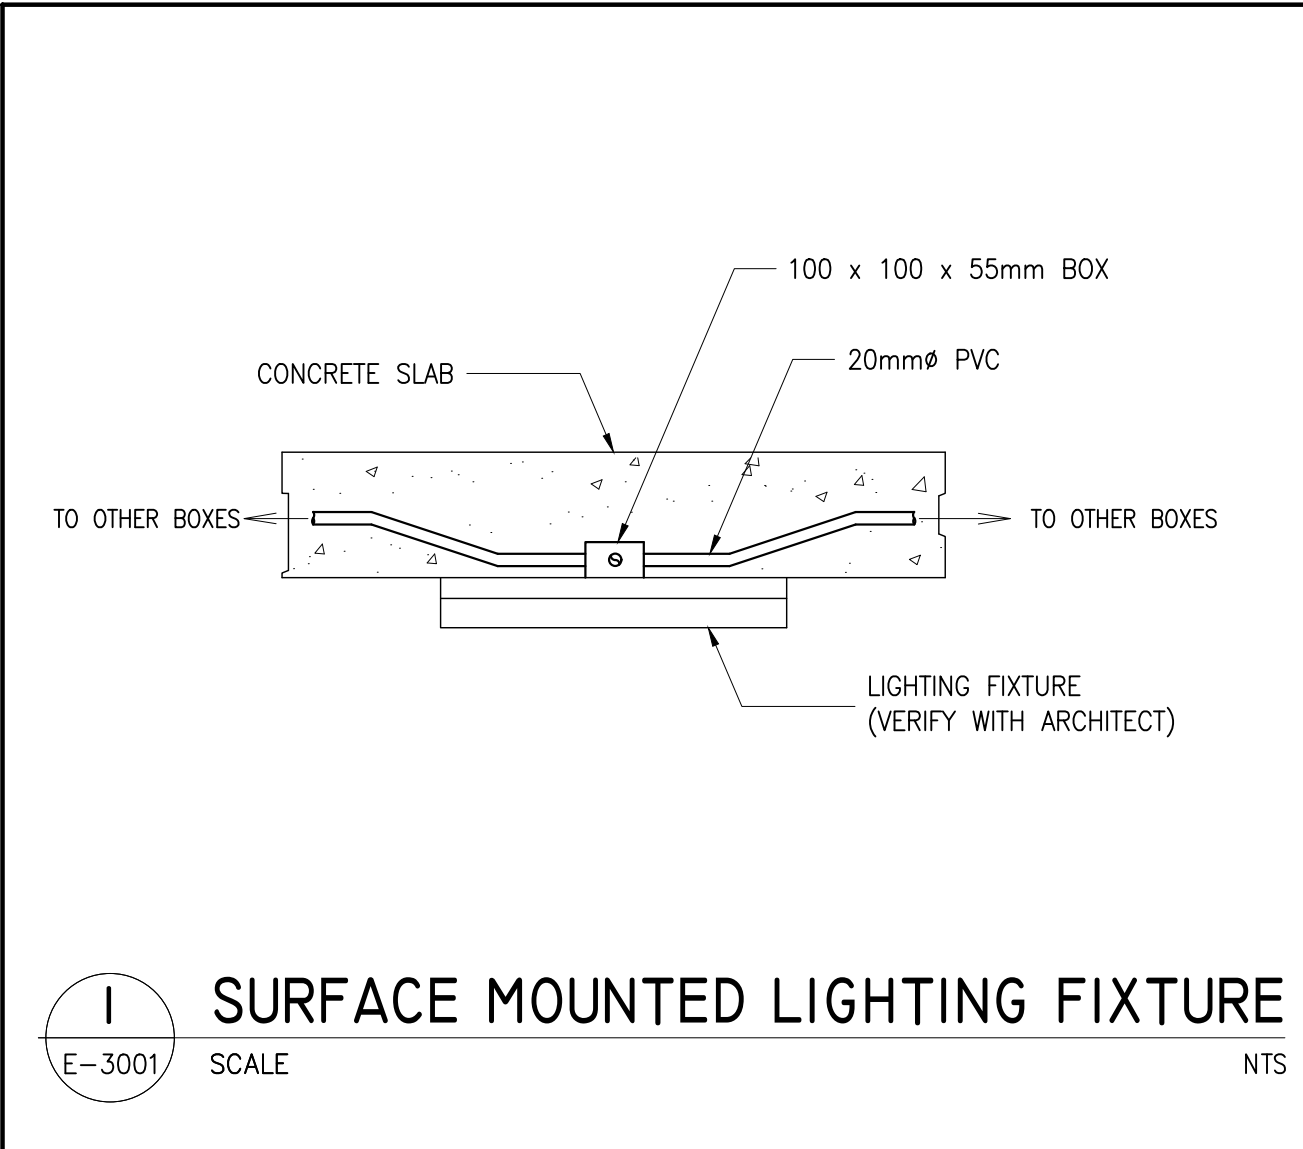


NOTE :
CABLE-SUPPORT BUSHING SHALL BE SCREWED AT THE END OF CONDUIT IN A CABINET, PULLBOX, OR CABLE-SUPPORT BOX.


SPACING FOR CONDUCTOR SUPPORTS		
WIRE SIZE	SUPPORT OF CONDUCTORS IN VERTICAL RACEWAY	
2.0mm ² THROUGH 8.0mm ²	NOT GREATER THAN	30.48M
14mm ² THROUGH 50mm ²	NOT GREATER THAN	30.48M
60mm ² THROUGH 100mm ²	NOT GREATER THAN	24.40M
OVER 100mm ² THROUGH 200mm ²	NOT GREATER THAN	18.29M
OVER 200mm ² THROUGH 250mm ²	NOT GREATER THAN	15.24M
OVER 250mm ² THROUGH 400mm ²	NOT GREATER THAN	12.19M
OVER 400mm ²	NOT GREATER THAN	10.67M

7 CABLE SUPPORT FOR VERTICAL RISERS DETAIL

E-3001 SCALE NTS

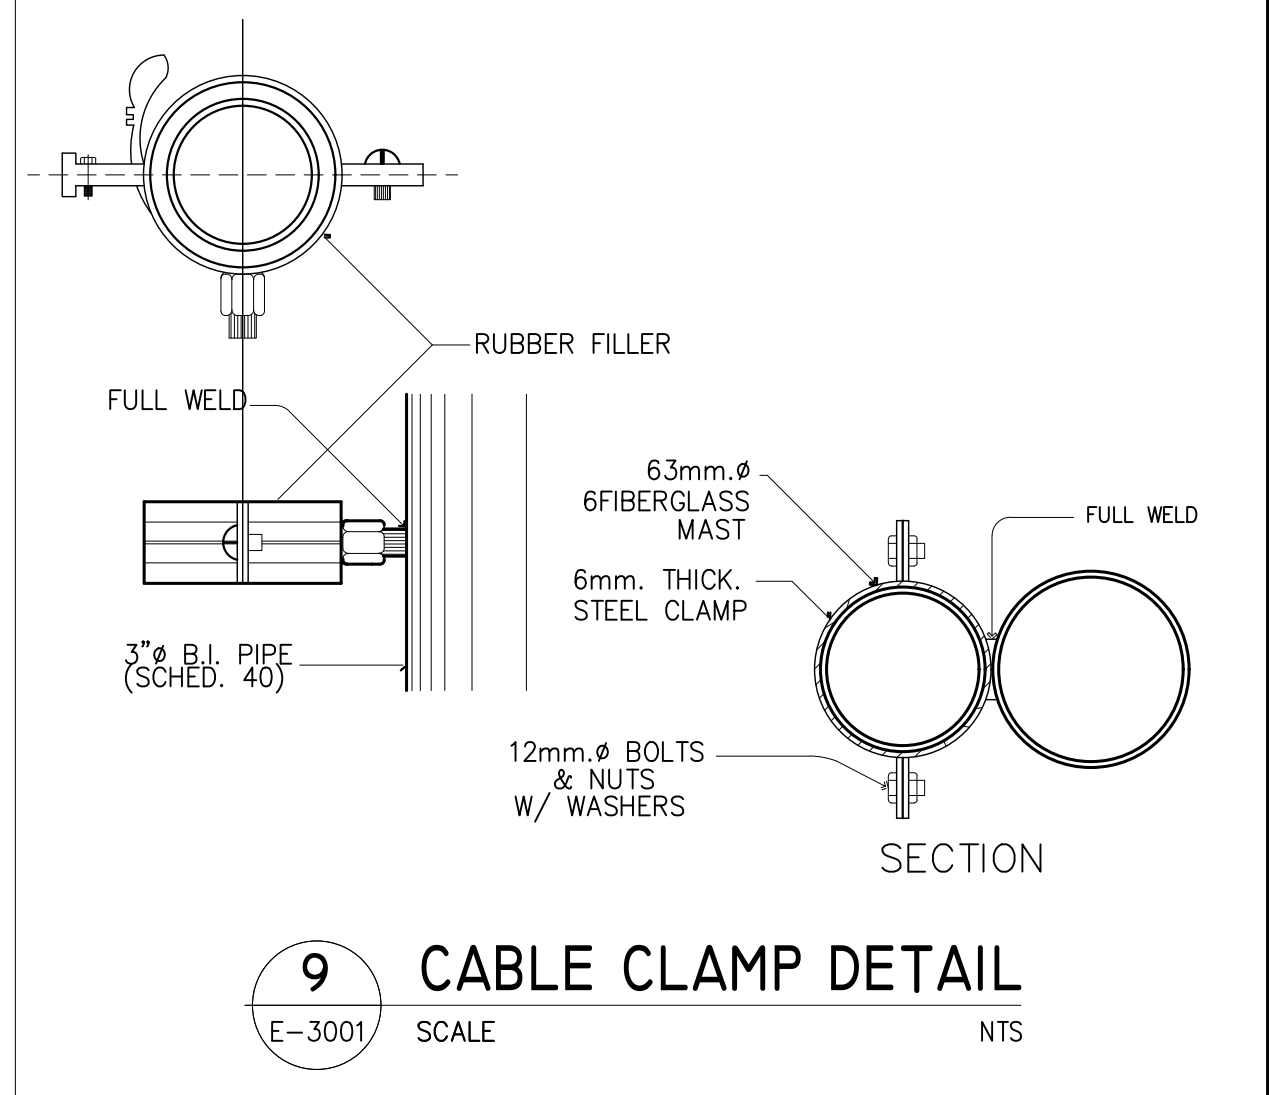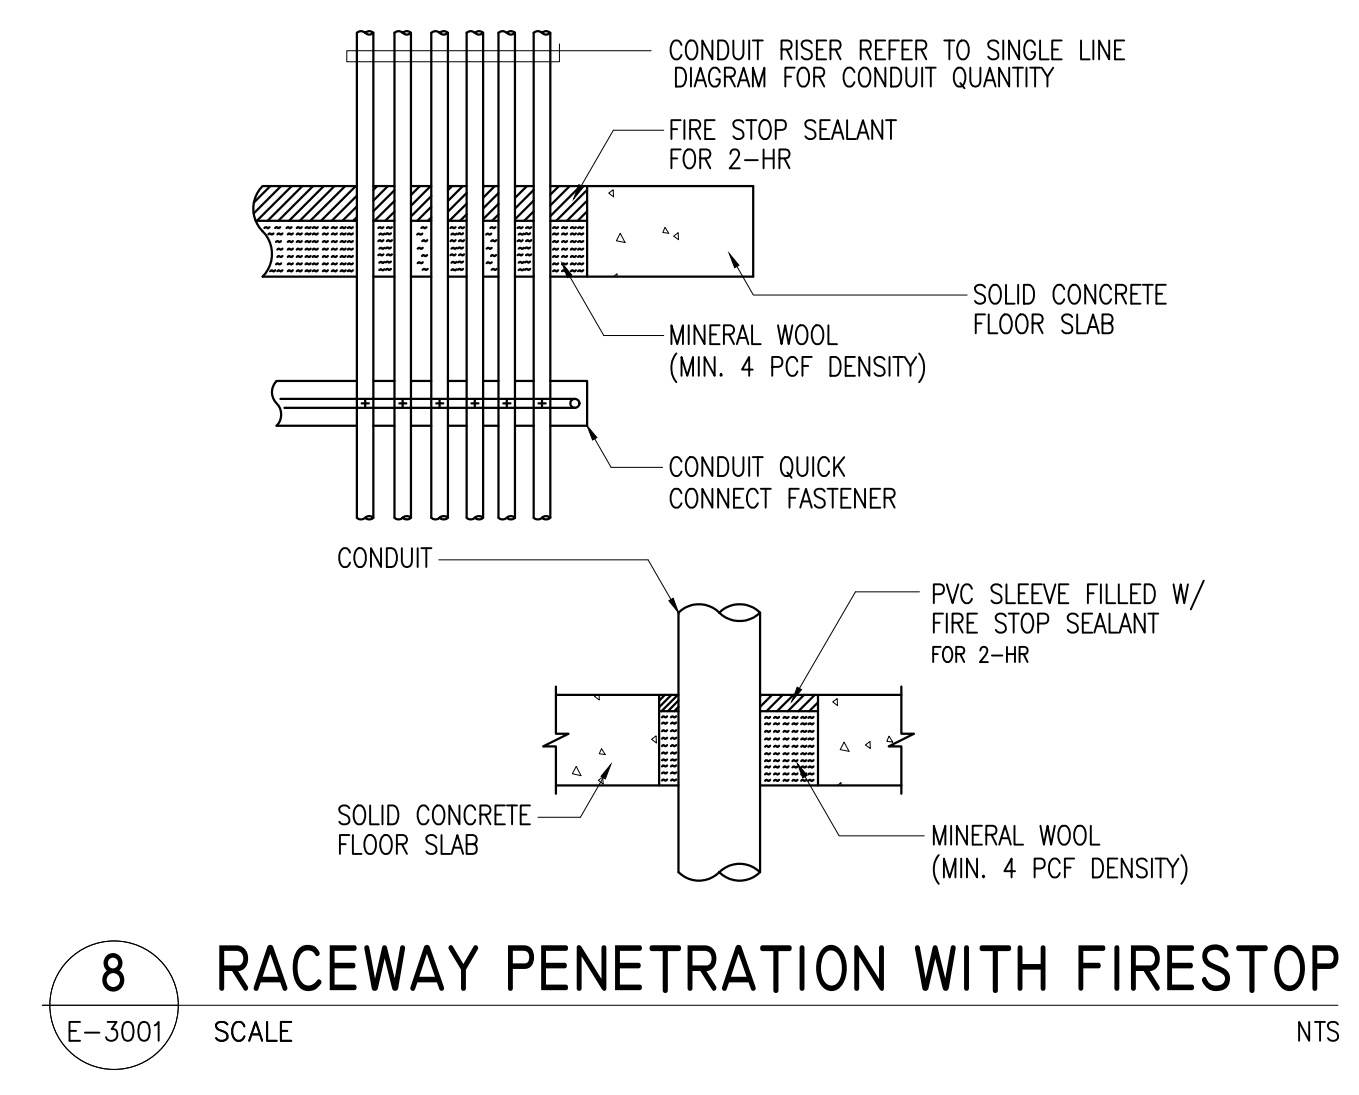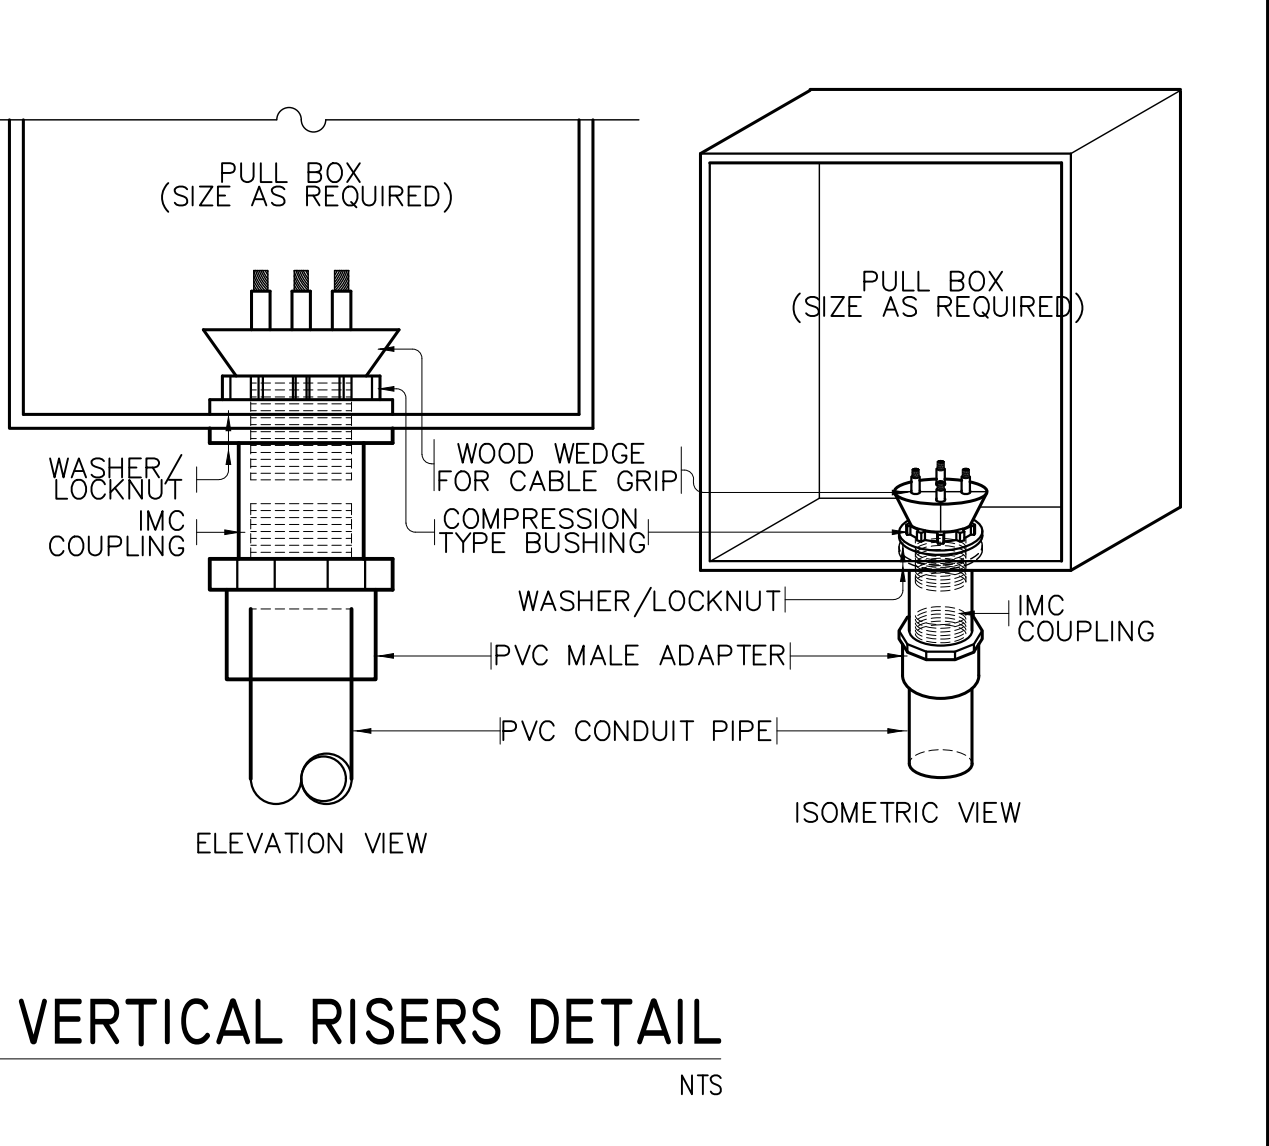



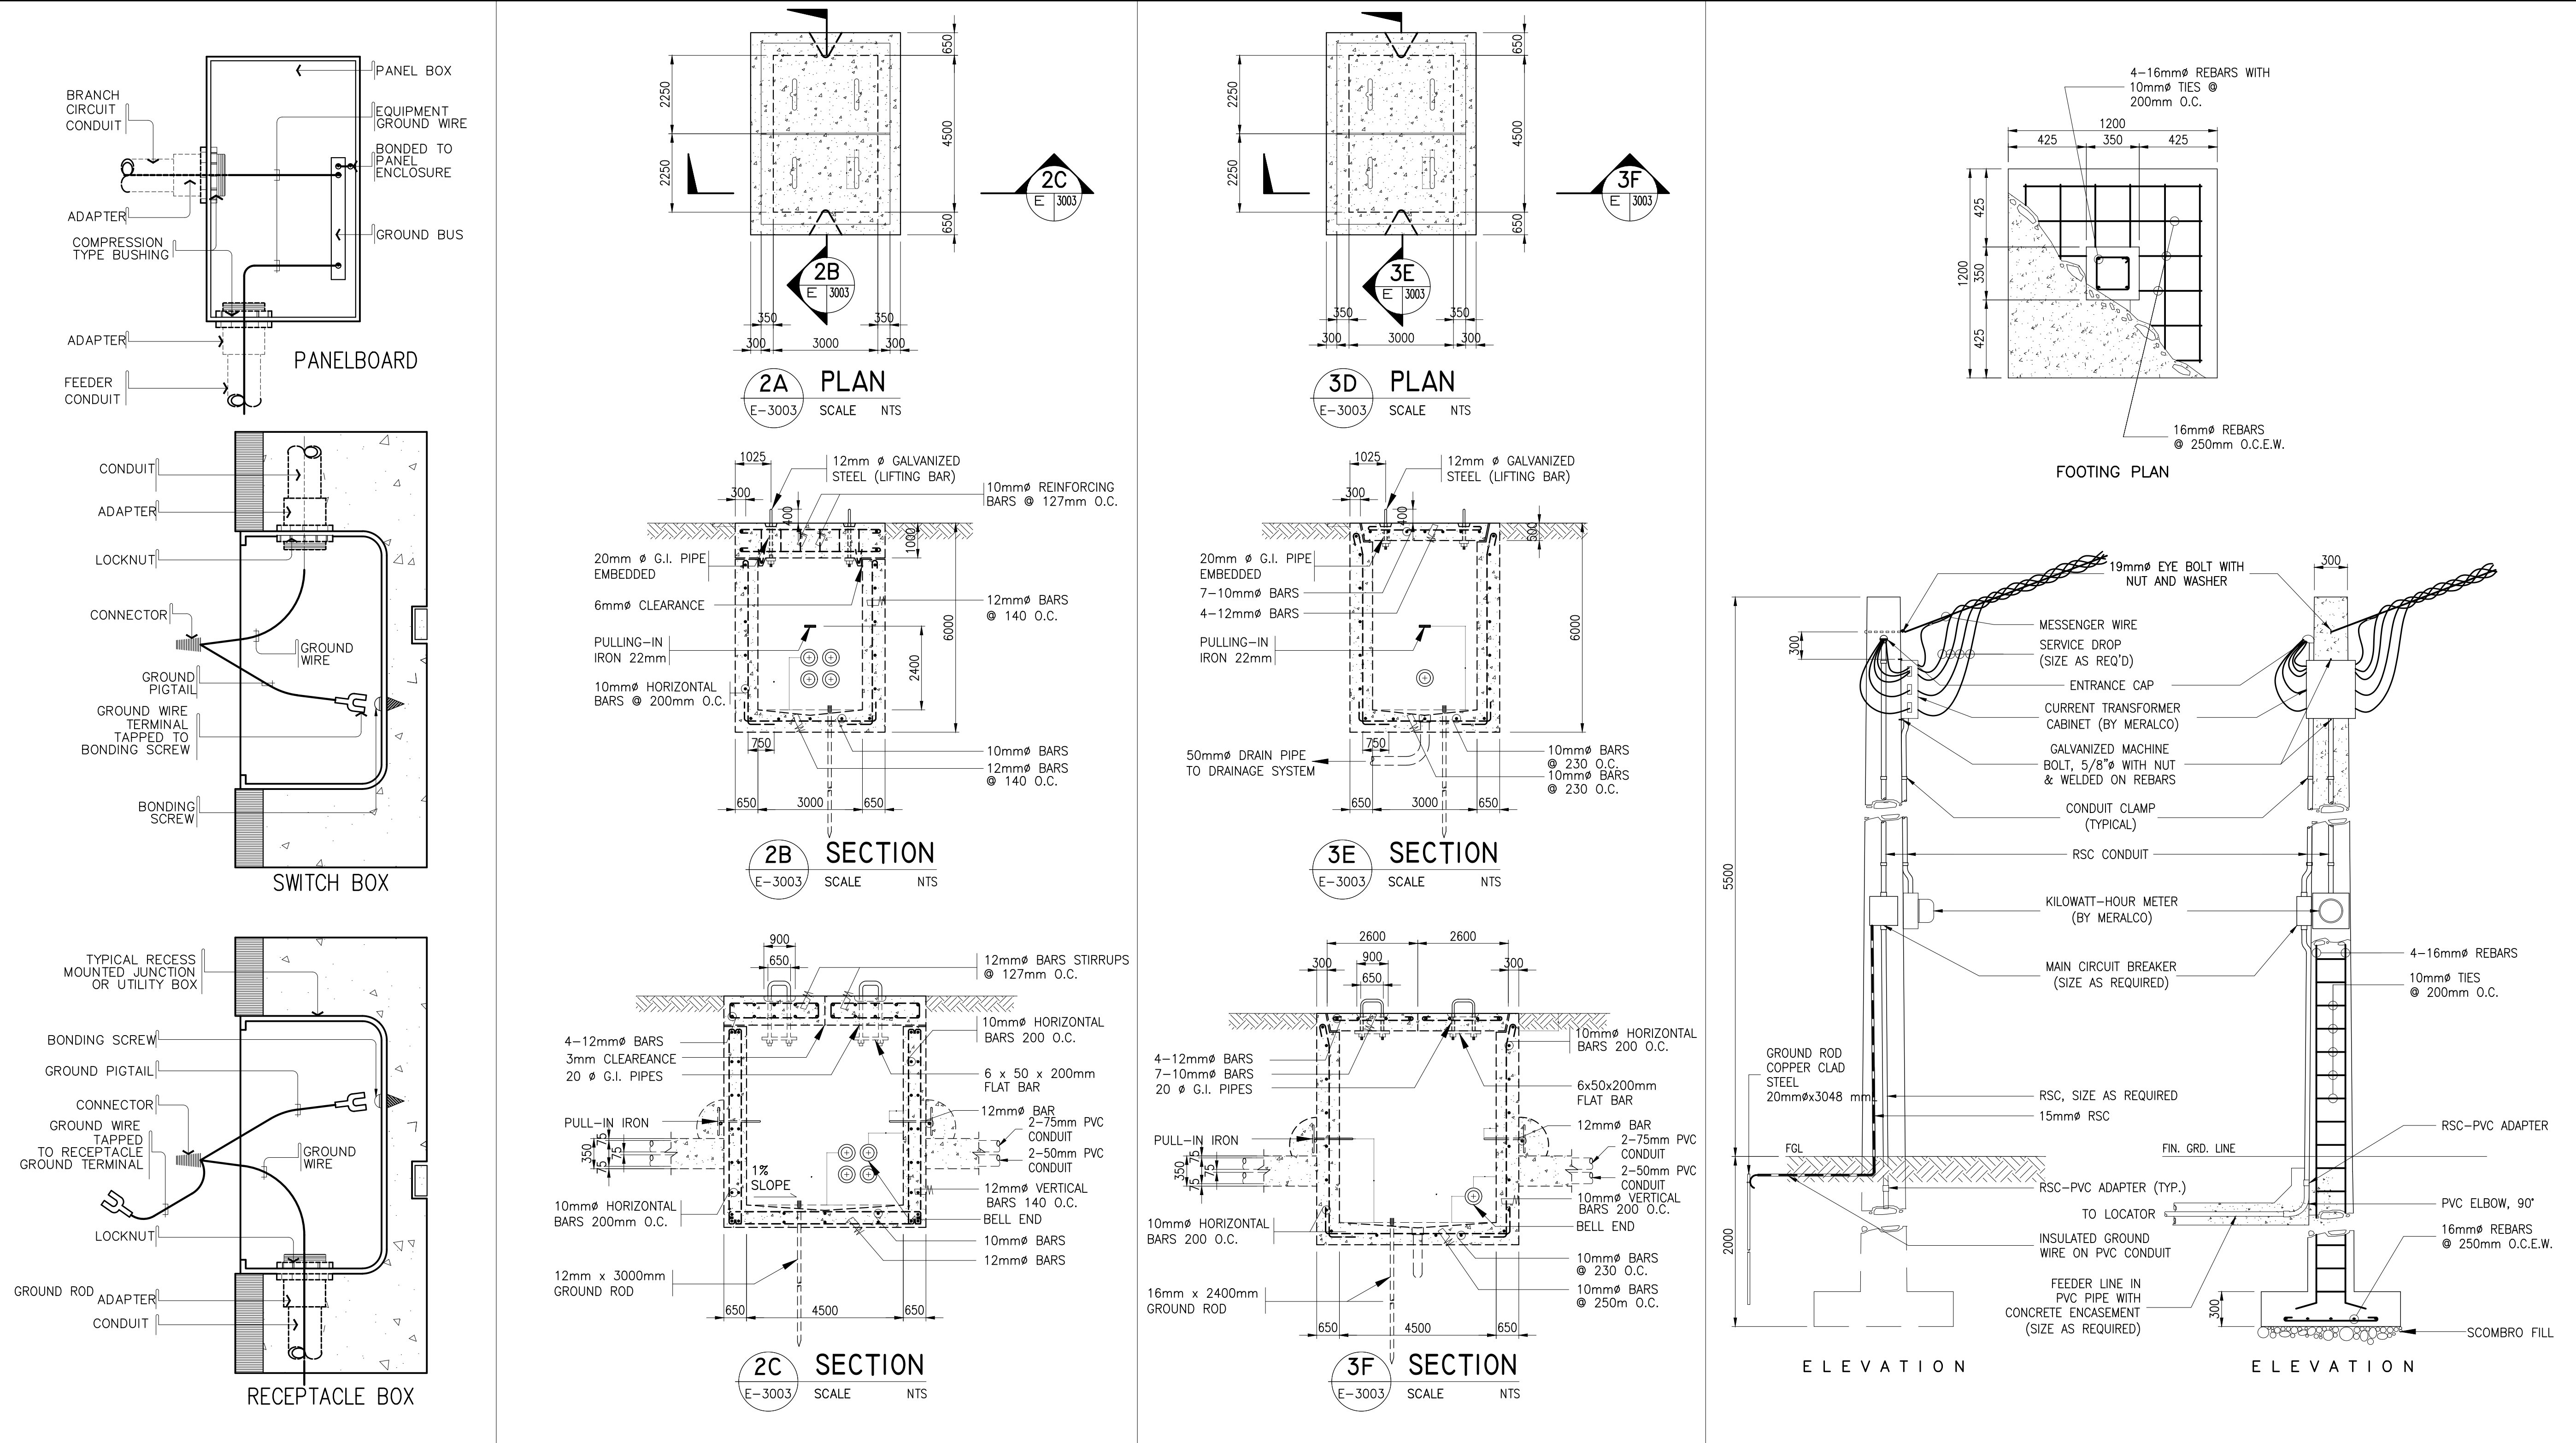

1

TYPICAL GROUNDING CONNECTION DETAIL

E-3003

SCALE

NTS

2

HANDHOLE DETAIL FOR VEHICULAR LANE

E-3003

SCALE

NTS

3

HANDHOLE DETAIL FOR NON-VEHICULAR LANE

E-3003

SCALE

NTS

4

TYPICAL 3Ø METERING/SERVICE ENTRANCE ON CONCRETE PRIVATE POLE

E-3003

SCALE

NTS

CERTIFIED BY	OWNER	PROJECT TITLE/LOCATION	CLIENT	SHEET CONTENTS	R.A. 9266 SEC. 33	CADD	DATE	NO.	REVISIONS	CHK	DATE	PAPER SIZE	SHEET NO.
RODEL JOSELITO B. MANABAT PROFESSIONAL ELECTRICAL ENGINEER	METROPOLITAN WATERWORKS AND SEWERAGE SYSTEM REGULATORY OFFICE	3-STOREY OFFICE BUILDING WITH ROOF DECK	PROJECT PROPONENT	APPROVED BY:	MISCELLANEOUS DETAILS	AVL	JUL 2018					20X30	E-3003
						DESIGNED	DATE					SCALE	PROJECT NO.
						RRVP	JUL 2018					AS SHOWN	SO-G-17-036
						APPROVED	DATE						
	MWSS COMPOUND, KATIPUNAN AVENUE, MATandang BALARA, QUEZON CITY	MWSS COMPOUND, KATIPUNAN AVENUE, MATandang BALARA, QUEZON CITY	MELCHOR S. CORDOVA ALTERNATE END-USER FOR RO BUILDING	PATRICK LESTER N. TY CHIEF REGULATOR, MWSS RO		RJBM	JUL 2018						