





I PERSPECTIVE
CS-001 SCALE NTS

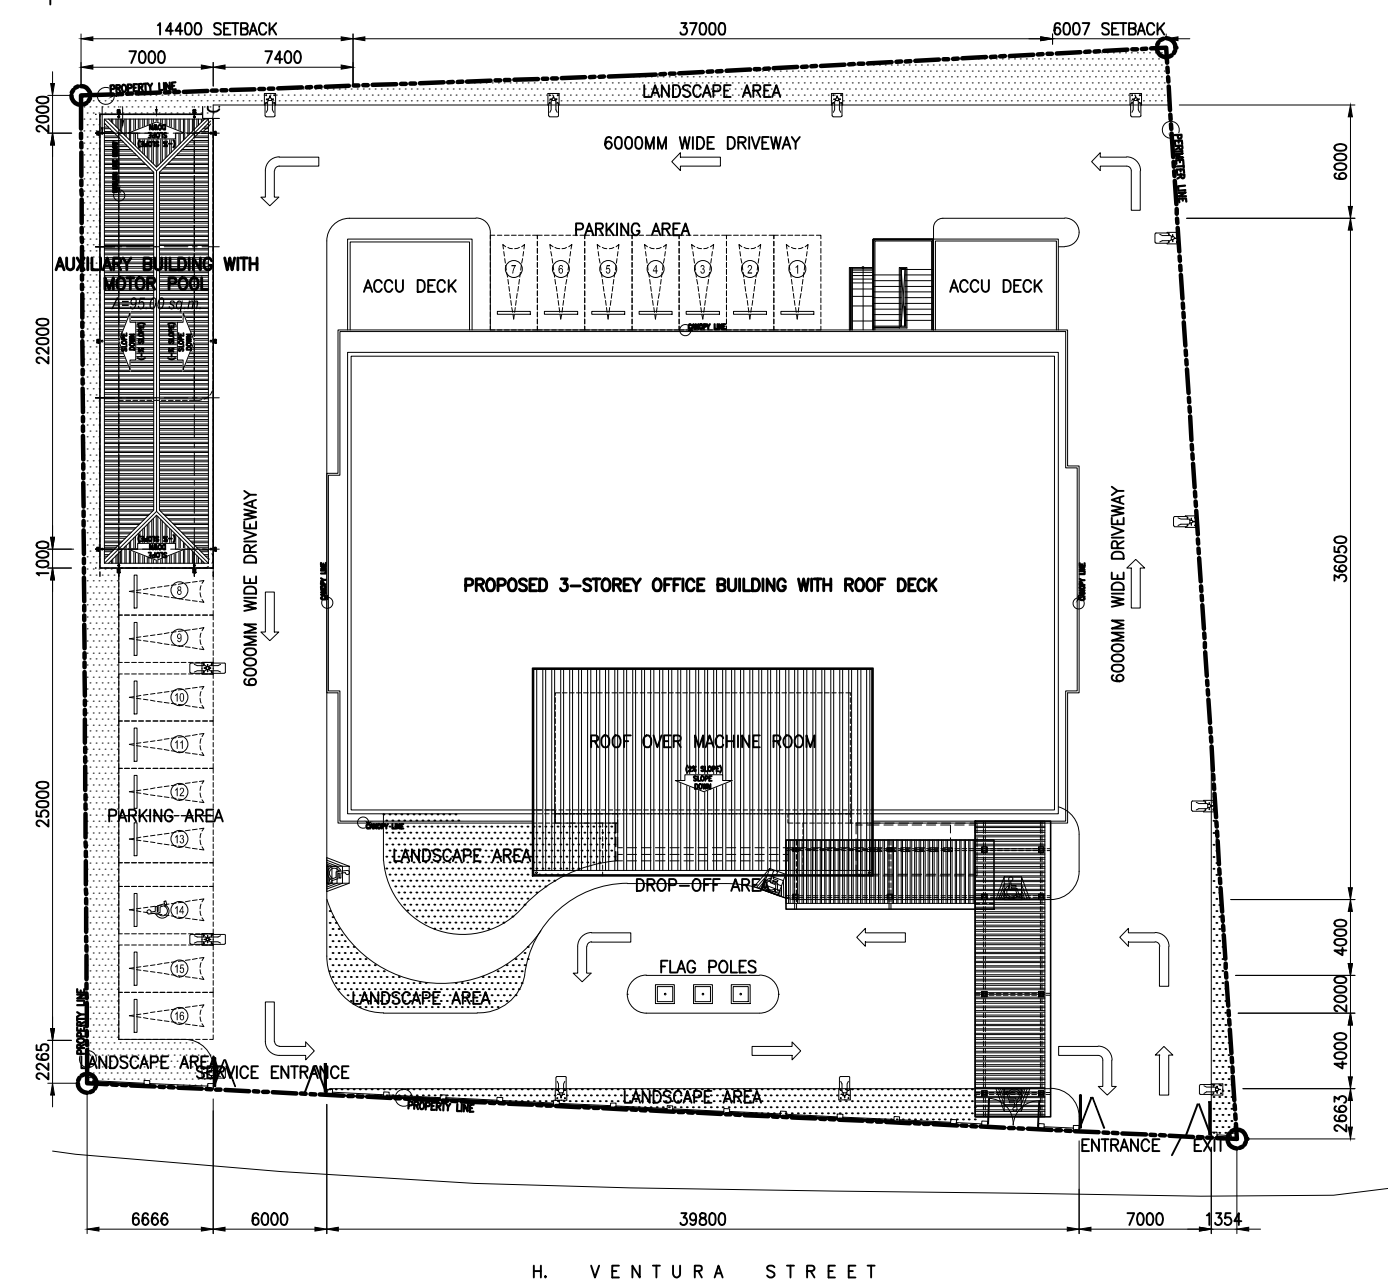

2 SITE DEVELOPMENT PLAN
CS-001 SCALE 1:400M

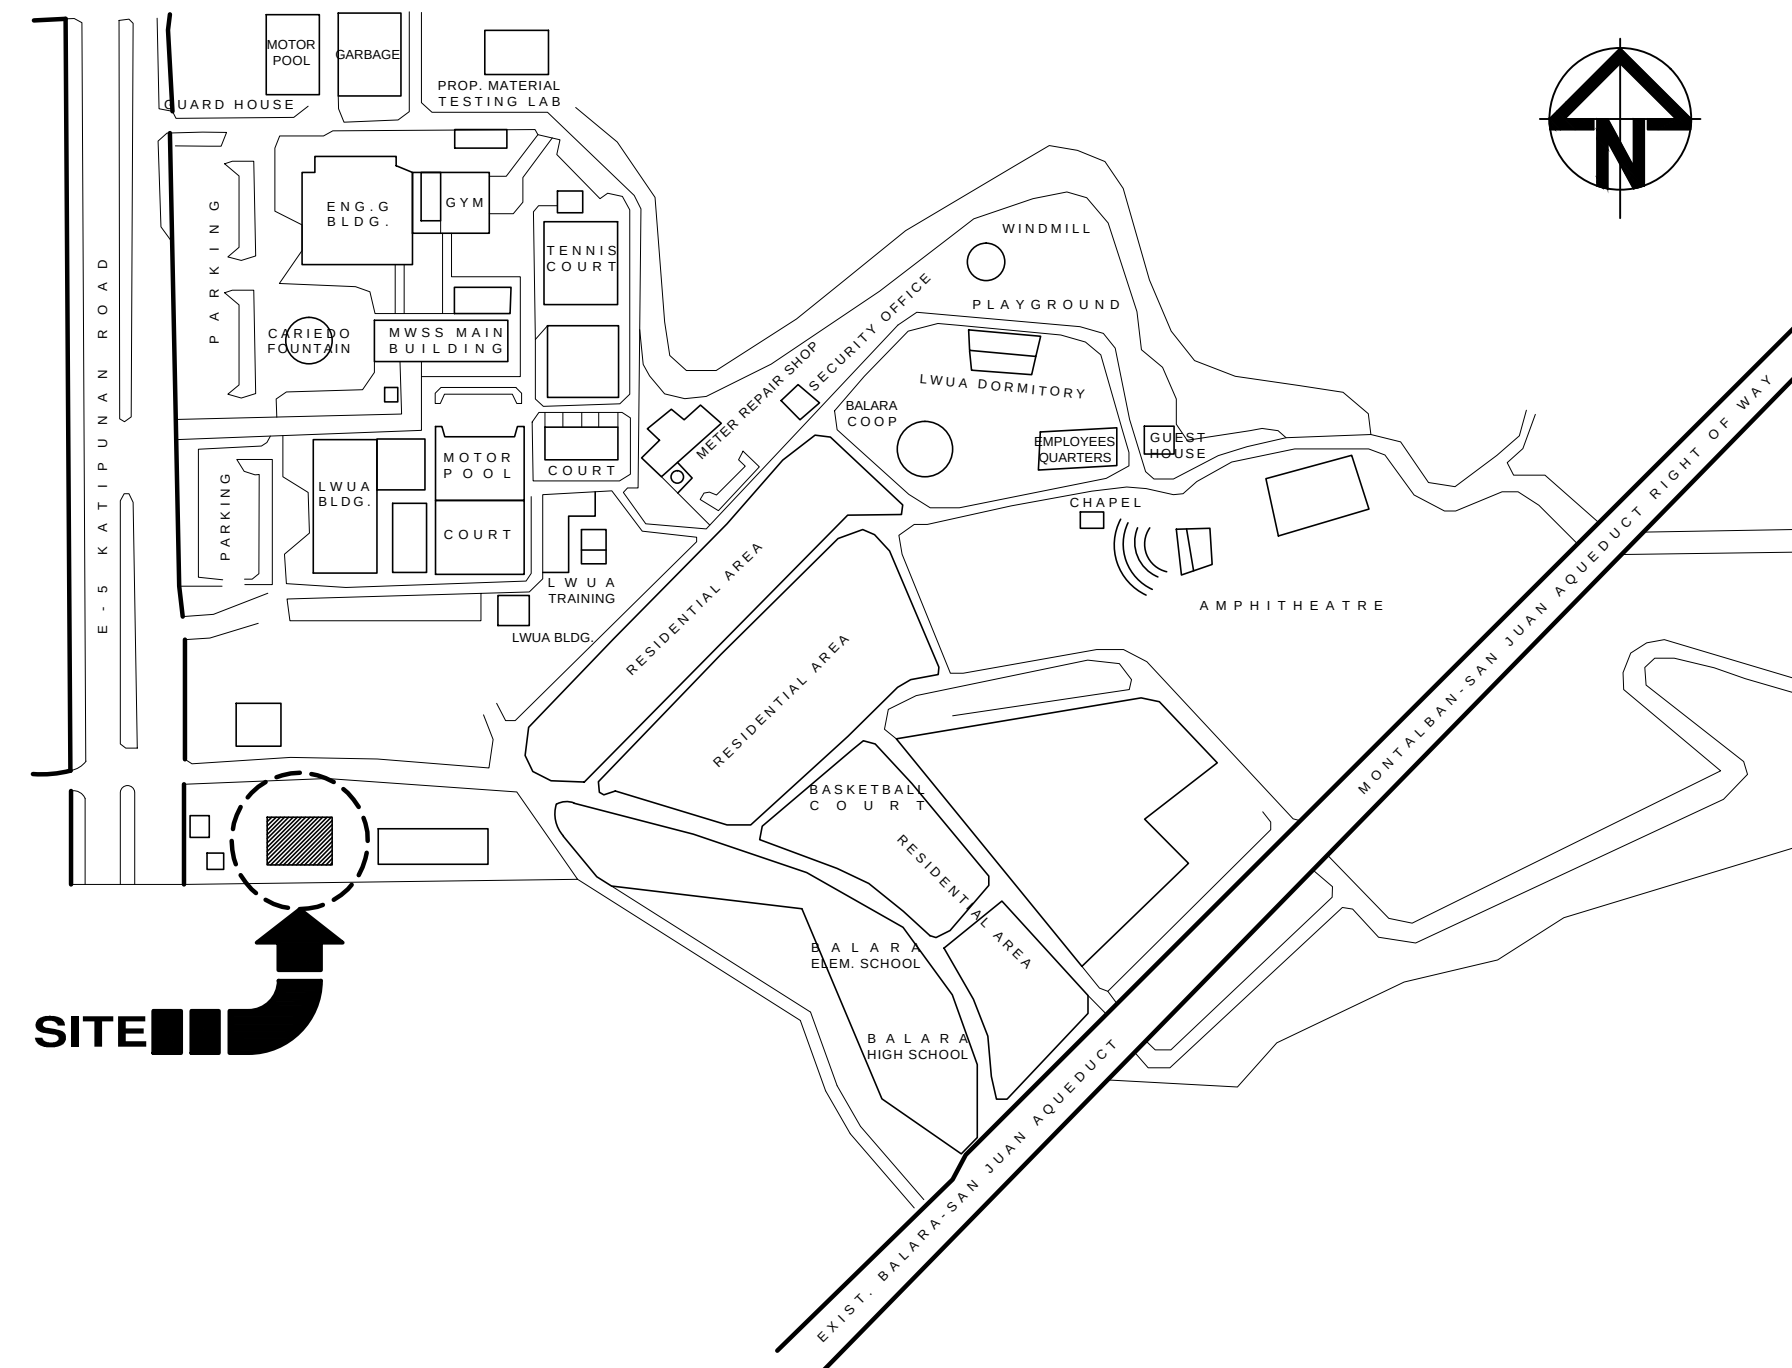

3 VICINITY MAP
CS-001 SCALE NTS

INDEX OF DRAWINGS

SHEET NO.	DRAWING TITLE
A-CS-001	GENERAL PLAN COVER SHEET
	PERSPECTIVE, SITE DEVELOPMENT PLAN, VICINITY MAP, INDEX OF DRAWINGS
	ARCHITECTURAL
A-001	SITE DEVELOPMENT PLAN
A-101	GROUND FLOOR PLAN
A-102	SECOND FLOOR PLAN
A-103	THIRD FLOOR PLAN
A-104	ROOF DECK PLAN
A-105	ROOF PLAN
A-111	GROUND FLOOR REFERENCE PLAN
A-112	SECOND FLOOR REFERENCE PLAN
A-113	THIRD FLOOR REFERENCE PLAN
A-114	ROOF DECK REFERENCE PLAN
A-121	GROUND FLOOR FINISHES PLAN
A-122	SECOND FLOOR FINISHES PLAN
A-123	THIRD FLOOR FINISHES PLAN
A-124	ROOF DECK FINISHES PLAN
A-131	GROUND FLOOR REFLECTED CEILING PLAN
A-132	SECOND FLOOR REFLECTED CEILING PLAN
A-133	THIRD FLOOR REFLECTED CEILING PLAN
A-134	ROOF DECK REFLECTED CEILING PLAN
A-141	GROUND FLOOR SETTING-OUT PLAN
A-142	SECOND FLOOR SETTING-OUT PLAN
A-143	THIRD FLOOR SETTING-OUT PLAN
A-144	ROOF DECK SETTING-OUT PLAN
A-151	GROUND FLOOR WATERPROOFING PLAN
A-152	SECOND FLOOR WATERPROOFING PLAN
A-153	THIRD FLOOR WATERPROOFING PLAN
A-154	ROOF DECK WATERPROOFING PLAN
A-201	FRONT ELEVATION REAR ELEVATION
A-202	RIGHT SIDE ELEVATION LEFT SIDE ELEVATION
A-301	LONGITUDINAL SECTION CROSS SECTION
A-401	MAIN STAIR DETAILS
A-402	MAIN STAIR DETAILS
A-403	MAIN ENTRANCE & ACCESSIBLE RAMP DETAILS
A-404	SERVICE ENTRANCE AND ELEVATOR DETAILS
A-405	FIRE EXIT STAIR-01 DETAILS
A-406	FIRE EXIT STAIR-01 DETAILS
A-407	FIRE EXIT STAIR-02 DETAILS
A-501	MALE & FEMALE PUBLIC TOILET DETAILS
A-502	FEMALE & MALE EMPLOYEE'S TOILET-1 DETAILS
A-503	FEMALE & MALE EMPLOYEE'S TOILET-2 DETAILS
A-504	PUBLIC PWD & PWD TOILET-1 DETAILS
A-505	TOILET AND BATH 1, 2, & 3 DETAILS
A-506	TOILET TYPICAL DETAILS
A-511	PANTRY 1 & 2 DETAILS
A-512	PANTRY 3 & 4 DETAILS
A-513	PANTRY 5 & 6 DETAILS
A-514	PANTRY 7 DETAILS
A-601	SCHEDULE OF DOORS
A-602	SCHEDULE OF WINDOWS
A-701	AUXILIARY BLDG. DETAILS
A-702	PERIMETER FENCE & GATE DETAILS
A-703	COVERED WALKWAY
A-704	GLASS CANOPY DETAILS
A-705	EXTERIOR SIGNAGE DETAILS & FLAGPOLE DETAILS
	ARCHITECTURAL INTERIOR
AI-101	GROUND FLOOR MILLWORKS REFERENCE PLAN
AI-102	SECOND FLOOR MILLWORKS REFERENCE PLAN
AI-103	THIRD FLOOR MILLWORKS REFERENCE PLAN
AI-104	MW-01 DETAILS (RECEPTION DESK)
	MW-02 DETAILS (TRANSACTION WINDOW)
AI-105	MW-03 DETAILS (FULL HEIGHT CABINET) MW-04 DETAILS (FULL HEIGHT CABINET) SPOT DETAIL - 01 SPOT DETAIL - 02
AI-106	MW-05 DETAILS (TYP. FULL HEIGHT CABINET) MW-06 DETAILS (TYP. FULL HEIGHT SHELVES)
AI-107	MW-07 DETAILS (TYP. BASE & OVERHEAD UTILITY CABINET) MW-08 DETAILS (TYP. PANTRY BASE & OVERHEAD CABINET)
AI-108	MW-09 DETAILS (TYP. PANTRY BASE & OVERHEAD CABINET) MW-10 DETAILS (PANTRY BASE & OVERHEAD CABINET)
AI-201	GROUND FLOOR FURNITURE LAYOUT & SCHEDULE
AI-202	SECOND FLOOR FURNITURE LAYOUT & SCHEDULE
AI-203	THIRD FLOOR FURNITURE LAYOUT & SCHEDULE
AI-204	SCHEDULE OF FURNITURES
AI-301	GROUND FLOOR FINISHING SCHEDULE
AI-302	SECOND FLOOR FINISHING SCHEDULE
AI-303	THIRD FLOOR FINISHING SCHEDULE
AI-304	ROOF DECK FINISHING SCHEDULE
AI-401	MAIN LOBBY DETAILS
AI-402	MAIN LOBBY DETAILS
AI-403	TYPICAL 2ND & 3RD FLOOR LOBBY DETAILS
AI-404	TYPICAL 2ND & 3RD FLOOR LOBBY DETAILS
AI-405	CONFERENCE ROOM DETAILS
AI-406	CONFERENCE ROOM DETAILS
AI-407	MEETING ROOM DETAILS
AI-408	MESS HALL DETAILS
AI-409	MESS HALL DETAILS
AI-410	FITNESS GYM DETAILS
AI-411	OFFICE OF THE CHIEF REGULATOR
AI-412	OFFICE OF THE CHIEF REGULATOR
AI-413	ADMINISTRATION & LEGAL AFFAIRS OFFICE
AI-414	ADMINISTRATION & LEGAL AFFAIRS OFFICE
AI-415	ADMINISTRATION & LEGAL AFFAIRS OFFICE
AI-416	ADMINISTRATION & LEGAL AFFAIRS OFFICE
AI-417	ADMINISTRATION & LEGAL AFFAIRS OFFICE
L-101	LANDSCAPE GRADING & DRAINAGE PLAN
L-102	LIGHTING PLAN
L-103	MATERIAL PLAN
L-104	SOFTSCAPE PLAN
L-105	FRONT GARDEN DETAILS
L-111	SITE SECTIONS

DEPARTMENT OF PUBLIC WORKS
AND HIGHWAYS

OFFICE OF THE BUILDING OFFICIAL

DISTRICT/CITY/MUNICIPALITY

LAND USE & ZONING

LINE & GRADE

ARCHITECTURAL


STRUCTURAL

SANITARY

FIRE PROTECTION


ELECTRICAL

MECHANICAL

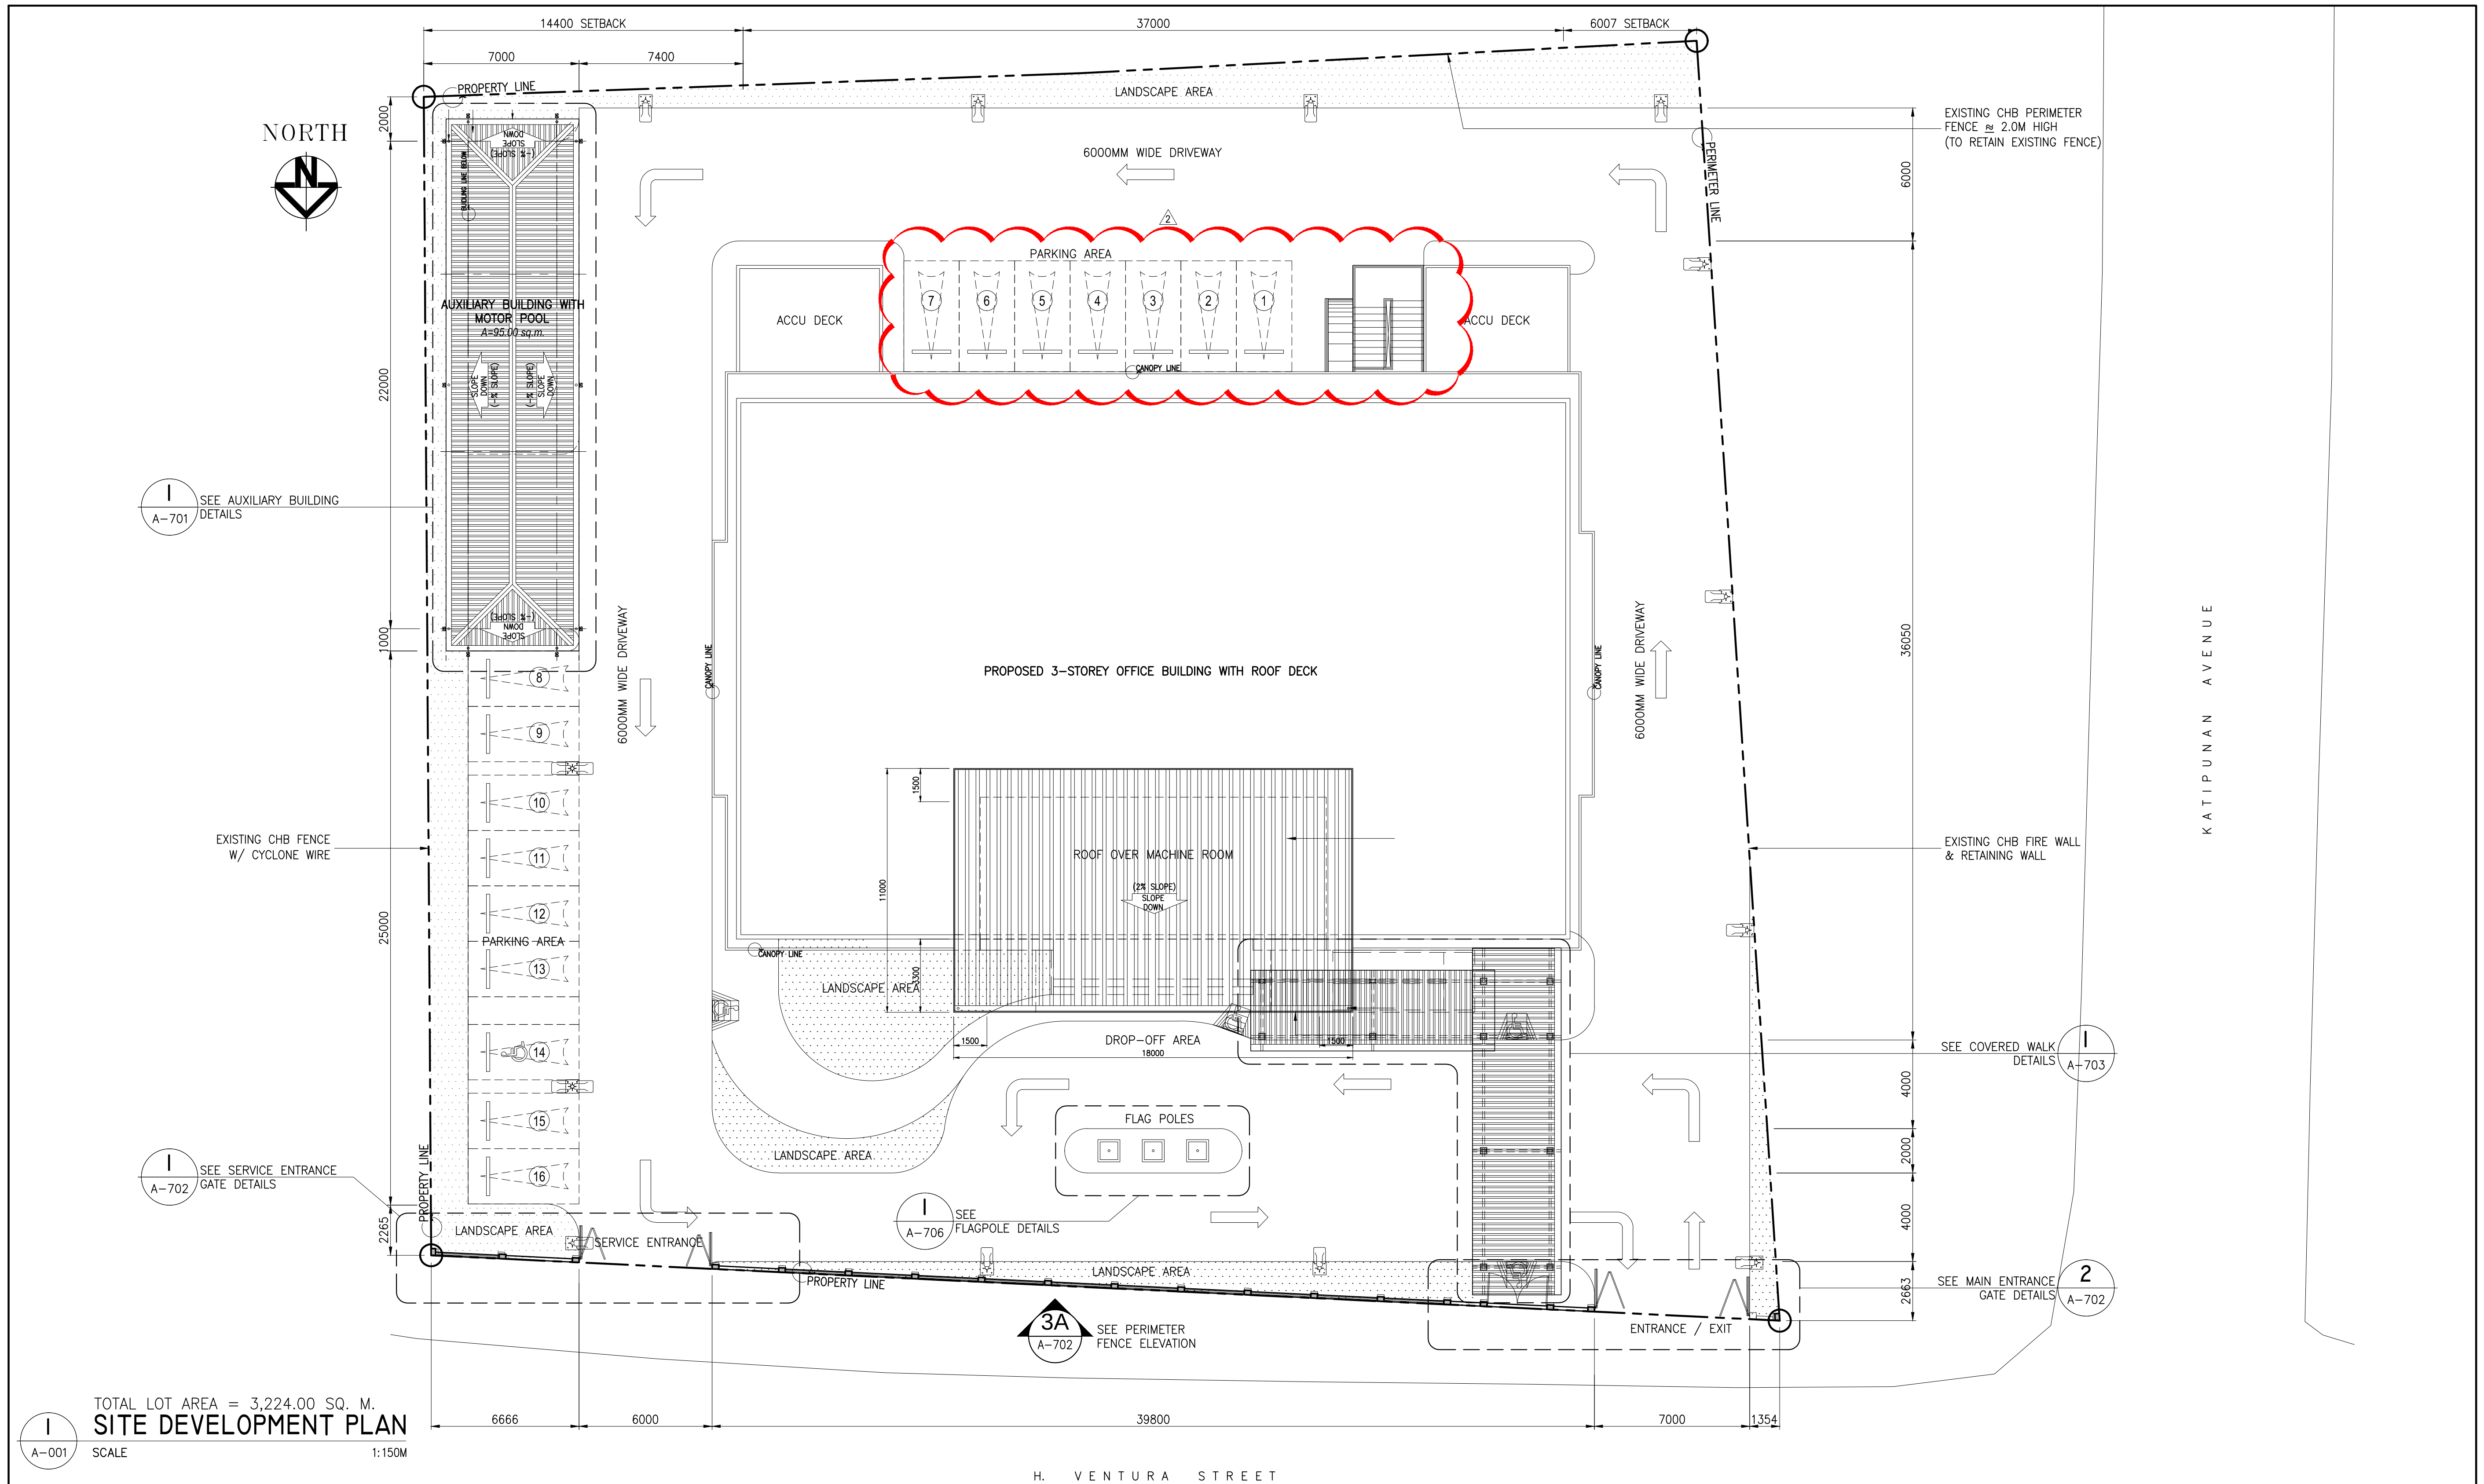


CERTIFIED BY		OWNER	PROJECT TITLE/LOCATION	CLIENT	SHEET CONTENTS	R.A. 9266 SEC. 33 DRAWINGS AND SPECIFICATIONS AND CONTRACT DOCUMENTS DULY SIGNED, STAMPED OR SEALED AS INSTRUMENTS FOR SERVICE ARE THE INTELLECTUAL PROPERTY AND DOCUMENTS OF ARCHITECT, WHETHER THE OBJECT FOR WHICH THEY ARE MADE IS EXECUTED OR NOT. IT SHALL BE UNLAWFUL FOR ANY PERSON TO DUPLICATE OR TO MAKE COPIES OF SAID DOCUMENTS FOR USE IN THE REPETITION OF AND FOR OTHER PROJECTS OR BUILDINGS, WHETHER EXECUTED PARTLY OR IN WHOLE, WITHOUT THE WRITTEN CONSENT OF THE ARCHITECT OR AUTHOR OF SAID DOCUMENTS.	CADD	DATE	NO.	REVISIONS	CHK	DATE	PAPER SIZE	SHEET NO.
MICHELANGELA O. SALVADOR, UAP		METROPOLITAN WATERWORKS AND SEWERAGE SYSTEM REGULATORY OFFICE	3-STOREY OFFICE BUILDING WITH ROOF DECK	PROJECT PROPONENT	APPROVED BY:	GMTI/NBR/SCCH DESIGNED JDEC APPROVED MOS	GMTI/NBR/SCCH	JUL 2018					20X30	A-001
ARCHITECT				MELCHOR S. CORDOVA ALTERNATE END-USER FOR RO BUILDING	PATRICK LESTER N. TY CHIEF REGULATOR, MWSS RO		DESIGNED	DATE					SCALE	PROJECT NO.
							JDEC	JUL 2018						
							APPROVED	DATE	1	ADDITIONAL FIRE EXIT STAIRS AND REDUCE PARKING SLOTS	10-30-2018		AS SHOWN	SO-G-17-036
							MOS	JUL 2018		SCHEMATIC DESIGN	03-09-2018			



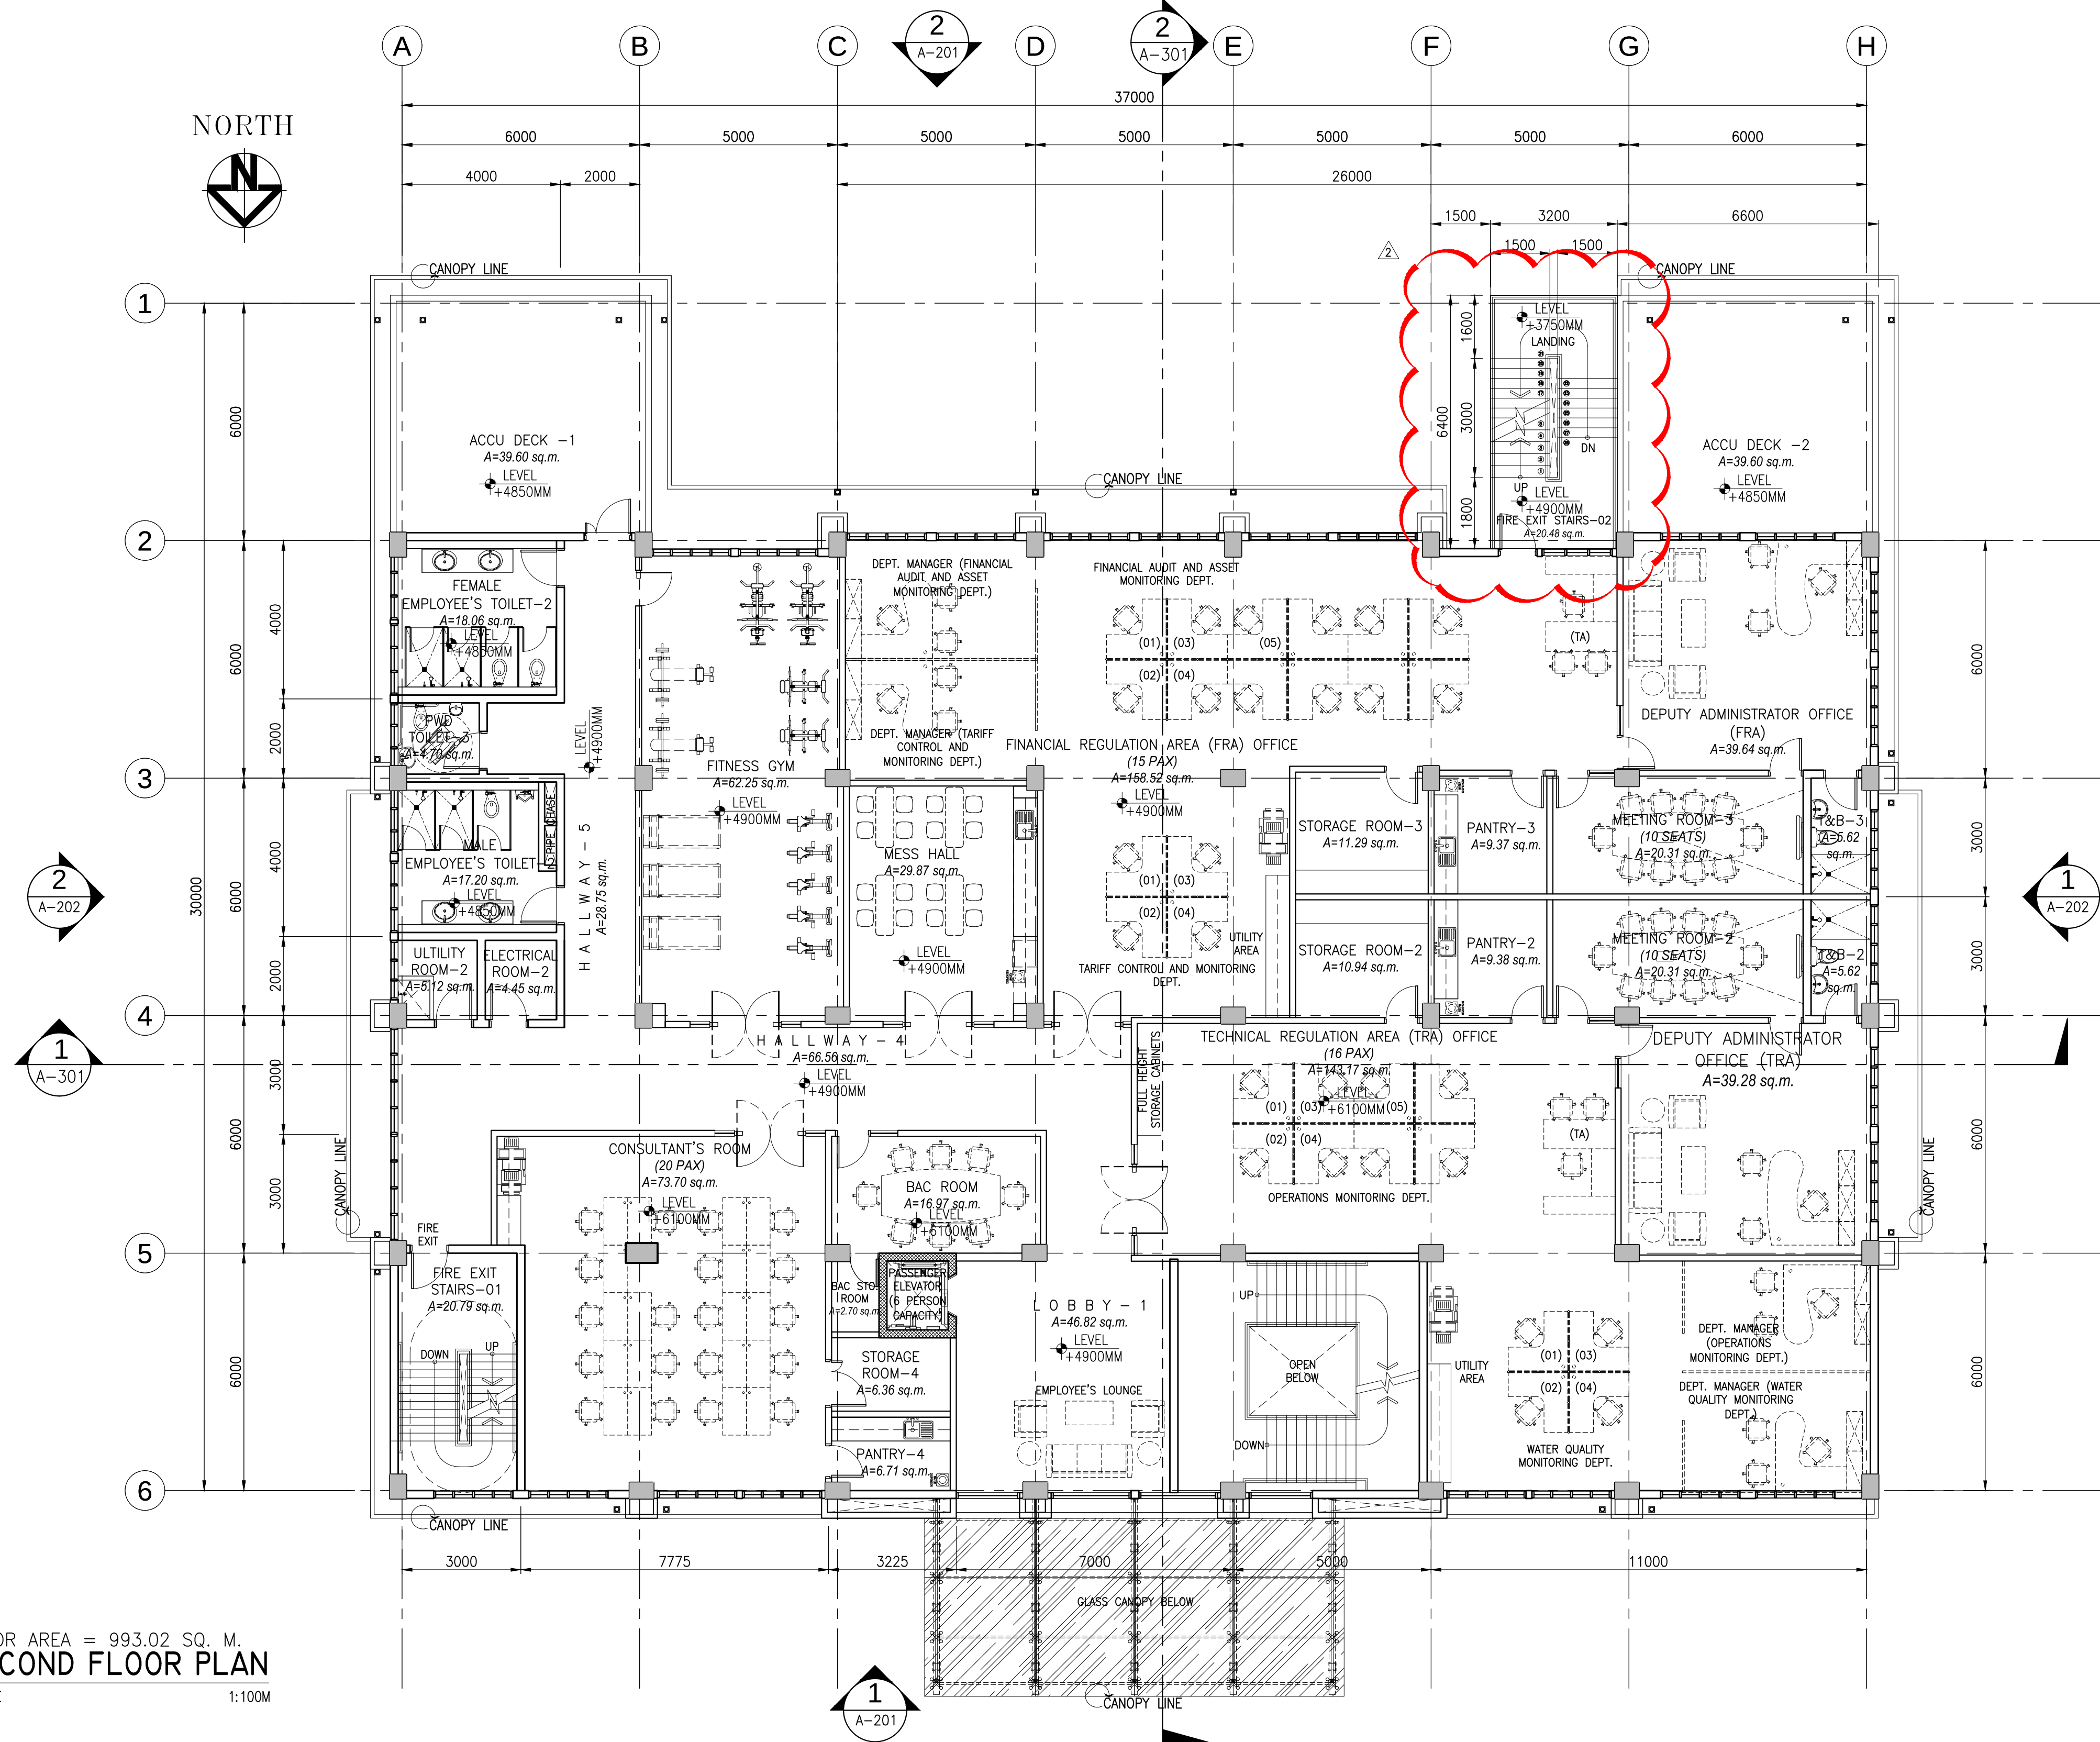



CERTIFIED BY	REG. NO.: 0021601	OWNER	PROJECT TITLE/LOCATION	CLIENT	SHEET CONTENTS	R.A. 9266 SEC. 33	CADD	DATE	NO.	REVISIONS	CHK	DATE	PAPER SIZE	SHEET NO.
MICHELANGELA O. SALVADOR, UAP	IAPOA : 17156228123072318	METROPOLITAN WATERWORKS AND SEWERAGE SYSTEM REGULATORY OFFICE	3-STOREY OFFICE BUILDING WITH ROOF DECK	PROJECT PROPONENT	SECOND FLOOR PLAN	DRAWINGS AND SPECIFICATIONS AND CONTRACT DOCUMENTS DULY SIGNED, STAMPED OR SEALED AS INSTRUMENTS FOR SERVICE ARE THE INTELLECTUAL PROPERTY AND DOCUMENTS OF ARCHITECT, WHETHER THE OBJECT FOR WHICH THEY ARE MADE IS EXECUTED OR NOT. IT SHALL BE UNLAWFUL FOR ANY PERSON TO DUPLICATE OR TO MAKE COPIES OF SAID DOCUMENTS FOR USE IN THE REPETITION OF AND FOR OTHER PROJECTS OR BUILDINGS, WHETHER EXECUTED PARTLY OR IN WHOLE, WITHOUT THE WRITTEN CONSENT OF THE ARCHITECT OR AUTHOR OF SAID DOCUMENTS.	GMT/NBR/SC/	JUL 2018					20X30	A-102
ARCHITECT	TIN NO. : 271-680-669-000	MWSS COMPOUND, KATIPUNAN AVENUE, MATANDANG BALARA, QUEZON CITY	MWSS COMPOUND, KATIPUNAN AVENUE, MATANDANG BALARA, QUEZON CITY	MELCHOR S. CORDOVA	ALTERNATE END-USER FOR RO BUILDING	PATRICK LESTER N. TY	DESIGNED	DATE					SCALE	PROJECT NO.
	PTR NO. : 6679972						JDEC	JUL 2018					AS SHOWN	SO-G-17-036
	DATE : 2/8/2018						APPROVED	DATE		ADDITIONAL FIRE EXIT STAIRS		10-30-2018		
	PLACE : MAKATI CITY						MOS	JUL 2018	1	SCHEMATIC DESIGN		03-09-2018		

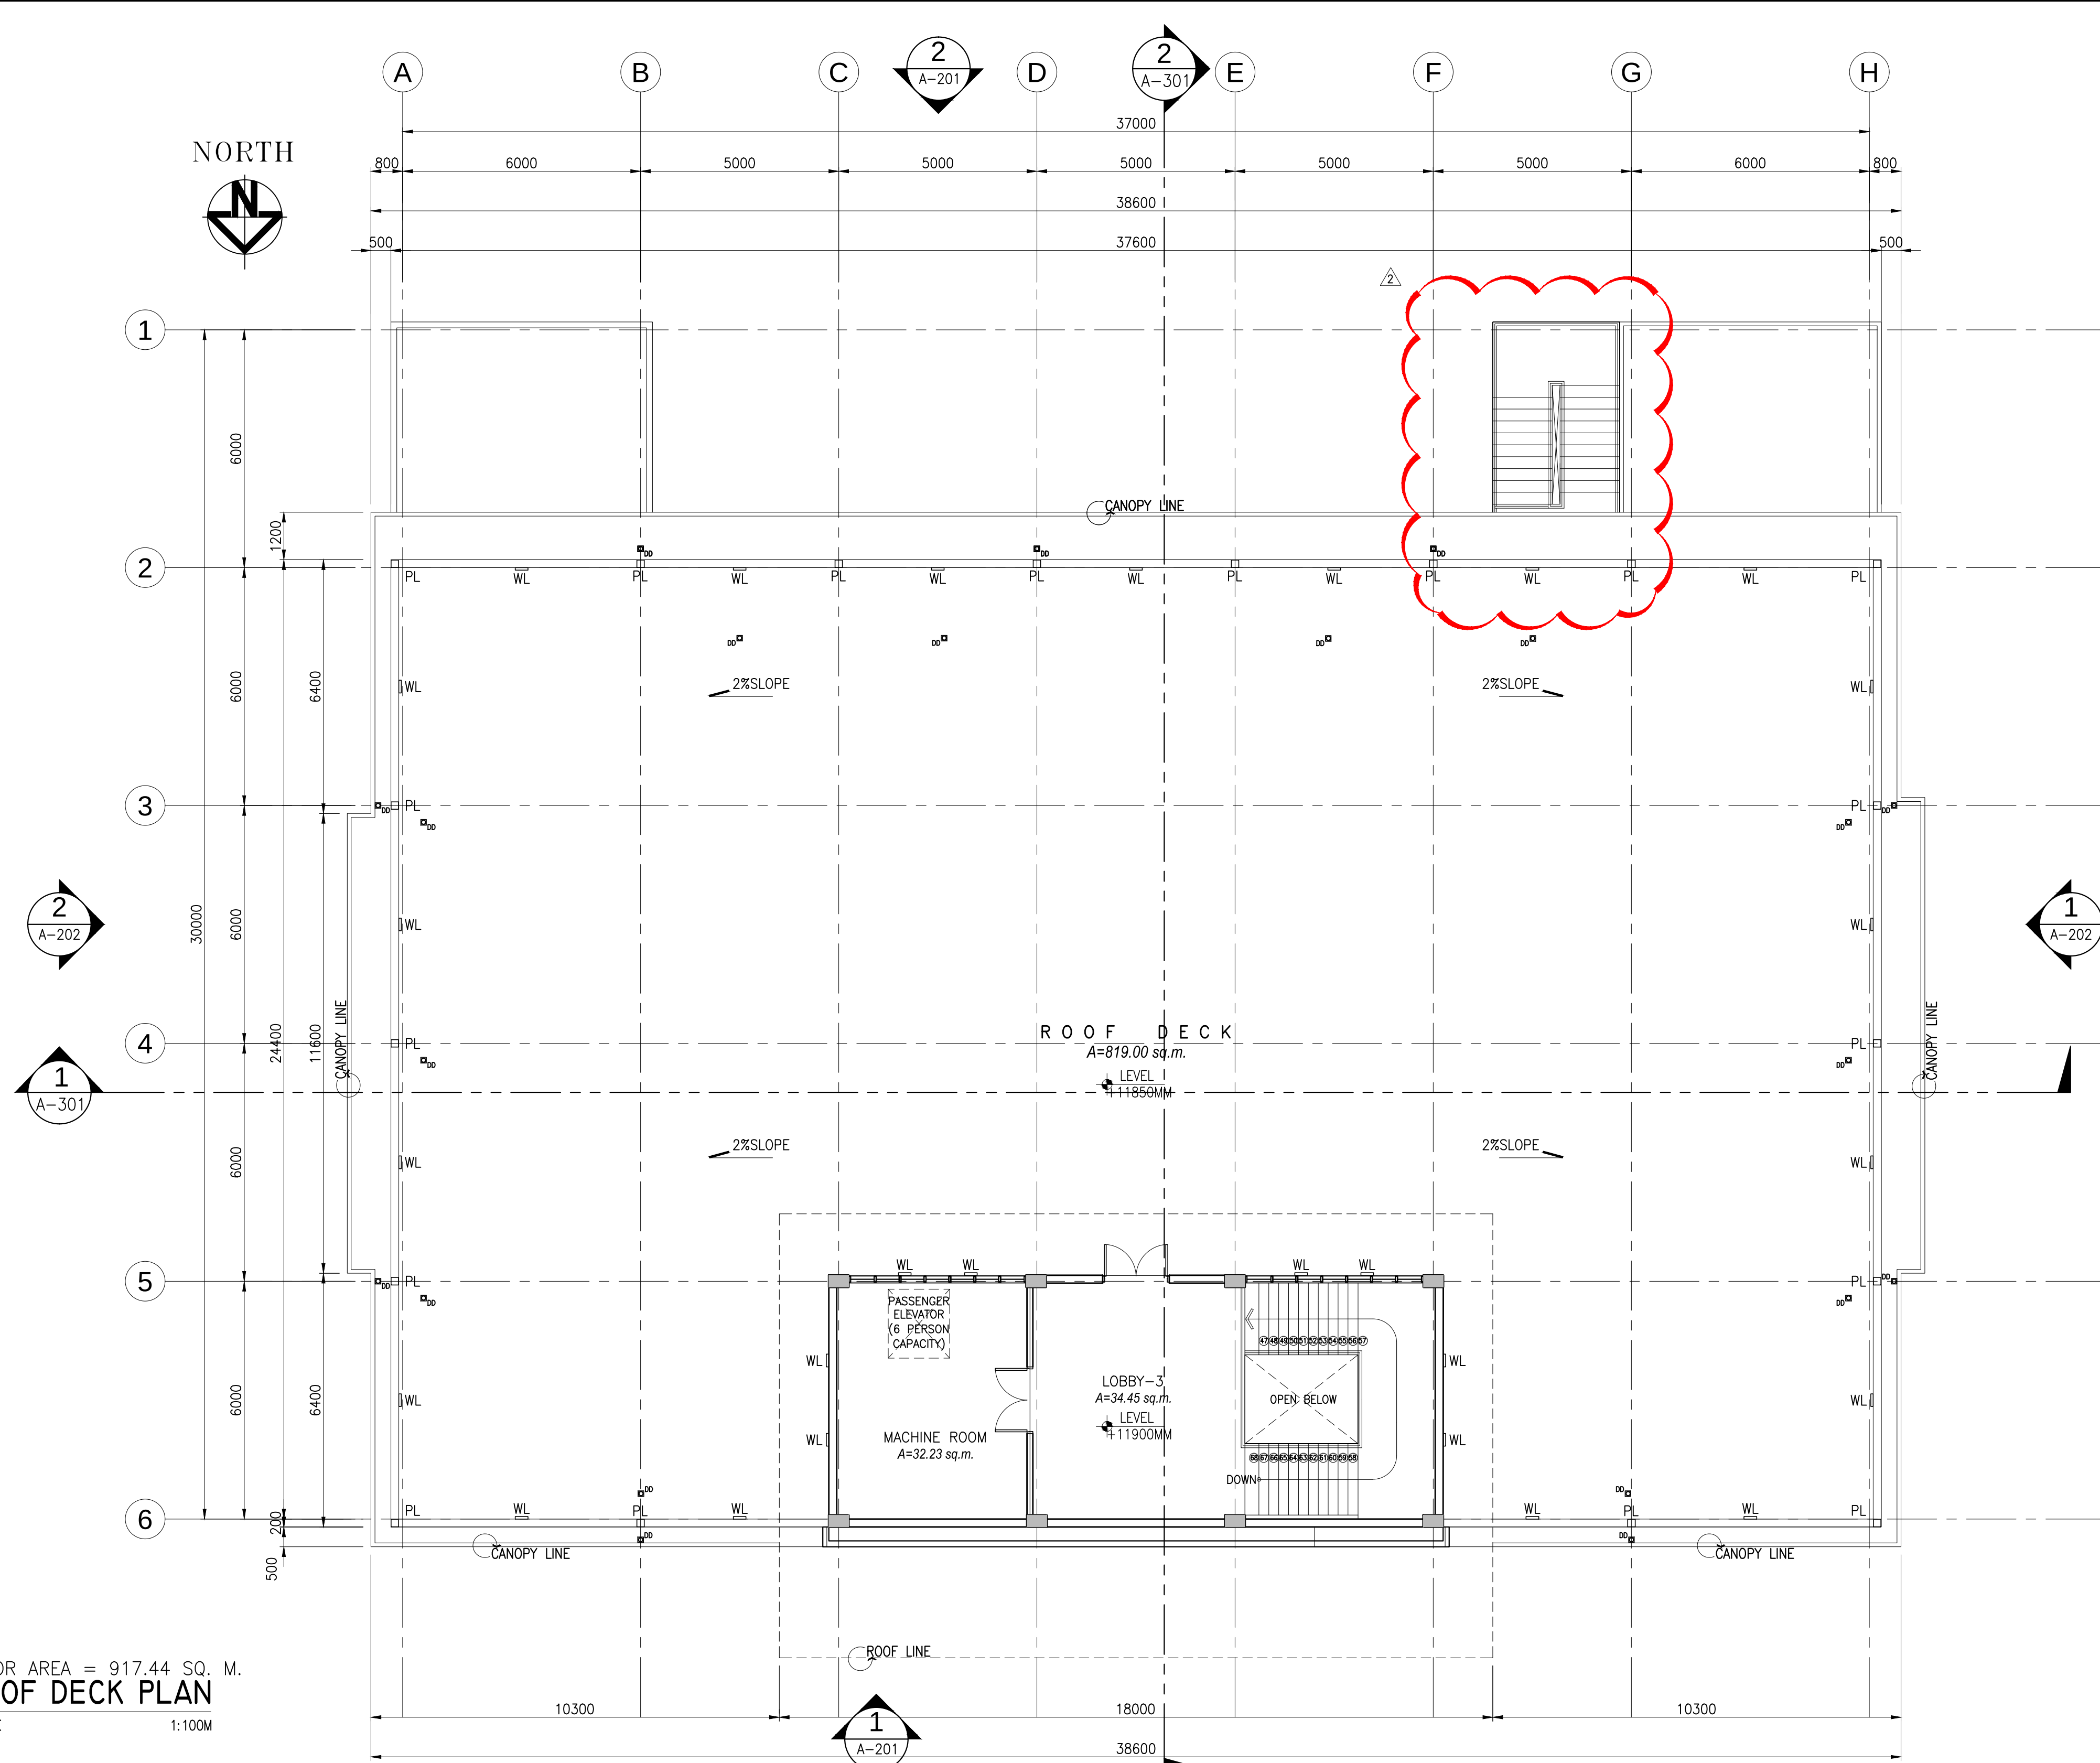

LEGEND	
LIGHTING FIXTURES	
	1X9W LED 160MM X 160MM X 31MM THICK WALL LUMINAIRE
	1X9W LED 140MM X 140MM X 350MM HIGH POST LUMINAIRE


CERTIFIED BY		OWNER	PROJECT TITLE/LOCATION	CLIENT		SHEET CONTENTS	R.A. 9266 SEC. 33	CADD	DATE	NO.	REVISIONS	CHK	DATE	PAPER SIZE	SHEET NO.			
MICHELANGELO A. SALVADOR, UAP ARCHITECT	REG. NO.: 0021601	METROPOLITAN WATERWORKS AND SEWERAGE SYSTEM REGULATORY OFFICE	3-STOREY OFFICE BUILDING WITH ROOF DECK	PROJECT PROPONENT	APPROVED BY:	ROOF DECK PLAN	DRAWINGS AND SPECIFICATIONS AND CONTRACT DOCUMENTS DULY SIGNED, STAMPED OR SEALED AS INSTRUMENTS FOR SERVICE, ARE THE INTELLECTUAL PROPERTY AND DOCUMENTS OF ARCHITECT, WHETHER THE OBJECT FOR WHICH THEY ARE MADE IS EXECUTED OR NOT, IT SHALL BE UNLAWFUL FOR ANY PERSON TO DUPLICATE OR TO MAKE COPIES OF SAID DOCUMENTS FOR USE IN THE REPERITION OF AND FOR OTHER PROJECTS OR BUILDINGS, WHETHER EXECUTED PARTLY OR IN WHOLE, WITHOUT THE WRITTEN CONSENT OF THE ARCHITECT OR AUTHOR OF SAID DOCUMENTS.	GMT/NBR/SCHE	JUL 2018					20X30	A-104			
	IAPOA : 17156228123072318																	
	TIN NO. : 271-680-669-000																SCALE	PROJECT NO.
	PTR NO. : 6679972																	
	DATE : 2/8/2018	MWSS COMPOUND, KATIPUNAN AVENUE, MATANGANG BALARA, QUEZON CITY	MWSS COMPOUND, KATIPUNAN AVENUE, MATANGANG BALARA, QUEZON CITY	<u>MELCHOR S. CORDOVA</u>	<u>PATRICK LESTER N. TY</u>			APPROVED	DATE		ADDITIONAL FIRE EXIT STAIRS		10-30-2018	AS SHOWN	SO-G-17-036			
	PLACE : MAKATI CITY			ALTERNATE END-USER FOR RO BUILDING	CHIEF REGULATOR, MWSS RO			MOS	JUL 2018	1	SCHEMATIC DESIGN		03-09-2018					

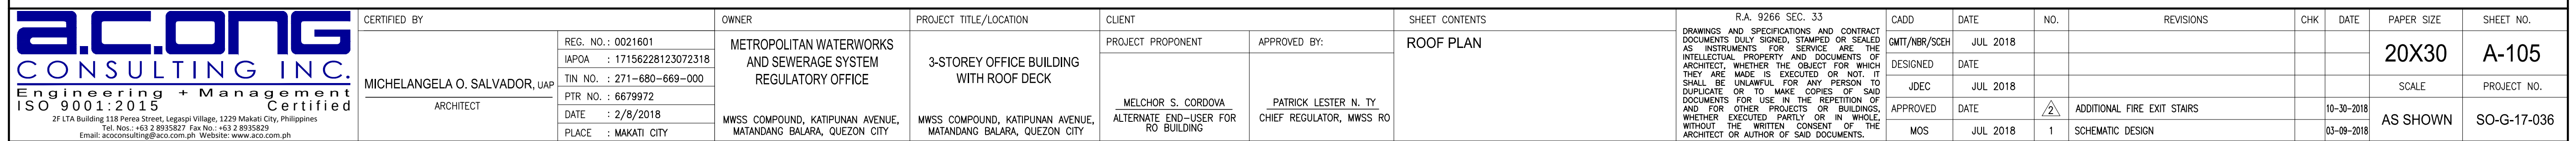

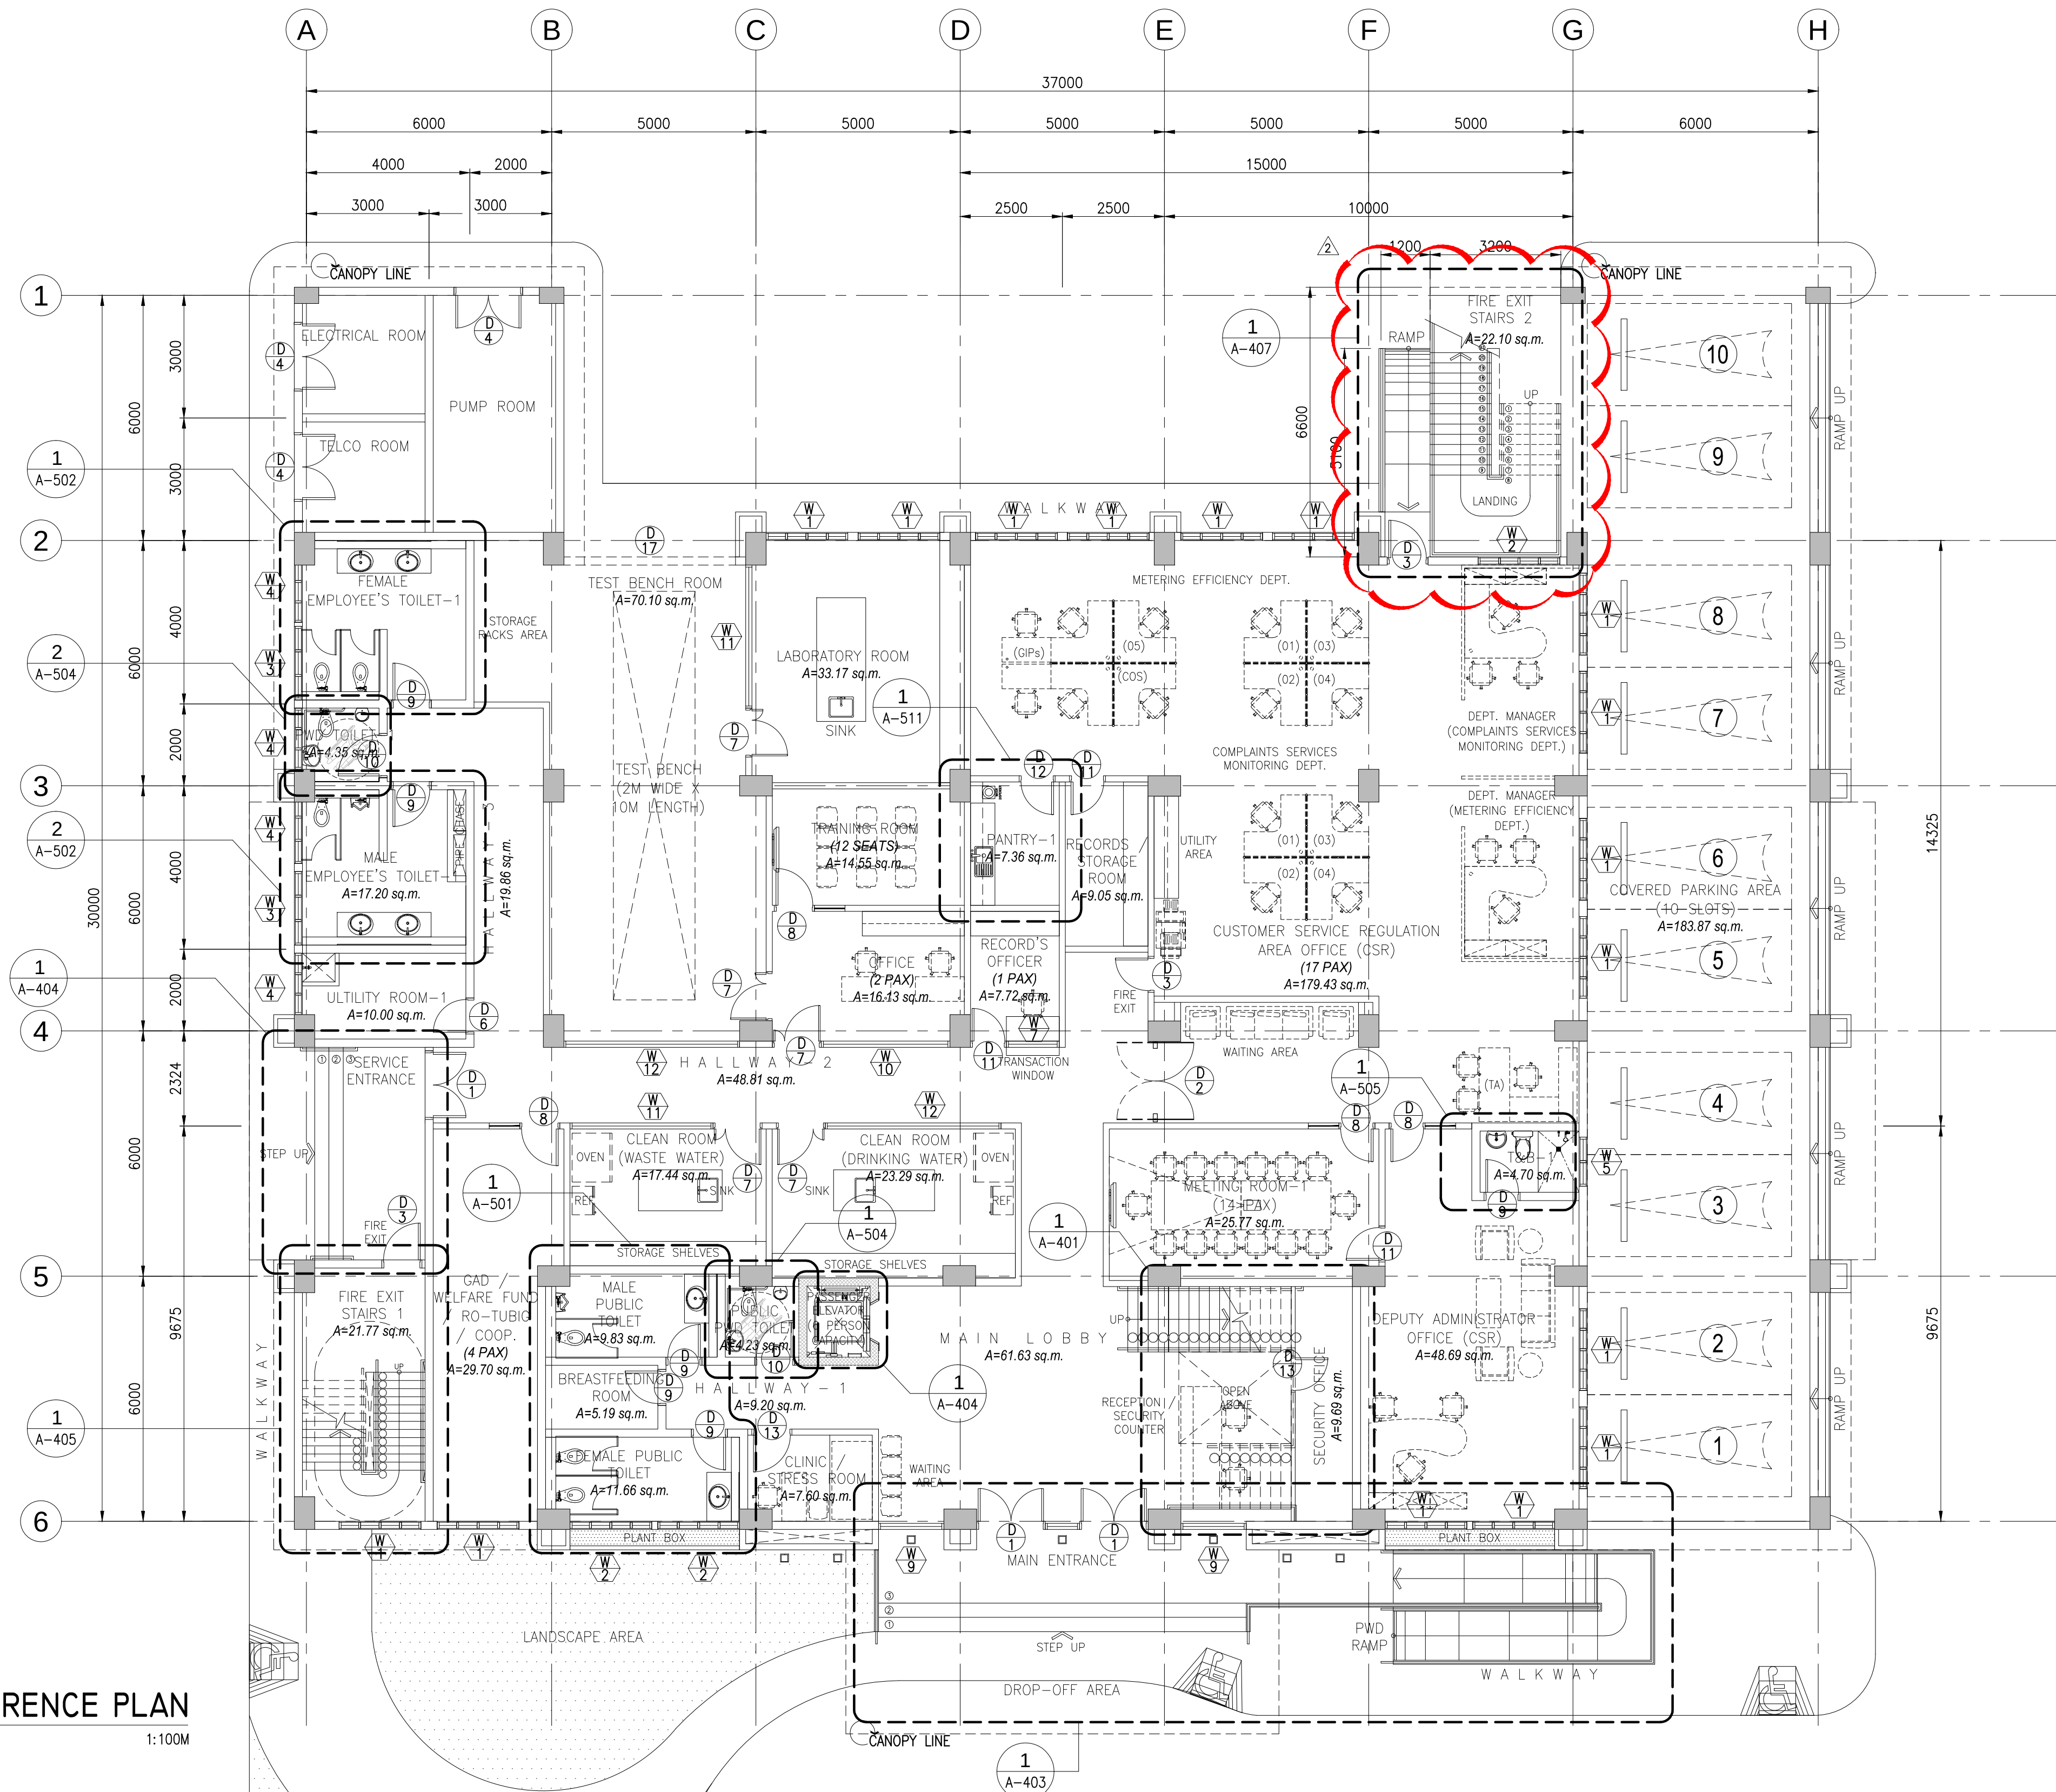


I GROUND FLOOR REFERENCE PLAN
A-111 SCALE 1:100M

CERTIFIED BY		OWNER	PROJECT TITLE/LOCATION	CLIENT		SHEET CONTENTS	R.A. 9266 SEC. 33	CADD	DATE	NO.	REVISIONS	CHK	DATE	PAPER SIZE	SHEET NO.
MICHELANGELO A. SALVADOR, UAP ARCHITECT	REG. NO.: 0021601	METROPOLITAN WATERWORKS AND SEWERAGE SYSTEM REGULATORY OFFICE	3-STOREY OFFICE BUILDING WITH ROOF DECK	PROJECT PROPONENT	APPROVED BY:	GROUND FLOOR REFERENCE PLAN	DRAWINGS AND SPECIFICATIONS AND CONTRACT DOCUMENTS DULY SIGNED, STAMPED OR SEALED AS INSTRUMENTS FOR SERVICE ARE THE INTELLECTUAL PROPERTY AND DOCUMENTS OF ARCHITECT, WHETHER THE OBJECT FOR WHICH THEY ARE MADE IS EXECUTED OR NOT. IT SHALL BE UNLAWFUL FOR ANY PERSON TO DUPLICATE OR TO MAKE COPIES OF SAID DOCUMENTS FOR USE IN THE REPUTATION OF AND FOR OTHER PROJECTS OR BUILDINGS, WHETHER EXECUTED PARTLY OR IN WHOLE, WITHOUT THE WRITTEN CONSENT OF THE ARCHITECT OR AUTHOR OF SAID DOCUMENTS.	GMT/NBR/SC/CH	JUL 2018					20X30	A-111
	IAPOA : 17156228123072318														
	TIN NO. : 271-680-669-000														
	PTR NO. : 6679972														
	DATE : 2/8/2018														
PLACE : MAKATI CITY		MWSS COMPOUND, KATIPUNAN AVENUE, MATANGDANG BALARA, QUEZON CITY	MWSS COMPOUND, KATIPUNAN AVENUE, MATANGDANG BALARA, QUEZON CITY	MELCHOR S. CORDOVA ALTERNATE END-USER FOR RO BUILDING	PATRICK LESTER N. TY CHIEF REGULATOR, MWSS RO			JDEC	JUL 2018					SCALE	PROJECT NO.
								APPROVED	DATE		ADDITIONAL FIRE EXIT STAIRS		10-30-2018	AS SHOWN	SO-G-17-036
								MOS	JUL 2018	1	SCHEMATIC DESIGN		03-09-2018		

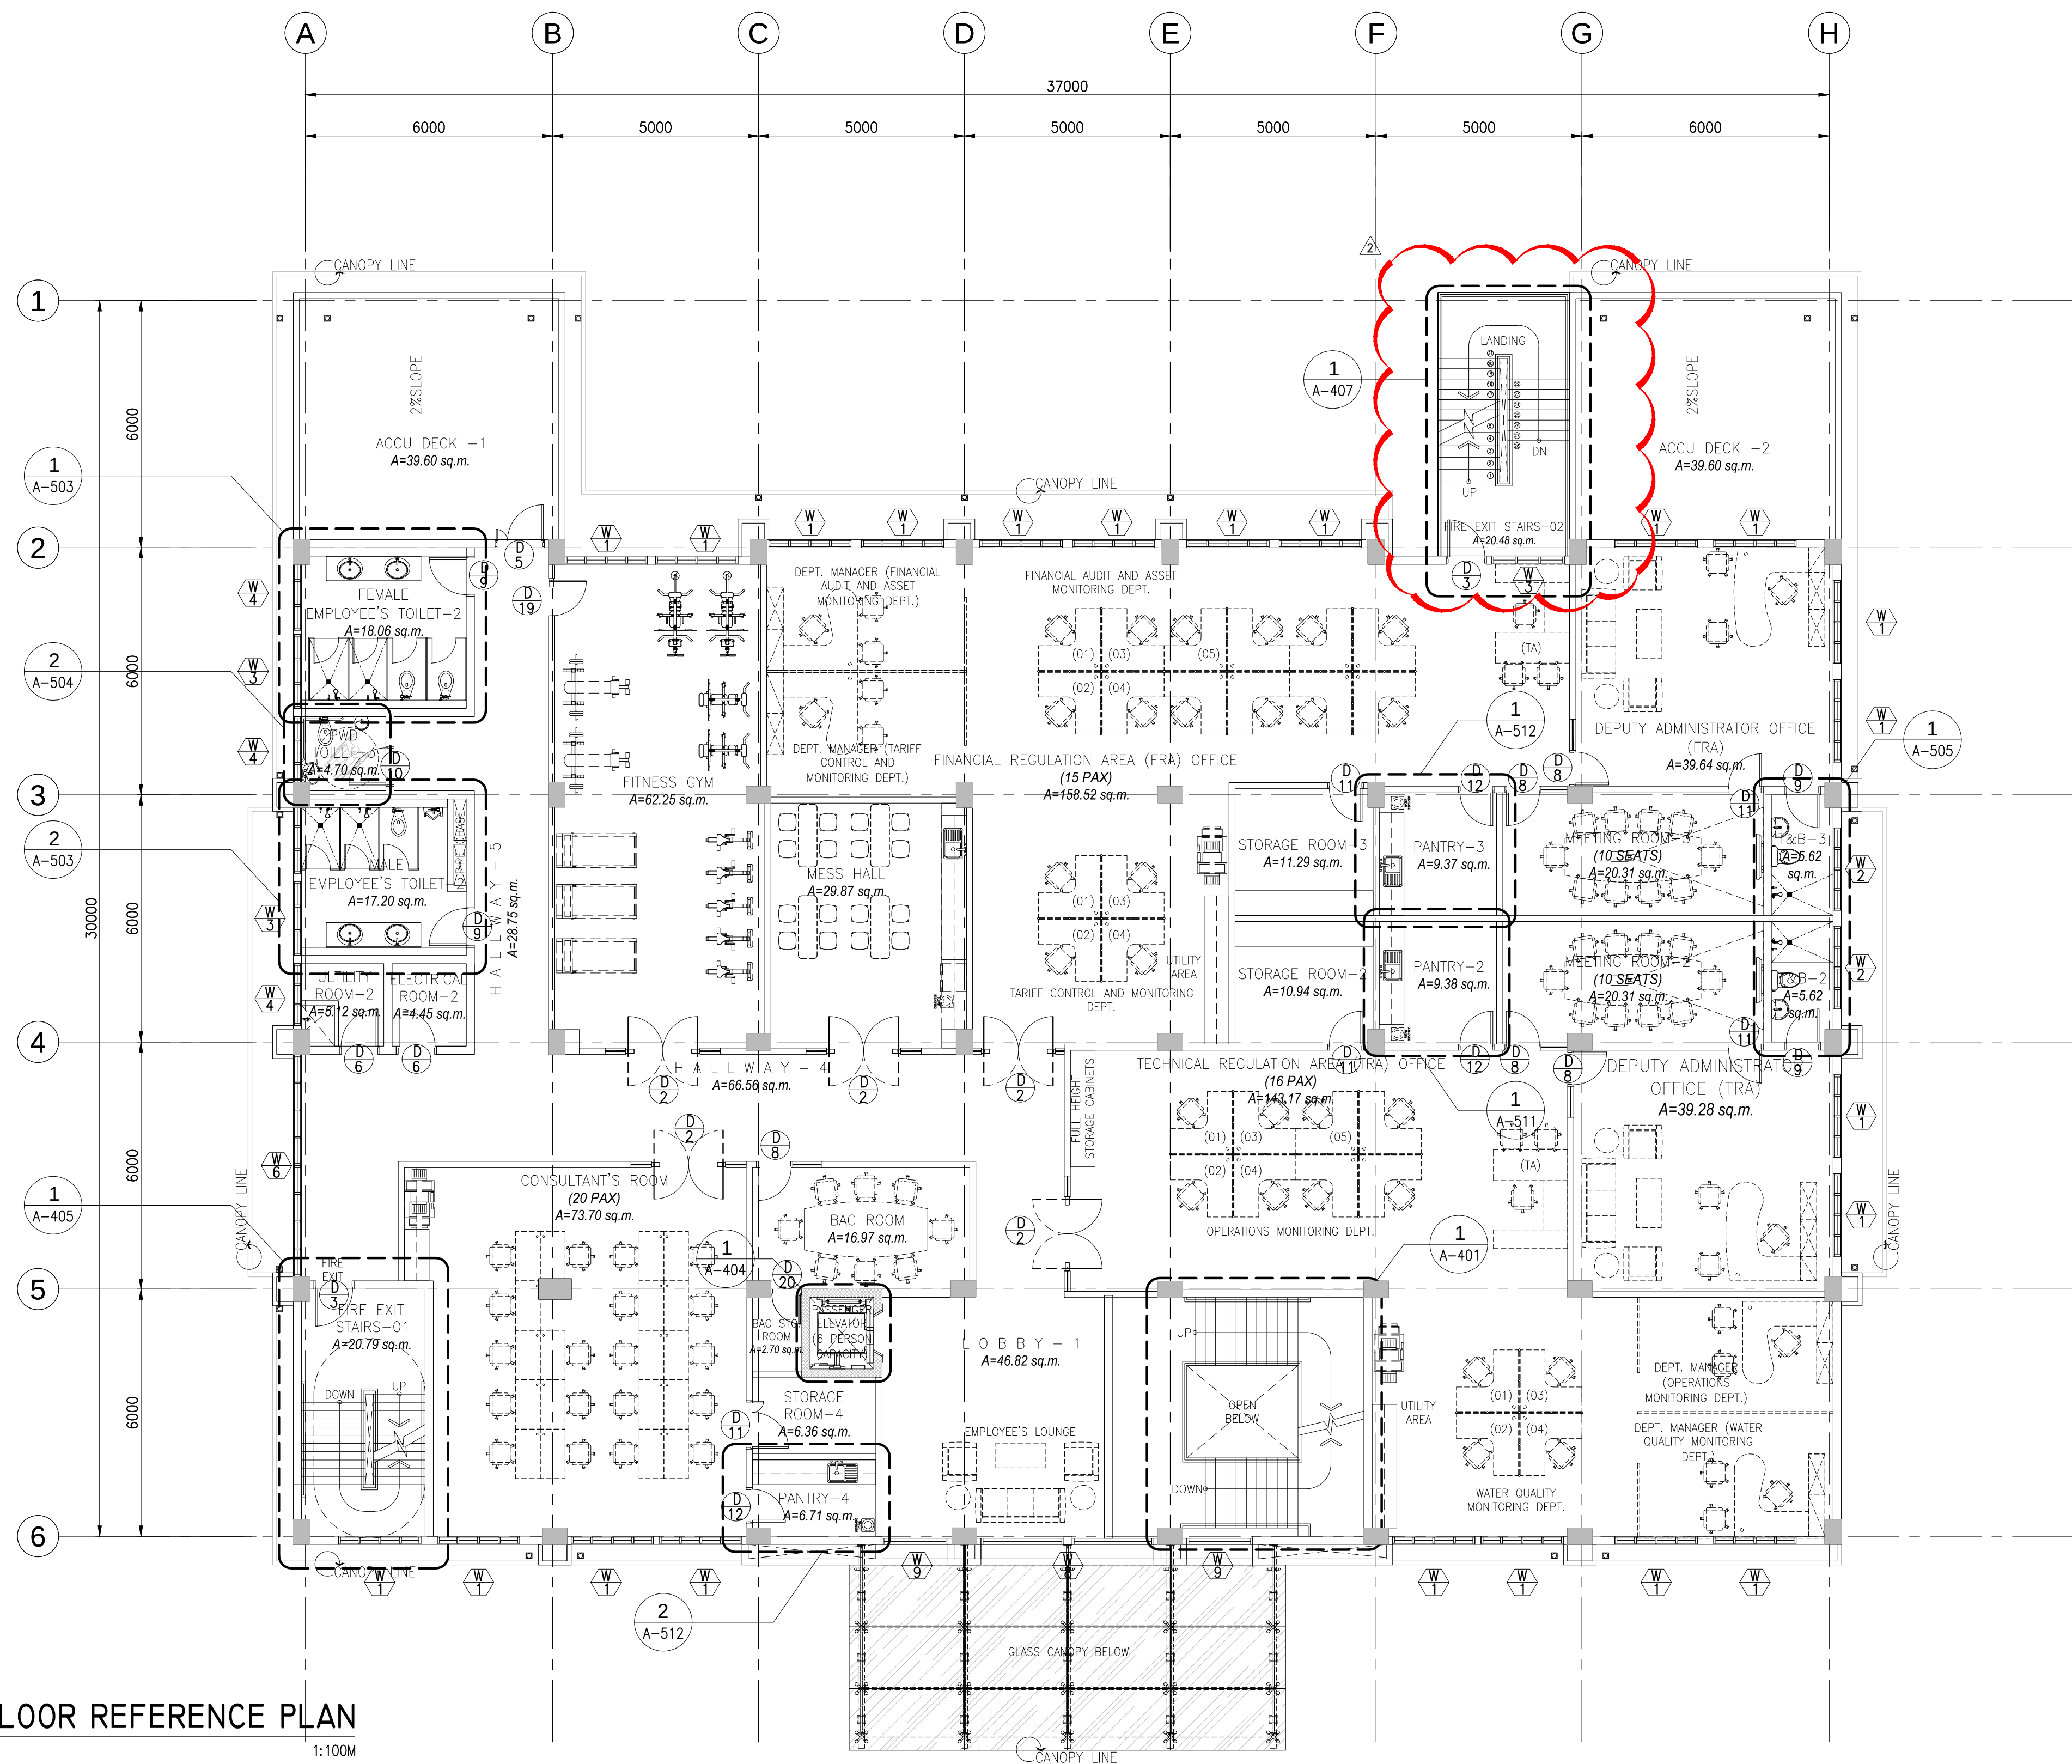


I SECOND FLOOR REFERENCE PLAN
A-112 SCALE 1:100M


CERTIFIED BY		OWNER	PROJECT TITLE/LOCATION	CLIENT	SHEET CONTENTS	R.A. 9266 SEC. 33 DRAWINGS AND SPECIFICATIONS AND CONTRACT DOCUMENTS DULY SIGNED, STAMPED OR SEALED AS INSTRUMENTS FOR SERVICE ARE THE INTELLECTUAL PROPERTY AND DOCUMENTS OF ARCHITECT, WHETHER THE OBJECT FOR WHICH THEY ARE MADE IS EXECUTED OR NOT. IT SHALL BE UNLAWFUL FOR ANY PERSON TO DUPLICATE OR TO MAKE COPIES OF SAID DOCUMENTS FOR USE IN THE REPETITION OF AND FOR OTHER PROJECTS OR BUILDINGS, WHETHER EXECUTED PARTLY OR IN WHOLE, WITHOUT THE WRITTEN CONSENT OF THE ARCHITECT OR AUTHOR OF SAID DOCUMENTS.	CADD	DATE	NO.	REVISIONS	CHK	DATE	PAPER SIZE	SHEET NO.
MICHELANGELA O. SALVADOR, UAP		METROPOLITAN WATERWORKS AND SEWERAGE SYSTEM REGULATORY OFFICE	3-STOREY OFFICE BUILDING WITH ROOF DECK	PROJECT PROPONENT	SECOND FLOOR REFERENCE PLAN		GMT/NBR/SC/	JUL 2018					20X30	A-112
ARCHITECT		MWSS COMPOUND, KATIPUNAN AVENUE, MATANDANG BALARA, QUEZON CITY	MWSS COMPOUND, KATIPUNAN AVENUE, MATANDANG BALARA, QUEZON CITY	MELCHOR S. CORDOVA ALTERNATE END-USER FOR RO BUILDING	PATRICK LESTER N. TY CHIEF REGULATOR, MWSS RO		DESIGNED	DATE					SCALE	PROJECT NO.
							JDEC	JUL 2018					AS SHOWN	SO-G-17-036

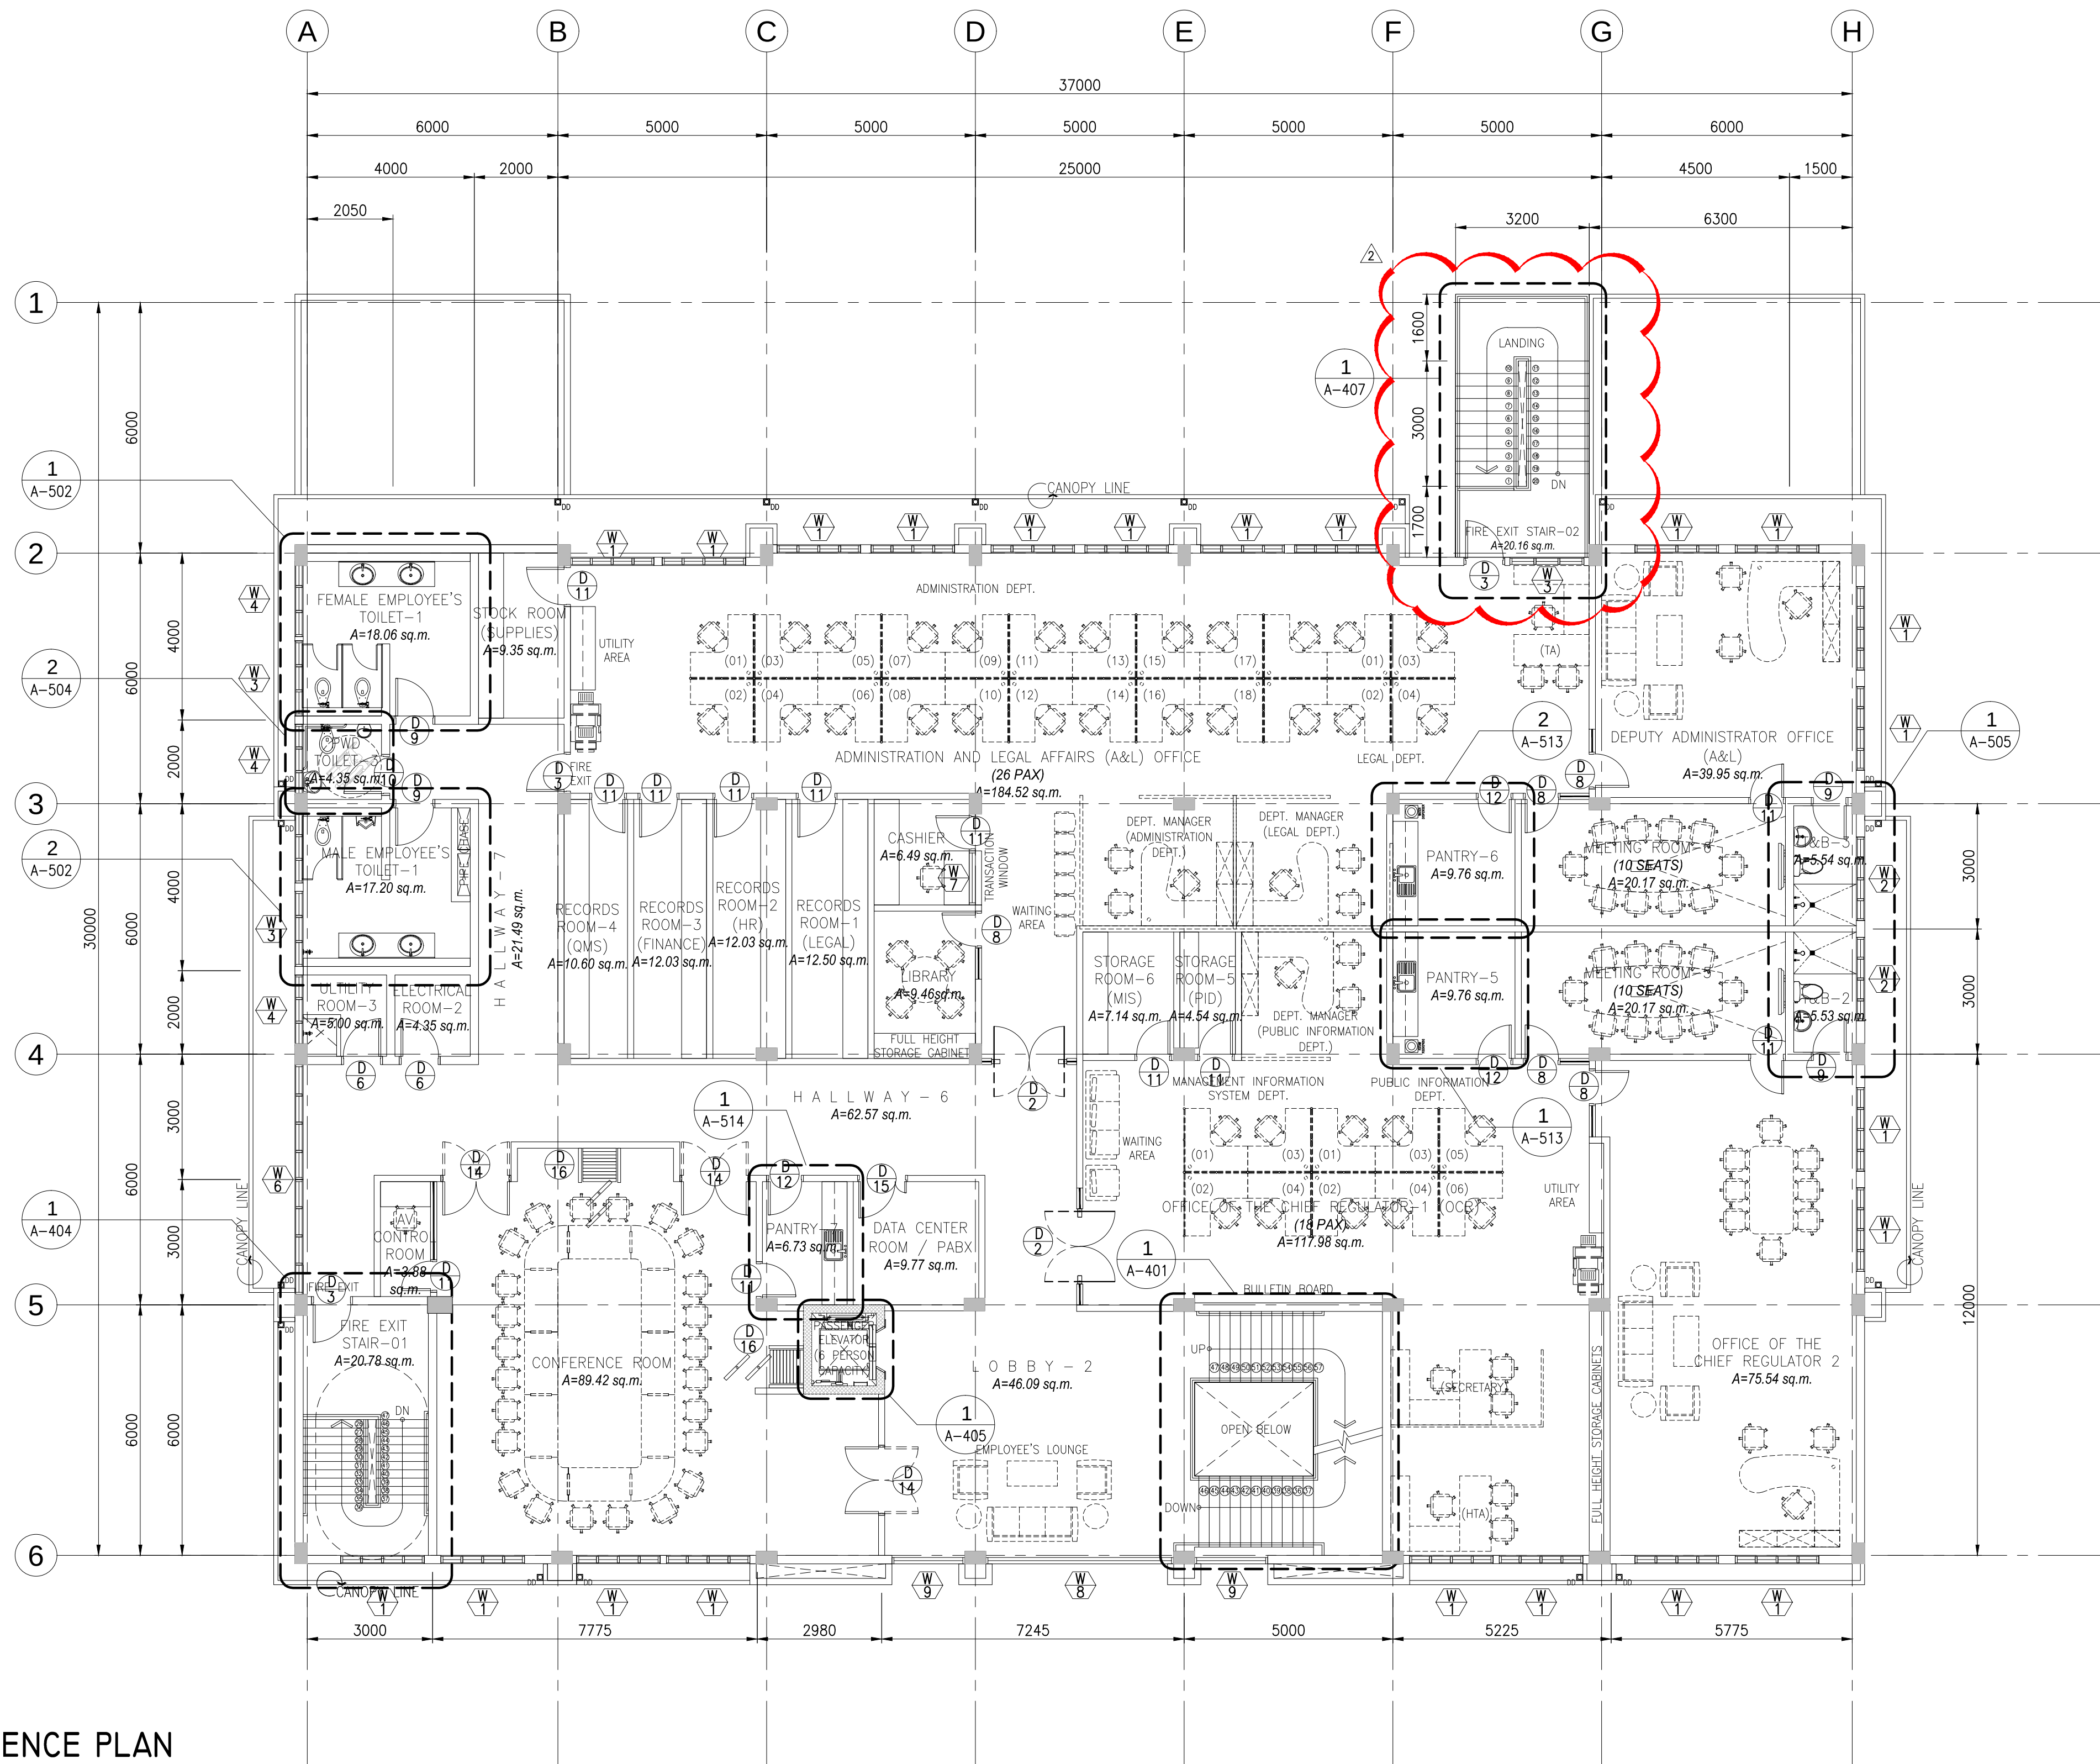

I THIRD FLOOR REFERENCE PLAN
A-113 SCALE 1:100M


a.c.o.n.g CONSULTING INC. Engineering + Management ISO 9001:2015 Certified 2F LTA Building 118 Perea Street, Legaspi Village, 1229 Makati City, Philippines Tel. Nos.: +63 2 8935827 Fax No.: +63 2 8935829 Email: acoconsulting@aco.com.ph Website: www.aco.com.ph	CERTIFIED BY		OWNER	PROJECT TITLE/LOCATION		CLIENT		SHEET CONTENTS		R.A. 9266 SEC. 33		CADD	DATE	NO.	REVISIONS		CHK	DATE	PAPER SIZE	SHEET NO.								
	MICHELANGELA O. SALVADOR, UAP		METROPOLITAN WATERWORKS AND SEWERAGE SYSTEM REGULATORY OFFICE	3-STOREY OFFICE BUILDING WITH ROOF DECK	PROJECT PROPOSER	APPROVED BY:	THIRD FLOOR REFERENCE PLAN	DRAWINGS AND SPECIFICATIONS AND CONTRACT DOCUMENTS DULY SIGNED, STAMPED OR SEALED AS INSTRUMENTS FOR SERVICE ARE THE INTELLECTUAL PROPERTY AND DOCUMENTS OF ARCHITECT, WHETHER THE OBJECT FOR WHICH THEY ARE MADE IS EXECUTED OR NOT. IT SHALL BE UNLAWFUL FOR ANY PERSON TO DUPLICATE OR TO MAKE COPIES OF SAID DOCUMENTS FOR USE IN THE REPETITION OF AND FOR OTHER PROJECTS OR BUILDINGS, WITHOUT THE WRITTEN CONSENT OF THE ARCHITECT OR AUTHOR OF SAID DOCUMENTS.	GMT/NBR/SC/	JUL 2018										20X30	A-113							
									DESIGNED	DATE																		
									JDEC	JUL 2018																	SCALE	PROJECT NO.
									APPROVED	DATE																		
	ARCHITECT		MWSS COMPOUND, KATIPUNAN AVENUE, MATANGANG BALARA, QUEZON CITY	MWSS COMPOUND, KATIPUNAN AVENUE, MATANGANG BALARA, QUEZON CITY	MELCHOR S. CORDOVA ALTERNATE END-USER FOR RO BUILDING	PATRICK LESTER N. TY CHIEF REGULATOR, MWSS RO																						

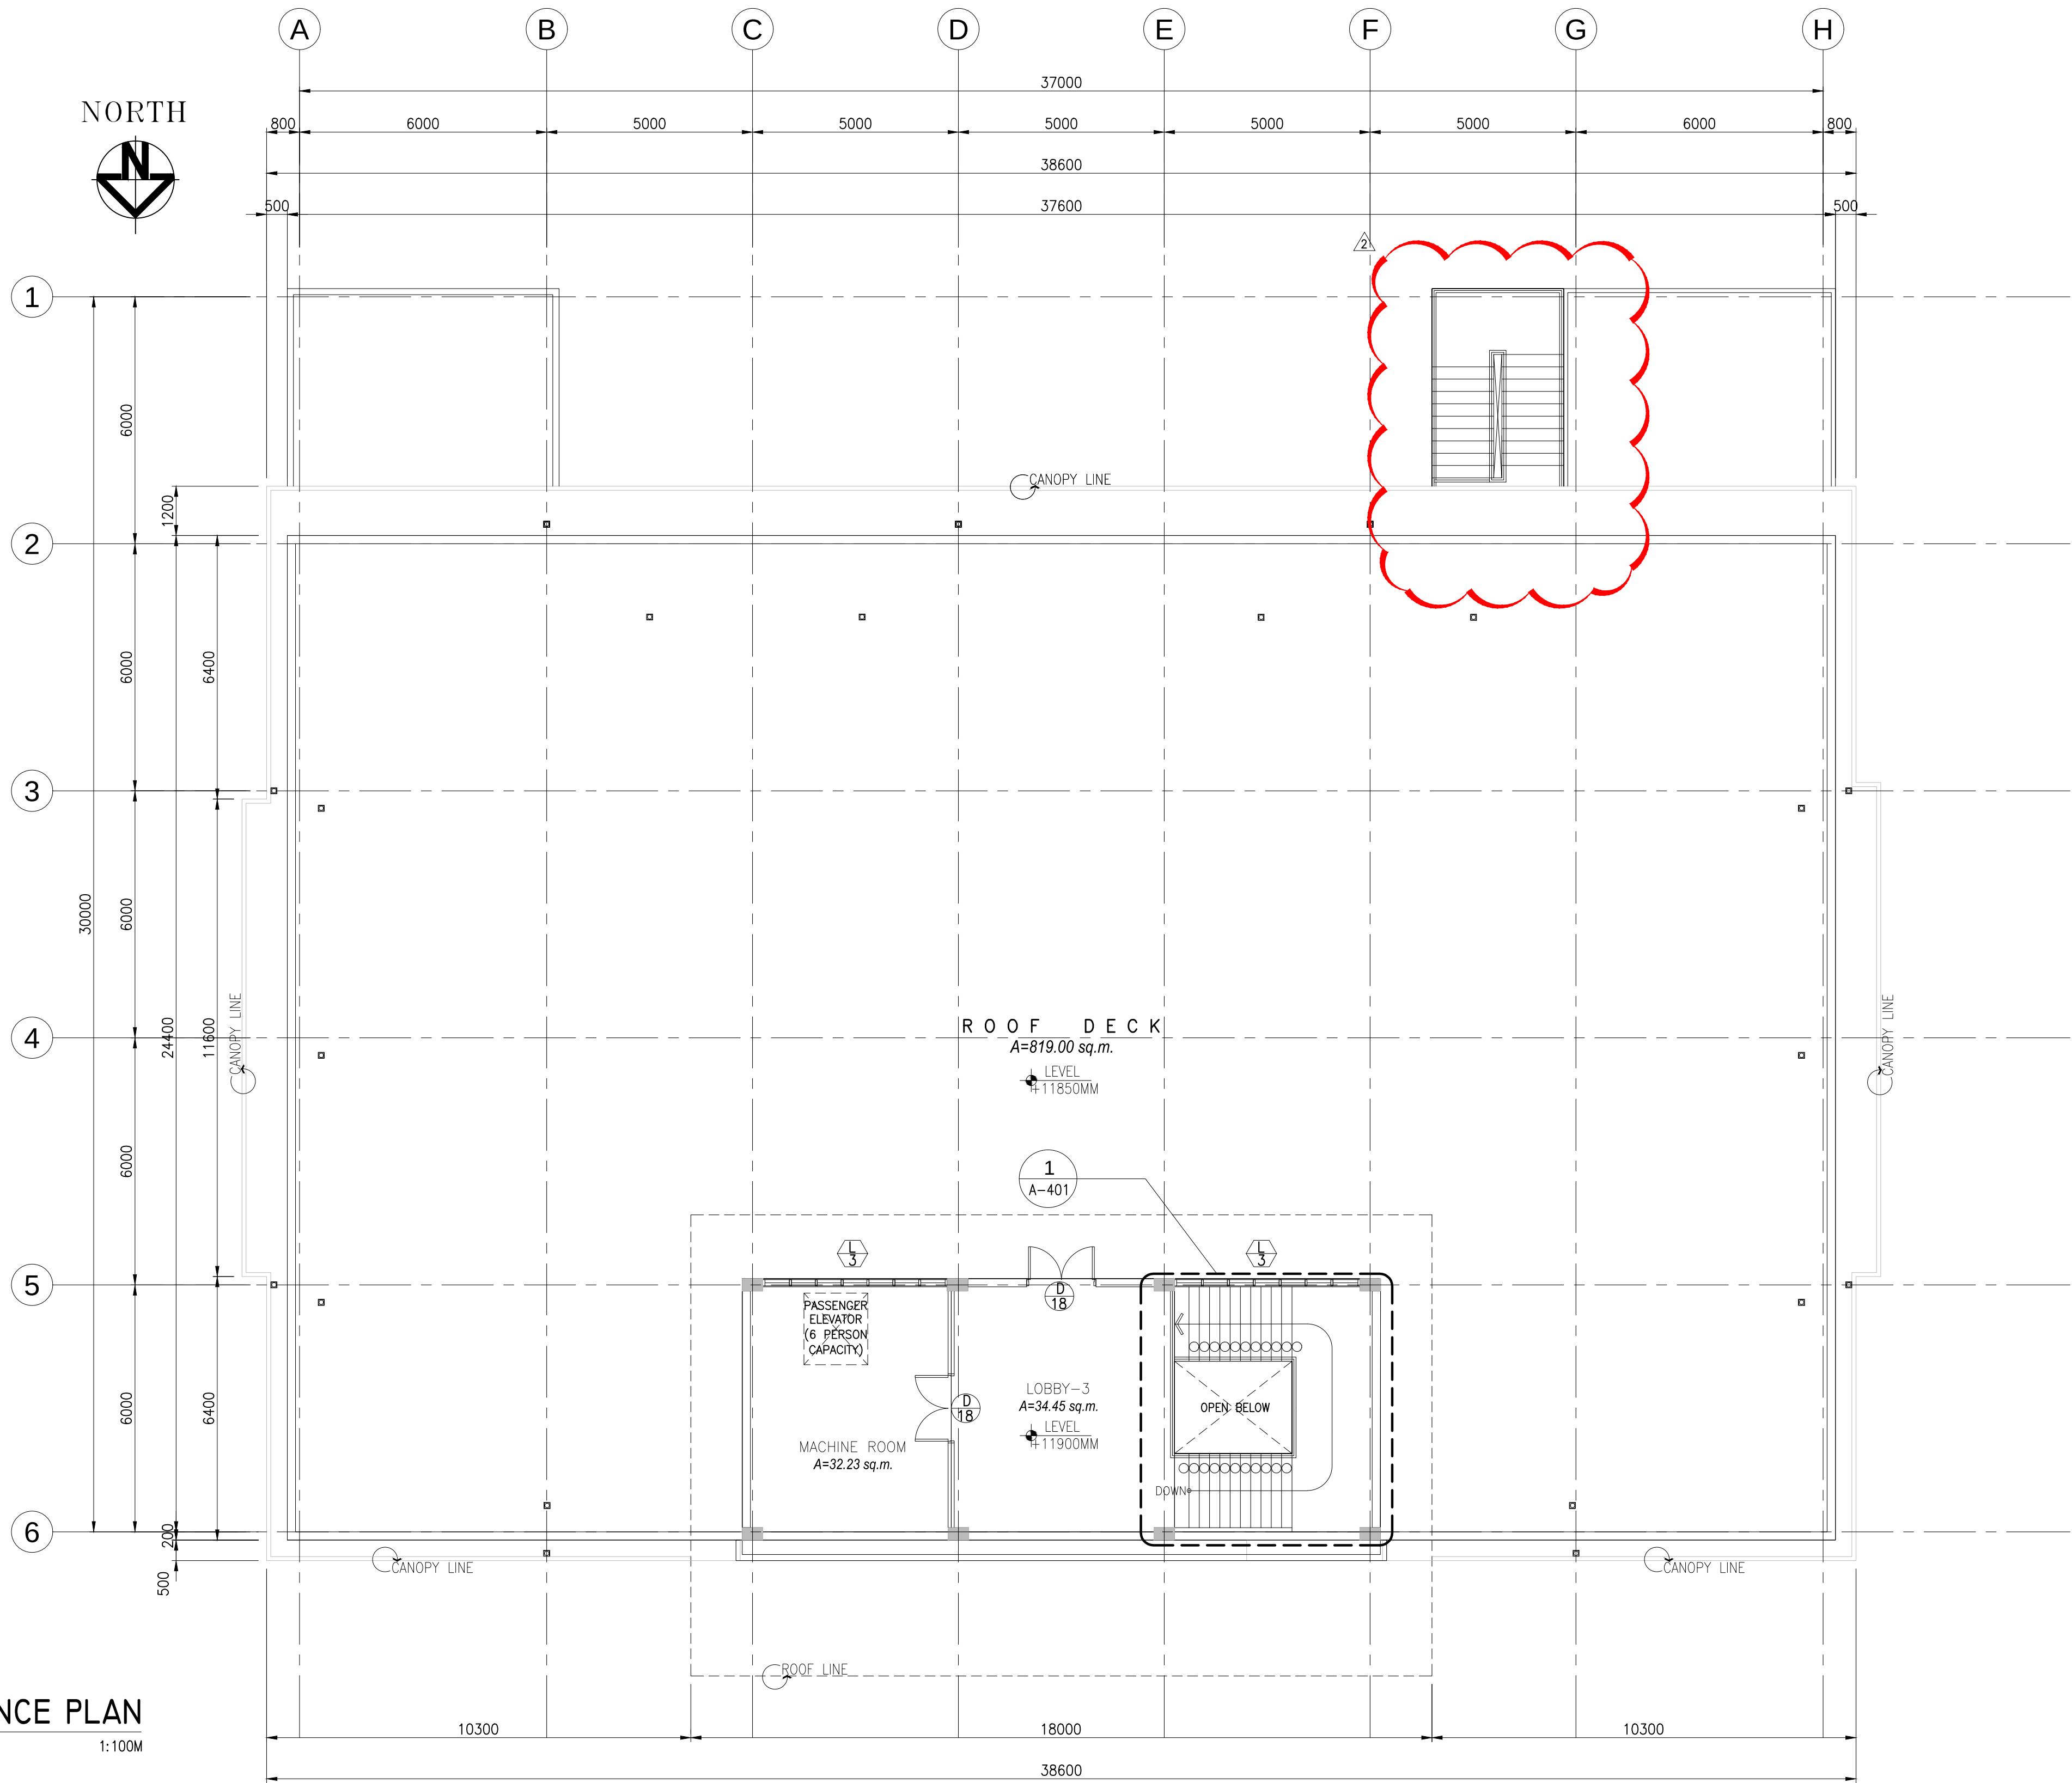

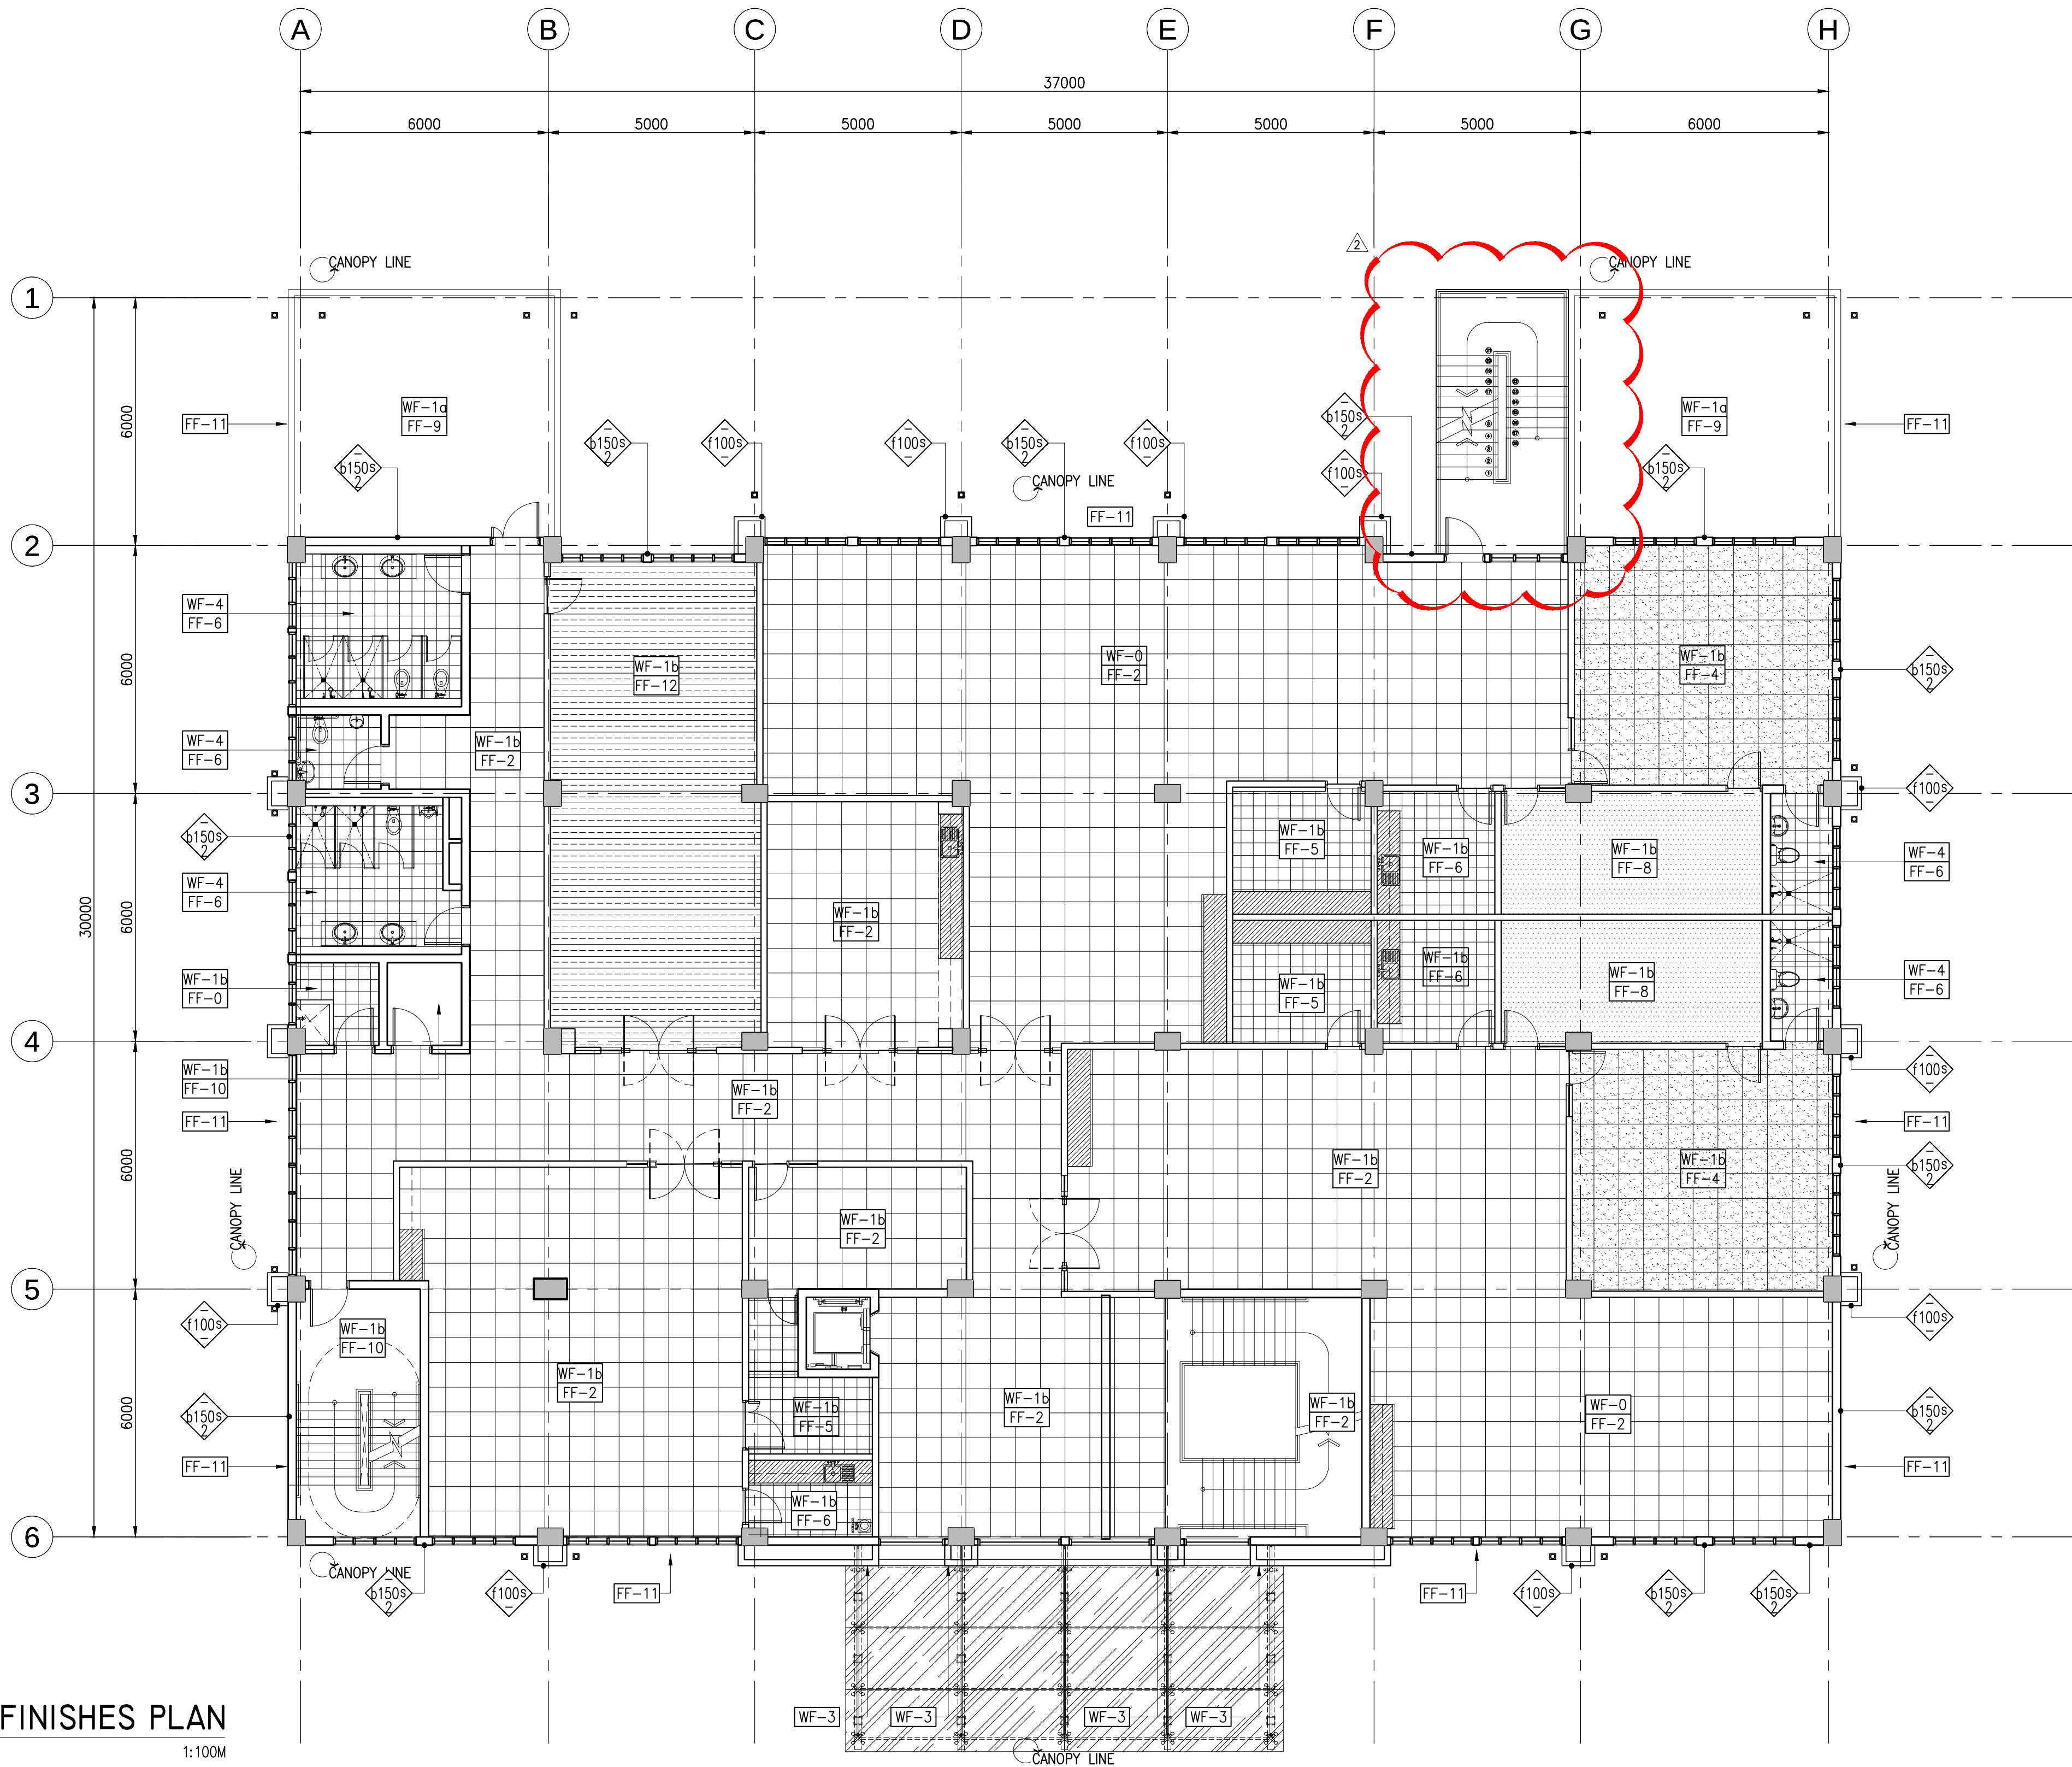

I SECOND FLOOR FINISHES PLAN
A-122 SCALE 1:100M


LEGEND	
WALL TYPE DESIGNATOR	
WALL TYPE	WALL HEIGHT
WALL SIZE	FIRE RATING REQUIRED IN HOURS
WALL SIZE	
- WALL THICKNESS IN MILLIMETER	
* - AS PER MANUFACTURERS STANDARD	
WALL HEIGHT	
h = LIMITED HEIGHT AS INDICATED	
p = TO 200MM ABOVE CEILING	
s = TO STRUCTURE SLAB	
WALL TYPES	
b = CONCRETE MASONRY UNIT	
bp = CONCRETE MASONRY UNIT -PARAPET	
gb1 = 1 LAYER, DOUBLE SIDE GYPSUM BOARD WITH INSULATION	
gb2 = 1 LAYER, DOUBLE SIDE GYPSUM BOARD WITHOUT INSULATION	
f = 1 LAYER, ONE SIDE FIBER CEMENT BOARD	
FIRE RATING	
1 = 1 HOUR (60 MIN.)	
2 = 2 HOURS (120 MIN.)	
WALL FINISH	
WF-1d	SEMI-GLOSS ACRYLIC LATEX BASED PAINT OVER PRIMER
WF-1b	SEMI-GLOSS ACRYLIC LATEX BASED PAINT OVER PRIMER
WF-2	ALUMINUM COMPOSITE PANEL
WF-3	STONE ASSEMBLY
WF-4	300MMX300MM CERAMIC TILES (GLAZED)
FLOOR FINISH	
FF-1	19mm THK. SANDBLASTED FIELD GRANITE STONE
FF-2	600MMX600MM HOMOGENEOUS TILES (POLISHED FINISH)
FF-3	600MMX600MM HOMOGENEOUS TILES (MATTE FINISH)
FF-4	600MMX600MM GRANITE TILES
FF-5	300MMX300MM VINYL TILES
FF-6	300MMX300MM HOMOGENEOUS TILES (MATTE FINISH)
FF-7	300MMX300MM ANTI-STATIC VINYL TILES
FF-8	CARPET TILES
FF-9	TROWELLED CONCRETE TOPPING WITH EPOXY FLOOR COATING
FF-10	TROWELLED CONCRETE TOPPING WITH HARDENER AND DUSTPROOFER
FF-11	STRAIGHT TO FINISH FLOORING W/ CONCRETE FLOOR HARDENER
FF-12	RUBBER FLOORING

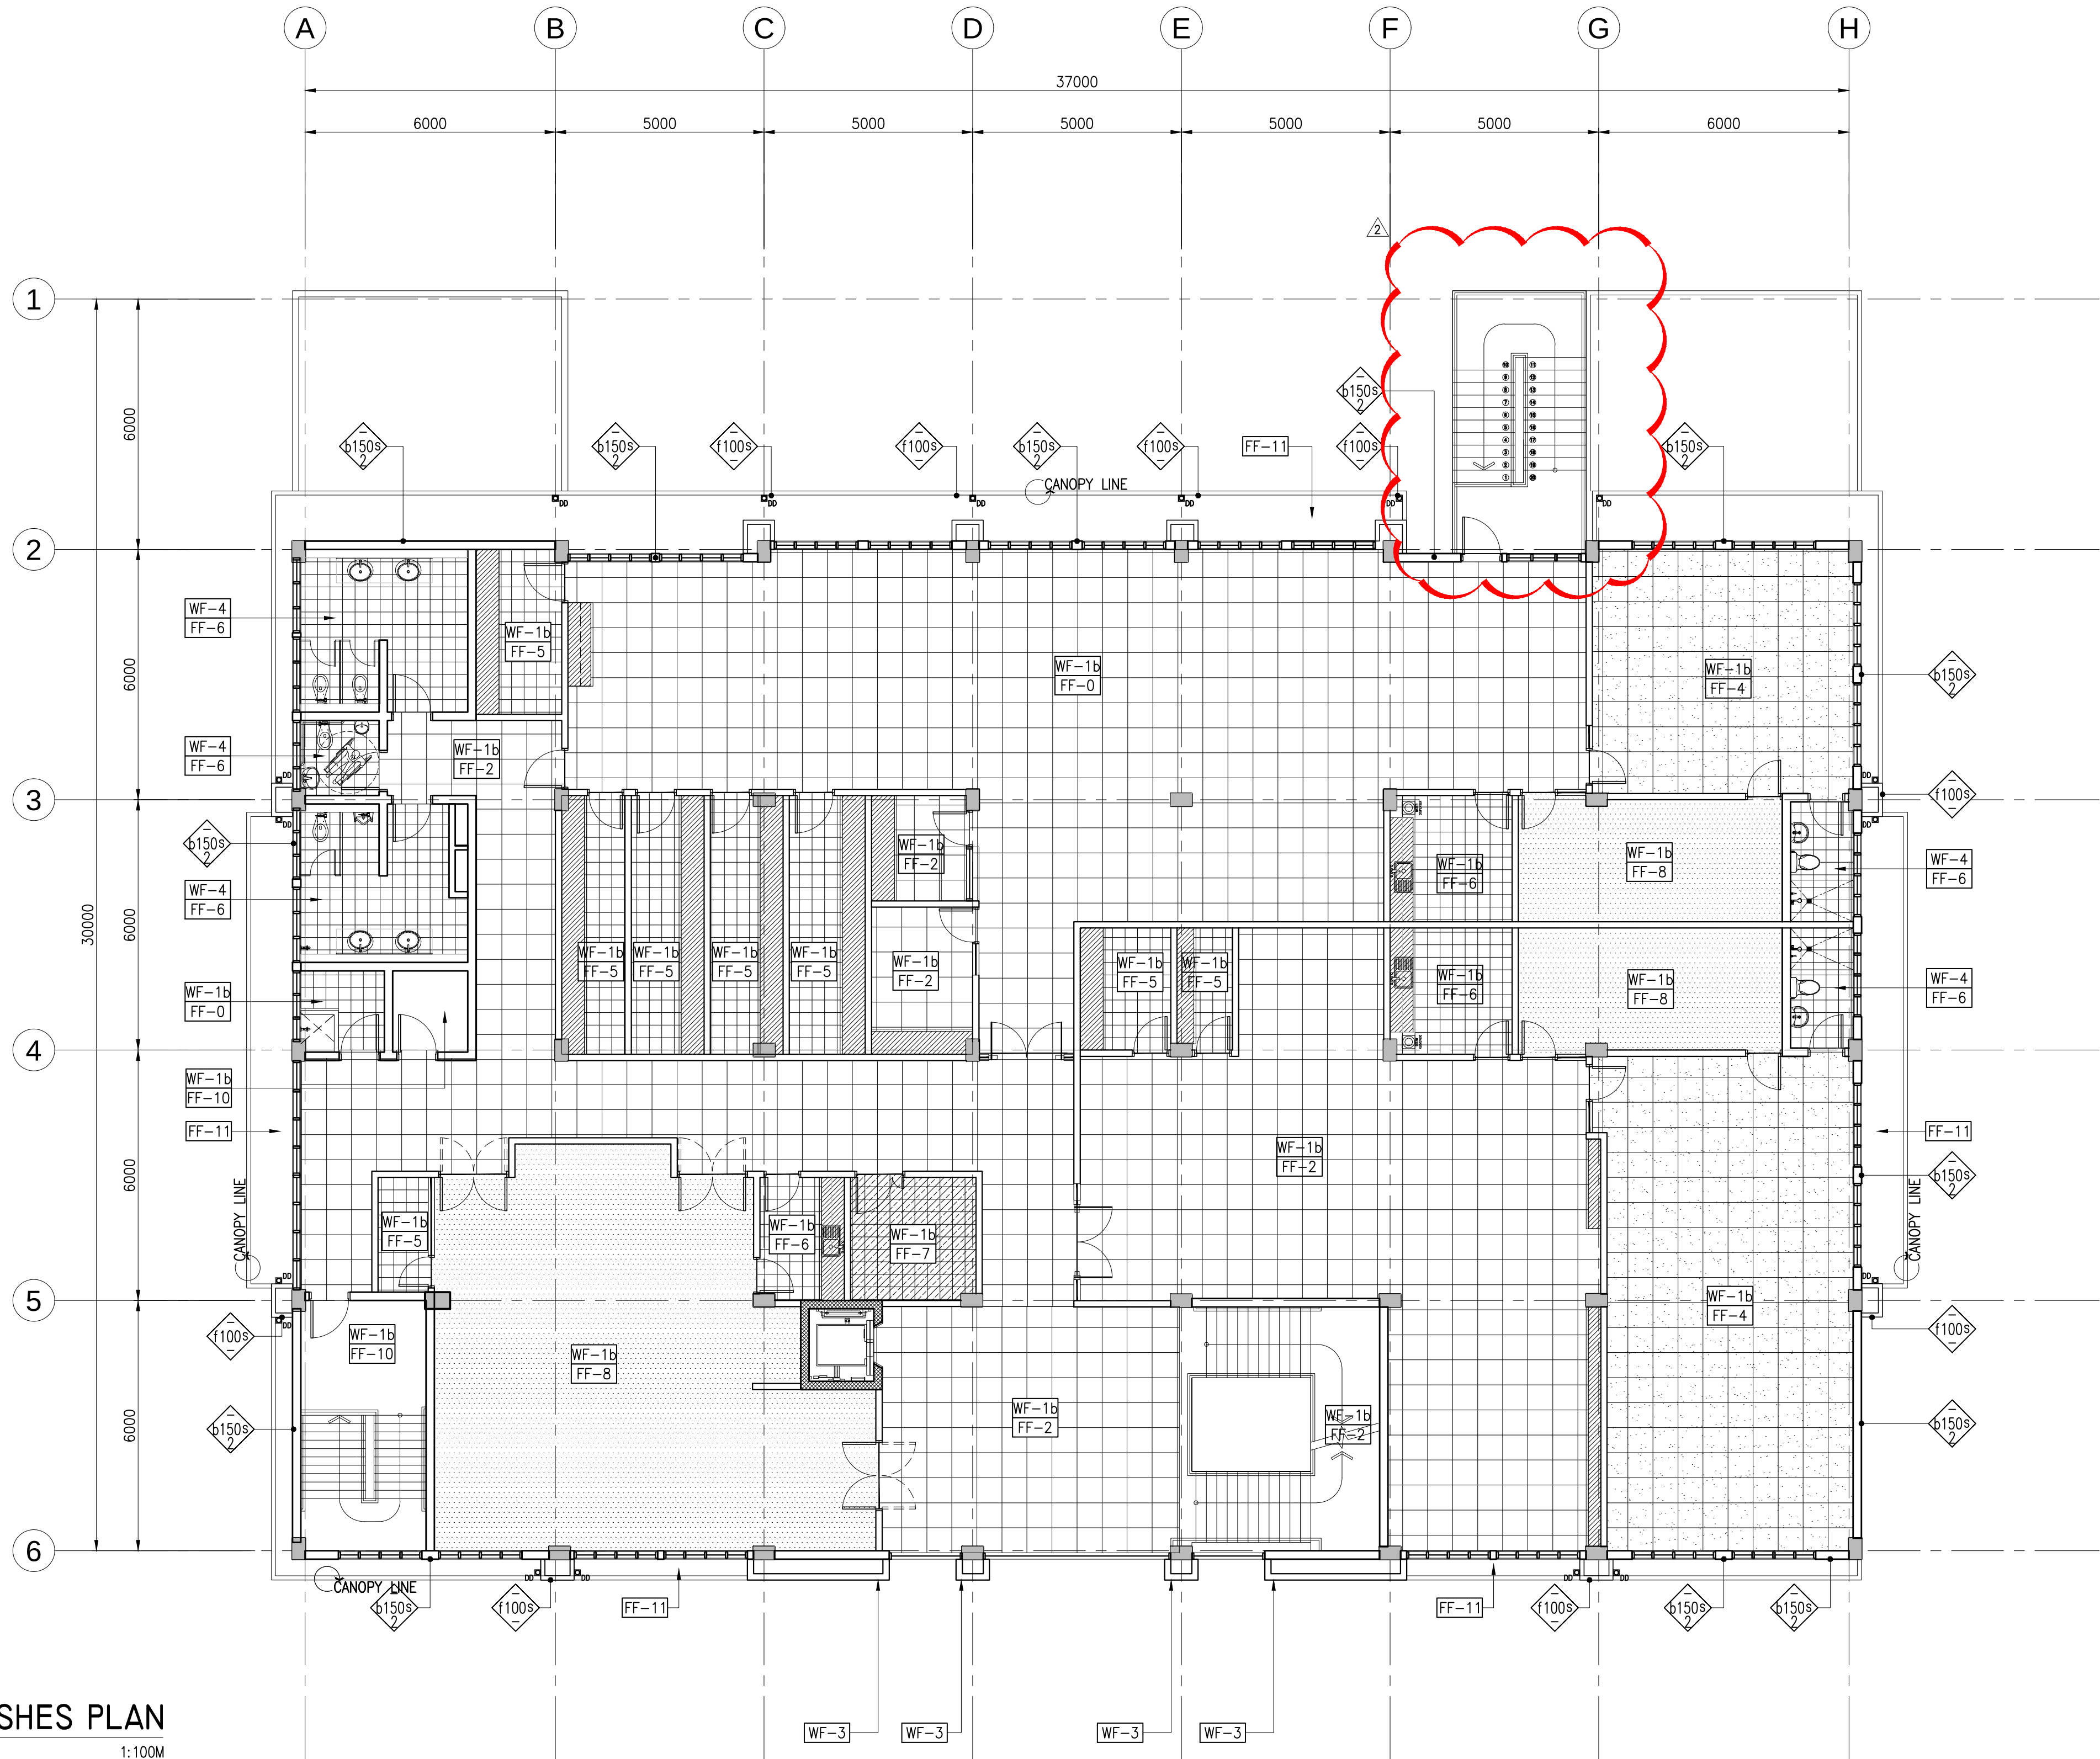

I
A-123
THIRD FLOOR FINISHES PLAN
SCALE 1:100M

LEGEND	
WALL TYPE DESIGNATOR	
WALL TYPE	WALL HEIGHT
WALL SIZE	FIRE RATING REQUIRED IN HOURS
WALL SIZE	
- WALL THICKNESS IN MILLIMETER	
* - AS PER MANUFACTURERS STANDARD	
WALL HEIGHT	
h = LIMITED HEIGHT AS INDICATED	
p = TO 200MM ABOVE CEILING	
s = TO STRUCTURE SLAB	
WALL TYPES	
b = CONCRETE MASONRY UNIT	
bp = CONCRETE MASONRY UNIT -PARAPET	
gb1 = 1 LAYER, DOUBLE SIDE GYPSUM BOARD WITH INSULATION	
gb2 = 1 LAYER, DOUBLE SIDE GYPSUM BOARD WITHOUT INSULATION	
f = ACP CLADDING ON TUBULAR STEEL FRAMING	
FIRE RATING	
1 = 1 HOUR (60 MIN.)	
2 = 2 HOURS (120 MIN.)	
WALL FINISH	
WF-1d	SEMI-GLOSS ACRYLIC LATEX BASED PAINT OVER PRIMER
WF-1b	SEMI-GLOSS ACRYLIC LATEX BASED PAINT OVER PRIMER
WF-2	ALUMINUM COMPOSITE PANEL
WF-3	STONE ASSEMBLY
WF-4	300MMX300MM CERAMIC TILES (GLAZED)
FLOOR FINISH	
FF-1	19mm THK. SANDBLASTED FIELD GRANITE STONE
FF-2	600MMX600MM HOMOGENEOUS TILES (POLISHED FINISH)
FF-3	600MMX600MM HOMOGENEOUS TILES (MATTE FINISH)
FF-4	600MMX600MM GRANITE TILES
FF-5	300MMX300MM VINYL TILES
FF-6	300MMX300MM HOMOGENEOUS TILES (MATTE FINISH)
FF-7	300MMX300MM ANTI-STATIC VINYL TILES
FF-8	CARPET TILES
FF-9	TROWELLED CONCRETE TOPPING WITH EPOXY FLOOR COATING
FF-10	TROWELLED CONCRETE TOPPING WITH HARDENER AND DUSTPROOFER
FF-11	STRAIGHT TO FINISH FLOORING W/ CONCRETE FLOOR HARDENER
FF-12	RUBBER FLOORING


a.c.o.n.g. CONSULTING INC. Engineering + Management ISO 9001:2015 Certified 2F LTA Building 118 Perera Street, Legaspi Village, 1229 Makati City, Philippines Tel. Nos.: +63 2 8935827 Fax No.: +63 2 8935829 Email: acoconsulting@aco.com.ph Website: www.aco.com.ph	CERTIFIED BY	REG. NO. : 0021601 IAPOA : 17156228123072318 TIN NO. : 271-680-669-000 PTR NO. : 6679972 DATE : 2/8/2018 PLACE : MAKATI CITY	OWNER	METROPOLITAN WATERWORKS AND SEWERAGE SYSTEM REGULATORY OFFICE	PROJECT TITLE/LOCATION	3-STOREY OFFICE BUILDING WITH ROOF DECK	CLIENT	PROJECT PROPONENT	APPROVED BY:	SHEET CONTENTS	R.A. 9266 SEC. 33 DRAWINGS AND SPECIFICATIONS AND CONTRACT DOCUMENTS DULY SIGNED, STAMPED OR SEALED AS INSTRUMENTS FOR SERVICE ARE THE INTELLECTUAL PROPERTY AND DOCUMENTS OF ARCHITECT, WHETHER THE OBJECT FOR WHICH THEY ARE MADE IS EXECUTED OR NOT. IT SHALL BE UNLAWFUL FOR ANY PERSON TO DUPLICATE OR TO MAKE COPIES OF SAID DOCUMENTS FOR USE IN THE REPETITION OF AND FOR OTHER PROJECTS OR BUILDINGS, WITHOUT THE WRITTEN CONSENT OF THE ARCHITECT OR AUTHOR OF SAID DOCUMENTS.	CADD	DATE	NO.	REVISIONS	CHK	DATE	PAPER SIZE	SHEET NO.
	MICHELANGELA O. SALVADOR, UAP						MELCHOR S. CORDOVA ALTERNATE END-USER FOR RO BUILDING	PATRICK LESTER N. TY CHIEF REGULATOR, MWSS RO	THIRD FLOOR FINISHES PLAN		GMT/NBR/SC/EH	JUL 2018						20X30	A-123
	ARCHITECT										DESIGNED	DATE						SCALE	PROJECT NO.
											JDEC	JUL 2018							
												APPROVED	DATE	1	ADDITIONAL FIRE EXIT STAIRS	10-30-2018		AS SHOWN	SO-G-17-036
												MOS	JUL 2018	1	SCHEMATIC DESIGN	03-09-2018			

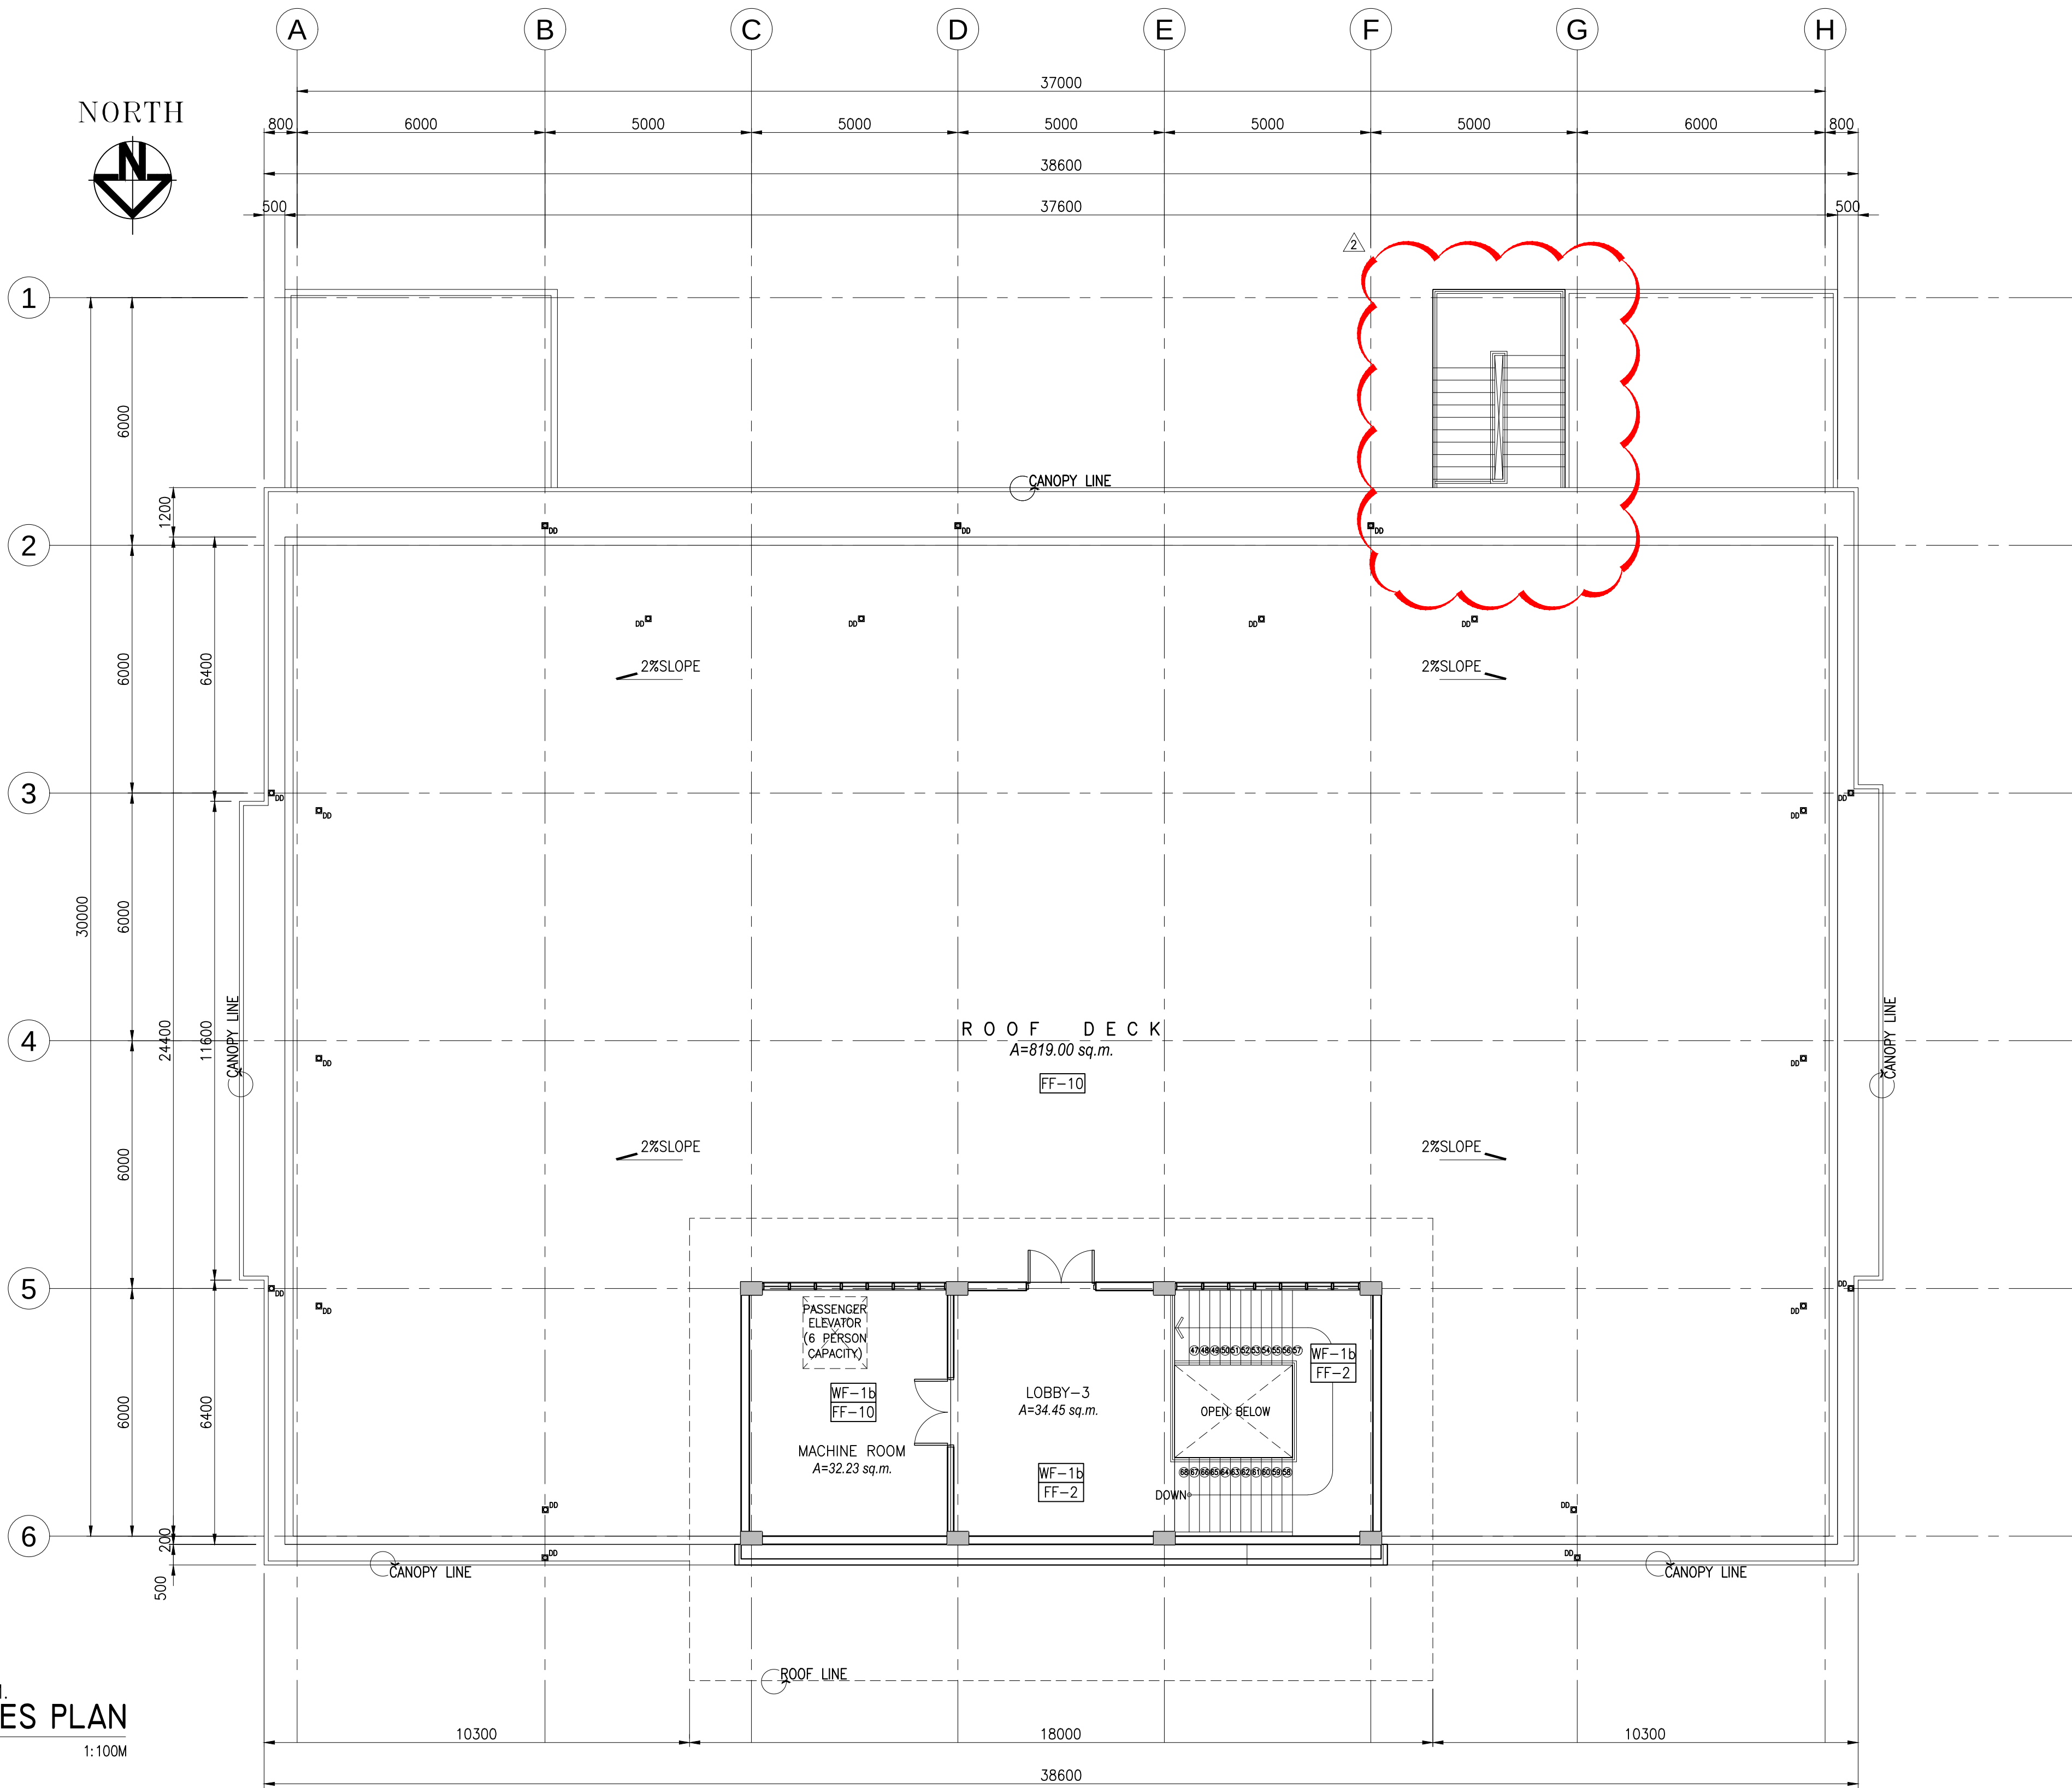

I
A-124


FLOOR AREA = 916.94 SQ. M.
ROOF DECK FINISHES PLAN
SCALE 1:100M

LEGEND	
WALL TYPE DESIGNATOR	
WALL TYPE WALL SIZE	WALL HEIGHT FIRE RATING REQUIRED IN HOURS
WALL SIZE - WALL THICKNESS IN MILLIMETER * - AS PER MANUFACTURERS STANDARD	
WALL HEIGHT h = LIMITED HEIGHT AS INDICATED p = TO 200MM ABOVE CEILING s = TO STRUCTURE SLAB	
WALL TYPES b = CONCRETE MASONRY UNIT bp = CONCRETE MASONRY UNIT -PARAPET gb1 = 1 LAYER, DOUBLE SIDE GYPSUM BOARD WITH INSULATION gb2 = 1 LAYER, DOUBLE SIDE GYPSUM BOARD WITHOUT INSULATION f = ACP CLADDING ON TUBULAR STEEL FRAMING	
FIRE RATING 1 = 1 HOUR (60 MIN.) 2 = 2 HOURS (120 MIN.)	
WALL FINISH	
WF-1d	SEMI-GLOSS ACRYLIC LATEX BASED PAINT OVER PRIMER
WF-1b	SEMI-GLOSS ACRYLIC LATEX BASED PAINT OVER PRIMER
WF-2	ALUMINUM COMPOSITE PANEL
WF-3	STONE ASSEMBLY
WF-4	300MMX300MM CERAMIC TILES (GLAZED)
FLOOR FINISH	
FF-1	19mm THK. SANDBLASTED FIELD GRANITE STONE
FF-2	600MMX600MM HOMOGENEOUS TILES (POLISHED FINISH)
FF-3	600MMX600MM HOMOGENEOUS TILES (MATTE FINISH)
FF-4	600MMX600MM GRANITE TILES
FF-5	300MMX300MM HOMOGENEOUS TILES (POLISHED FINISH)
FF-6	300MMX300MM HOMOGENEOUS TILES (MATTE FINISH)
FF-7	300MMX300MM ANTI-STATIC VINYL TILES
FF-8	CARPET TILES
FF-9	TROWELLED CONCRETE TOPPING WITH EPOXY FLOOR COATING
FF-10	TROWELLED CONCRETE TOPPING WITH HARDENER AND DUSTPROOFER
FF-11	STRAIGHT TO FINISH FLOORING W/ CONCRETE FLOOR HARDENER

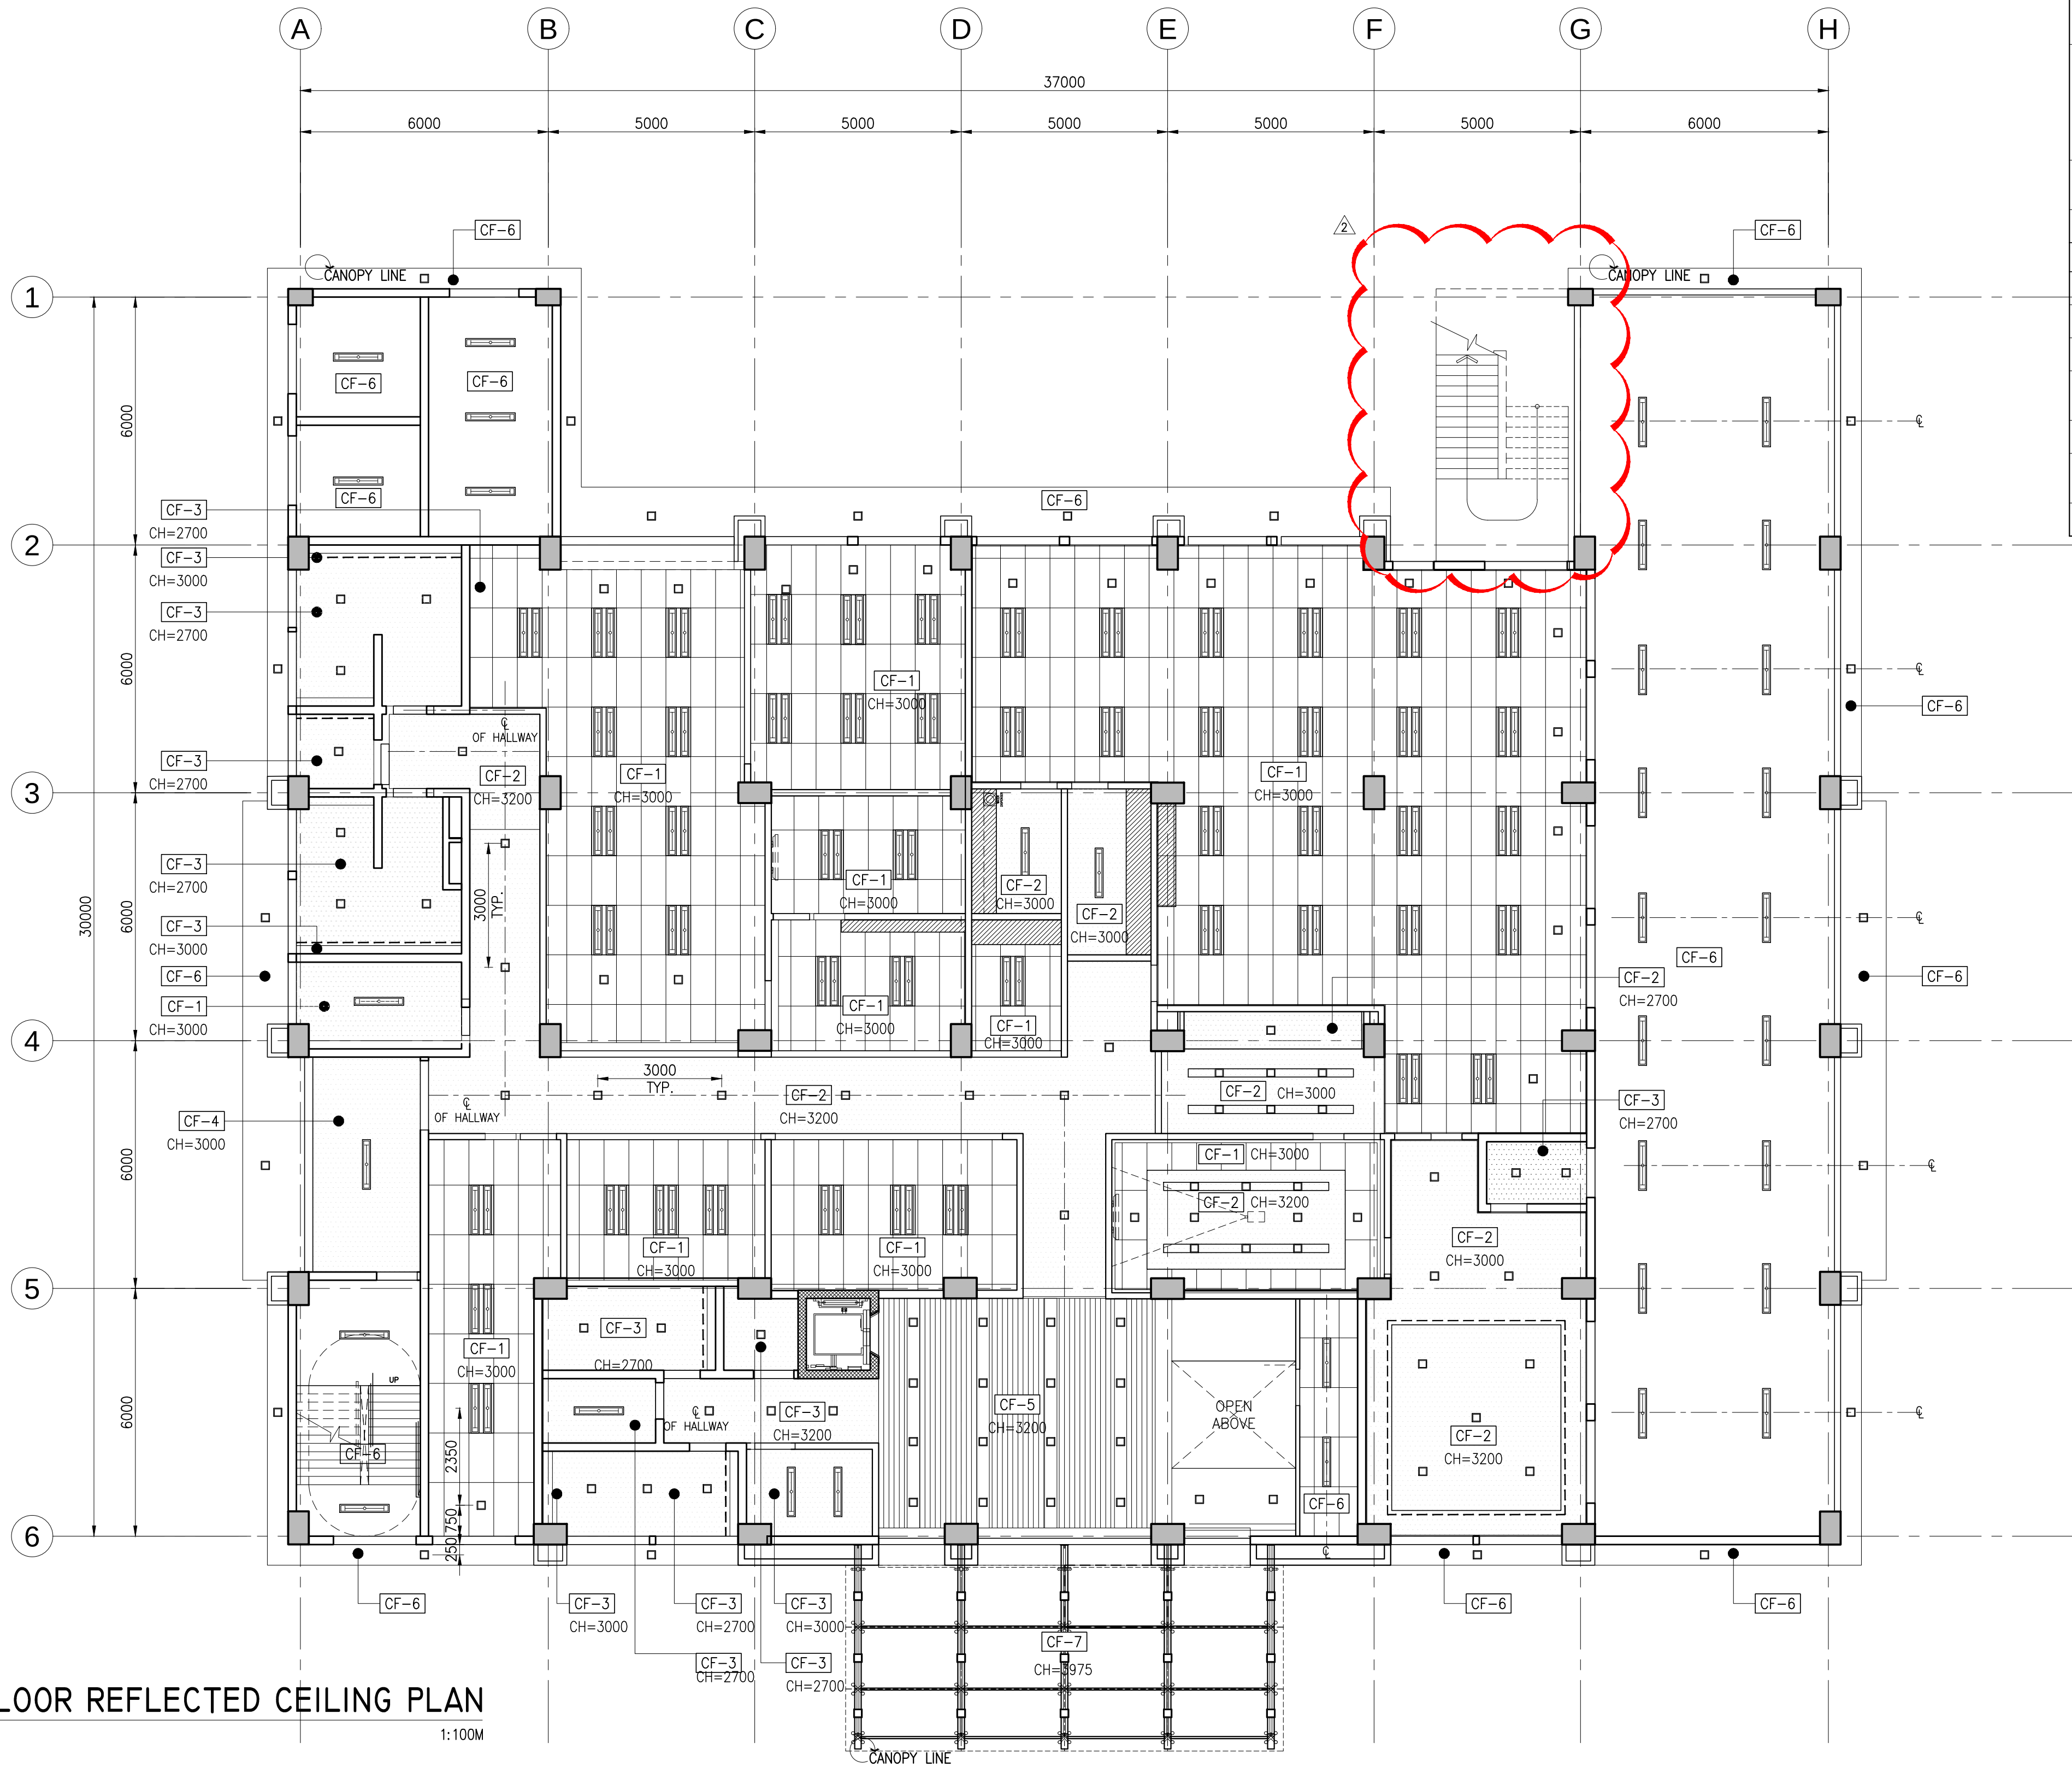


LEGEND	
LIGHTING FIXTURES	
	1X9W LED SUSPENDED OR SURFACE MOUNTED DOWNLIGHT
	2X15W T-5 RECESSED MOUNTED LED LAMP WITH CENTRAL LOUVER AND WHITE POWDER COATED BACKING REFLECTOR, ZINC PHOSPHATED STEEL SHEET HOUSING WITH POWDER COAT PAINT FINISH, MIRROR FINISH ANODIZED ALUMINUM REFLECTOR AND SPECULAR LOUVER
	1X15W LED T-5 SUSPENDED OR SURFACE MOUNTED INDUSTRIAL LIGHTING FIXTURE WITH BATTERY PACK
	14W LED LAMP COVELIGHT
CEILING FINISHES	
CF-1	600mm X 1200mm ACOUSTICAL CEILING PANEL
CF-2	PAINTED FINISH, 12mm THK. TYPE X GYPSUM BOARD
CF-3	PAINTED FINISH, 12mm THK. MR TYPE GYPSUM BOARD
CF-4	PAINTED FINISH, 12mm THK. FIBER CEMENT BOARD
CF-5	LINEAR METAL CEILING
CF-6	PAINTED FINISH, FAIR FACED CONCRETE UNDERSLABS, SOFFIT, AND BEAMS
CF-7	12mm THK. CLEAR TEMPERED GLASS PANEL

I GROUND FLOOR REFLECTED CEILING PLAN
A-131 SCALE 1:100M

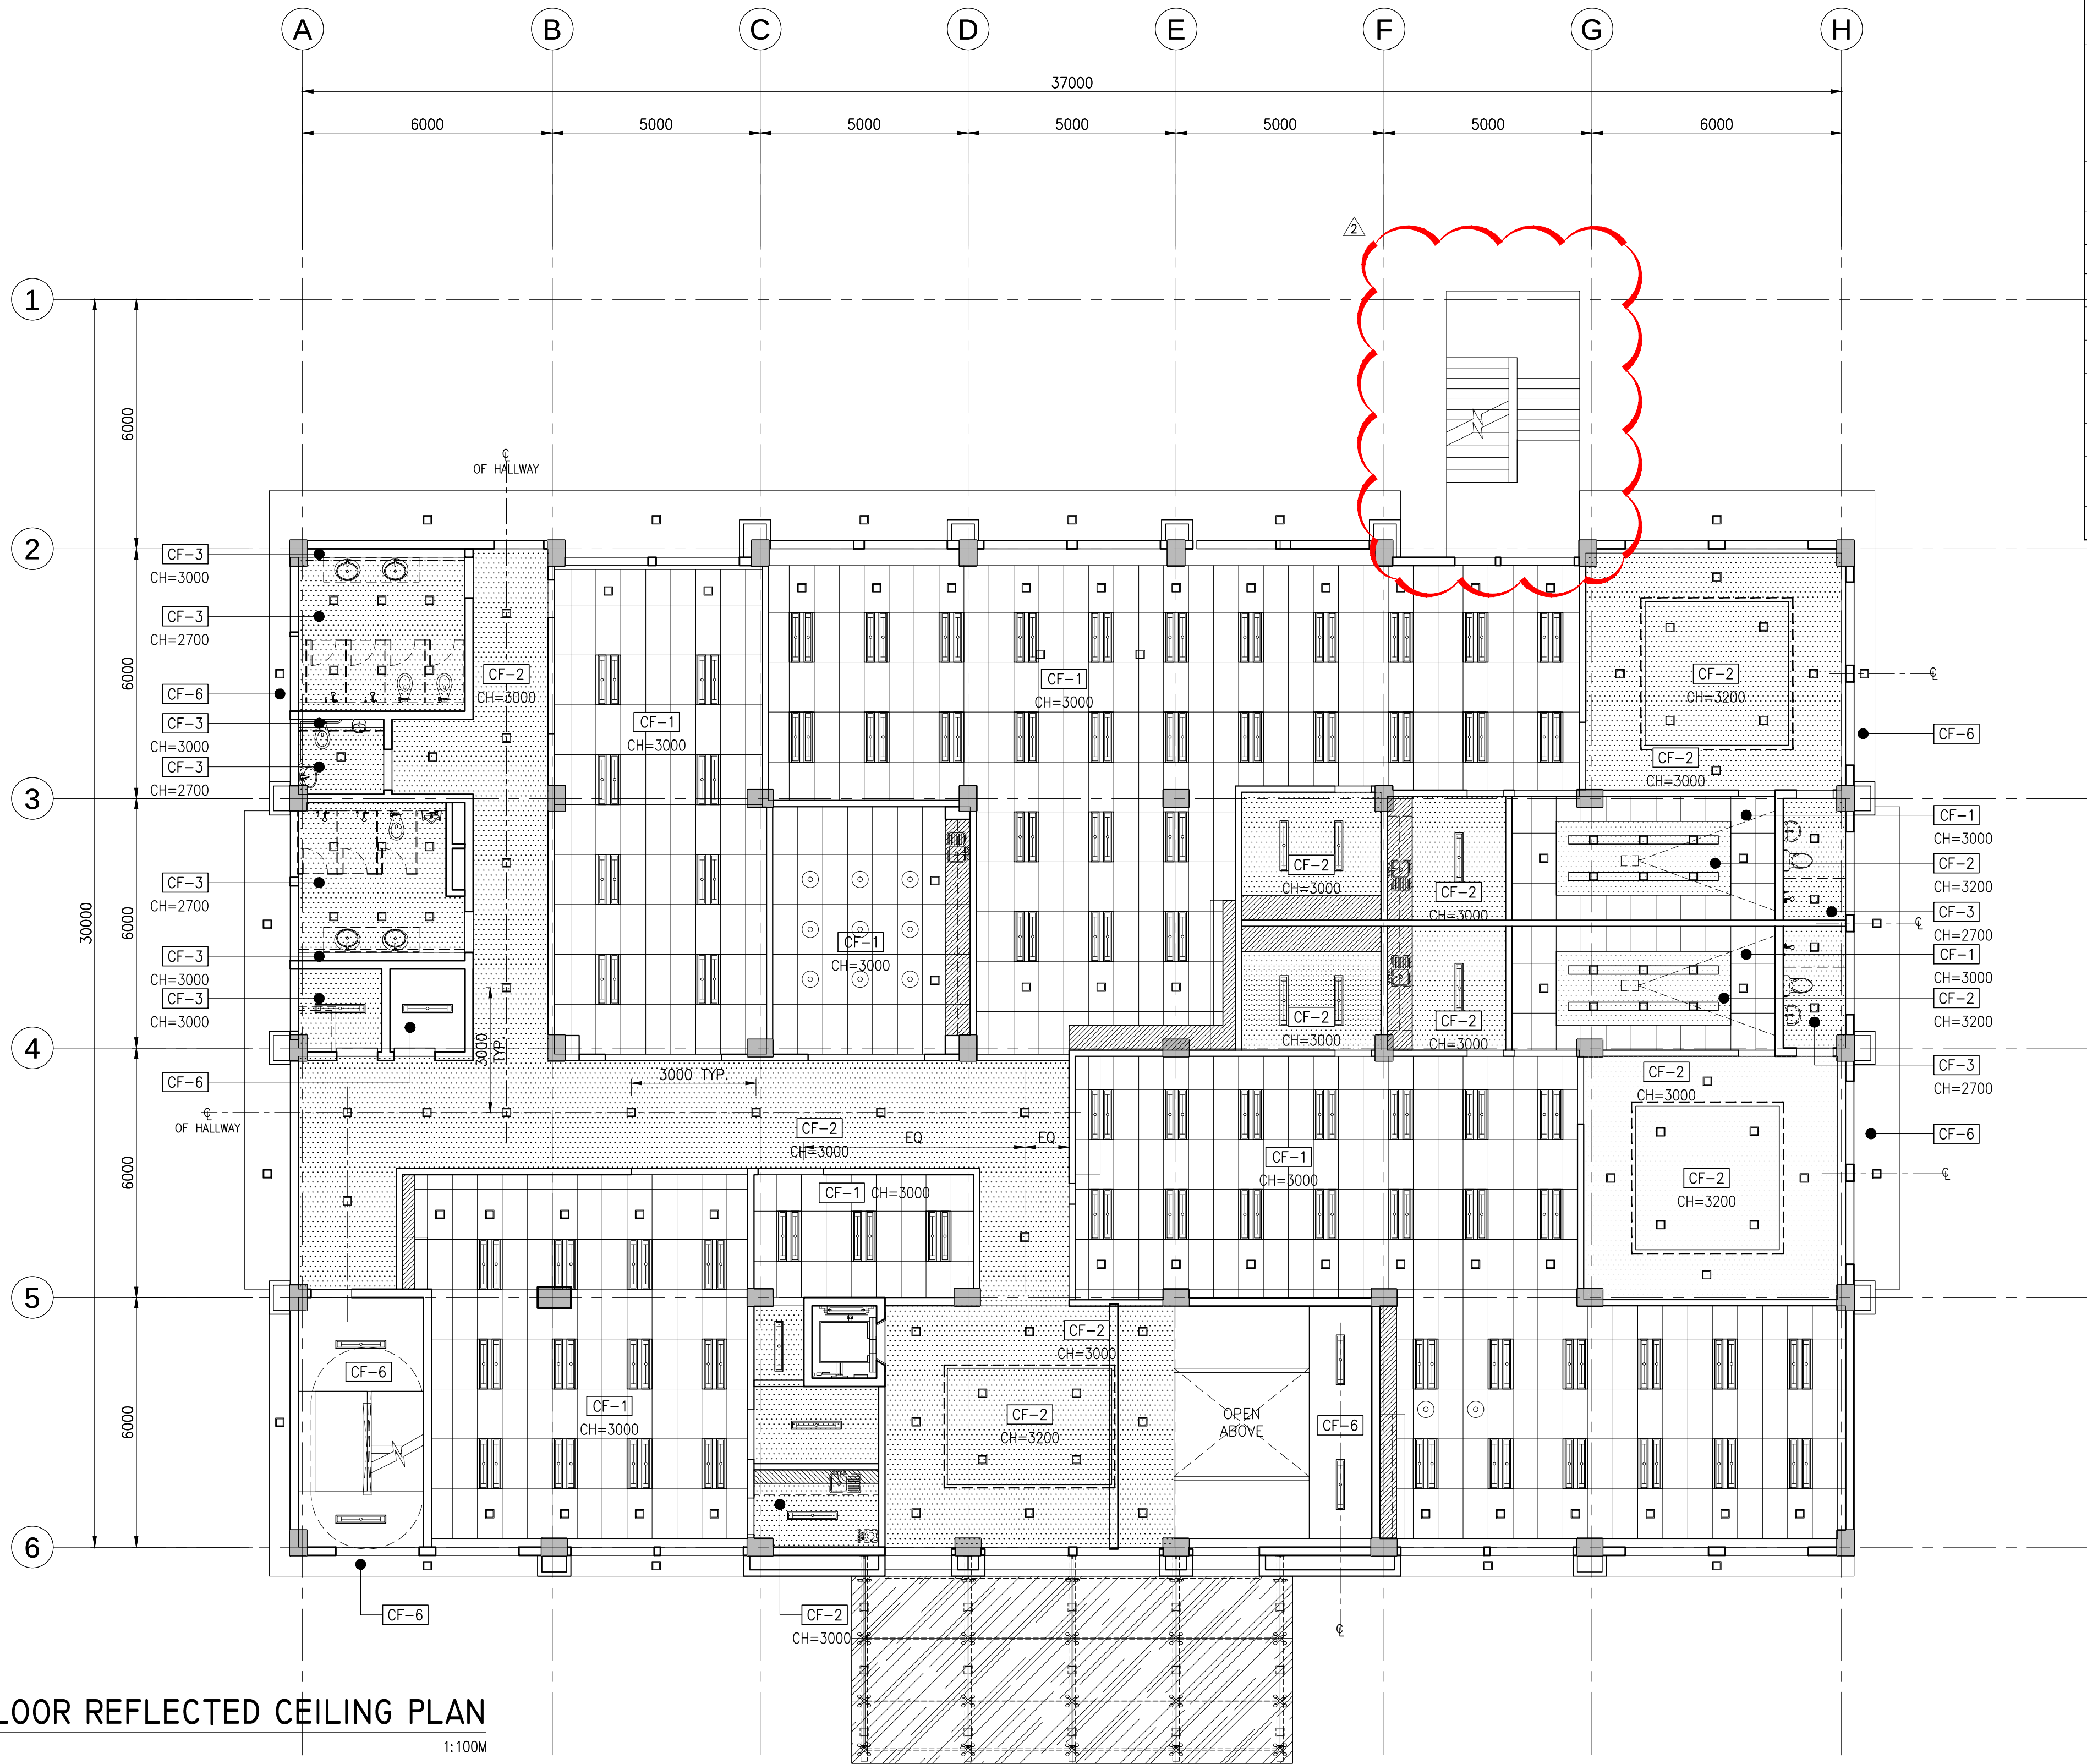


LEGEND	
LIGHTING FIXTURES	
	1X9W LED SUSPENDED OR SURFACE MOUNTED DOWNLIGHT
	2X15W T-5 RECESSED MOUNTED LED LAMP WITH CENTRAL LOUVER AND WHITE POWDER COATED BACKING REFLECTOR, ZINC PHOSPHATED STEEL SHEET HOUSING WITH POWDER COAT PAINT FINISH, MIRROR FINISH ANNOXIDIZED ALUMINUM REFLECTOR AND SPECULAR LOUVER
	1X15W LED T-5 SUSPENDED OR SURFACE MOUNTED INDUSTRIAL LIGHTING FIXTURE WITH BATTERY PACK
	14W LED LAMP COVELIGHT
CEILING FINISHES	
CF-1	600mm X 1200mm ACOUSTICAL CEILING PANEL
CF-2	PAINTED FINISH, 12mm THK. TYPE X GYPSUM BOARD
CF-3	PAINTED FINISH, 12mm THK. MR TYPE GYPSUM BOARD
CF-4	PAINTED FINISH, 12mm THK. FIBER CEMENT BOARD
CF-5	LINEAR METAL CEILING
CF-6	PAINTED FINISH, FAIR FACED CONCRETE UNDERSLABS, SOFFIT, AND BEAMS
CF-7	12mm THK. CLEAR TEMPERED GLASS PANEL

I SECOND FLOOR REFLECTED CEILING PLAN
A-132 SCALE 1:100M

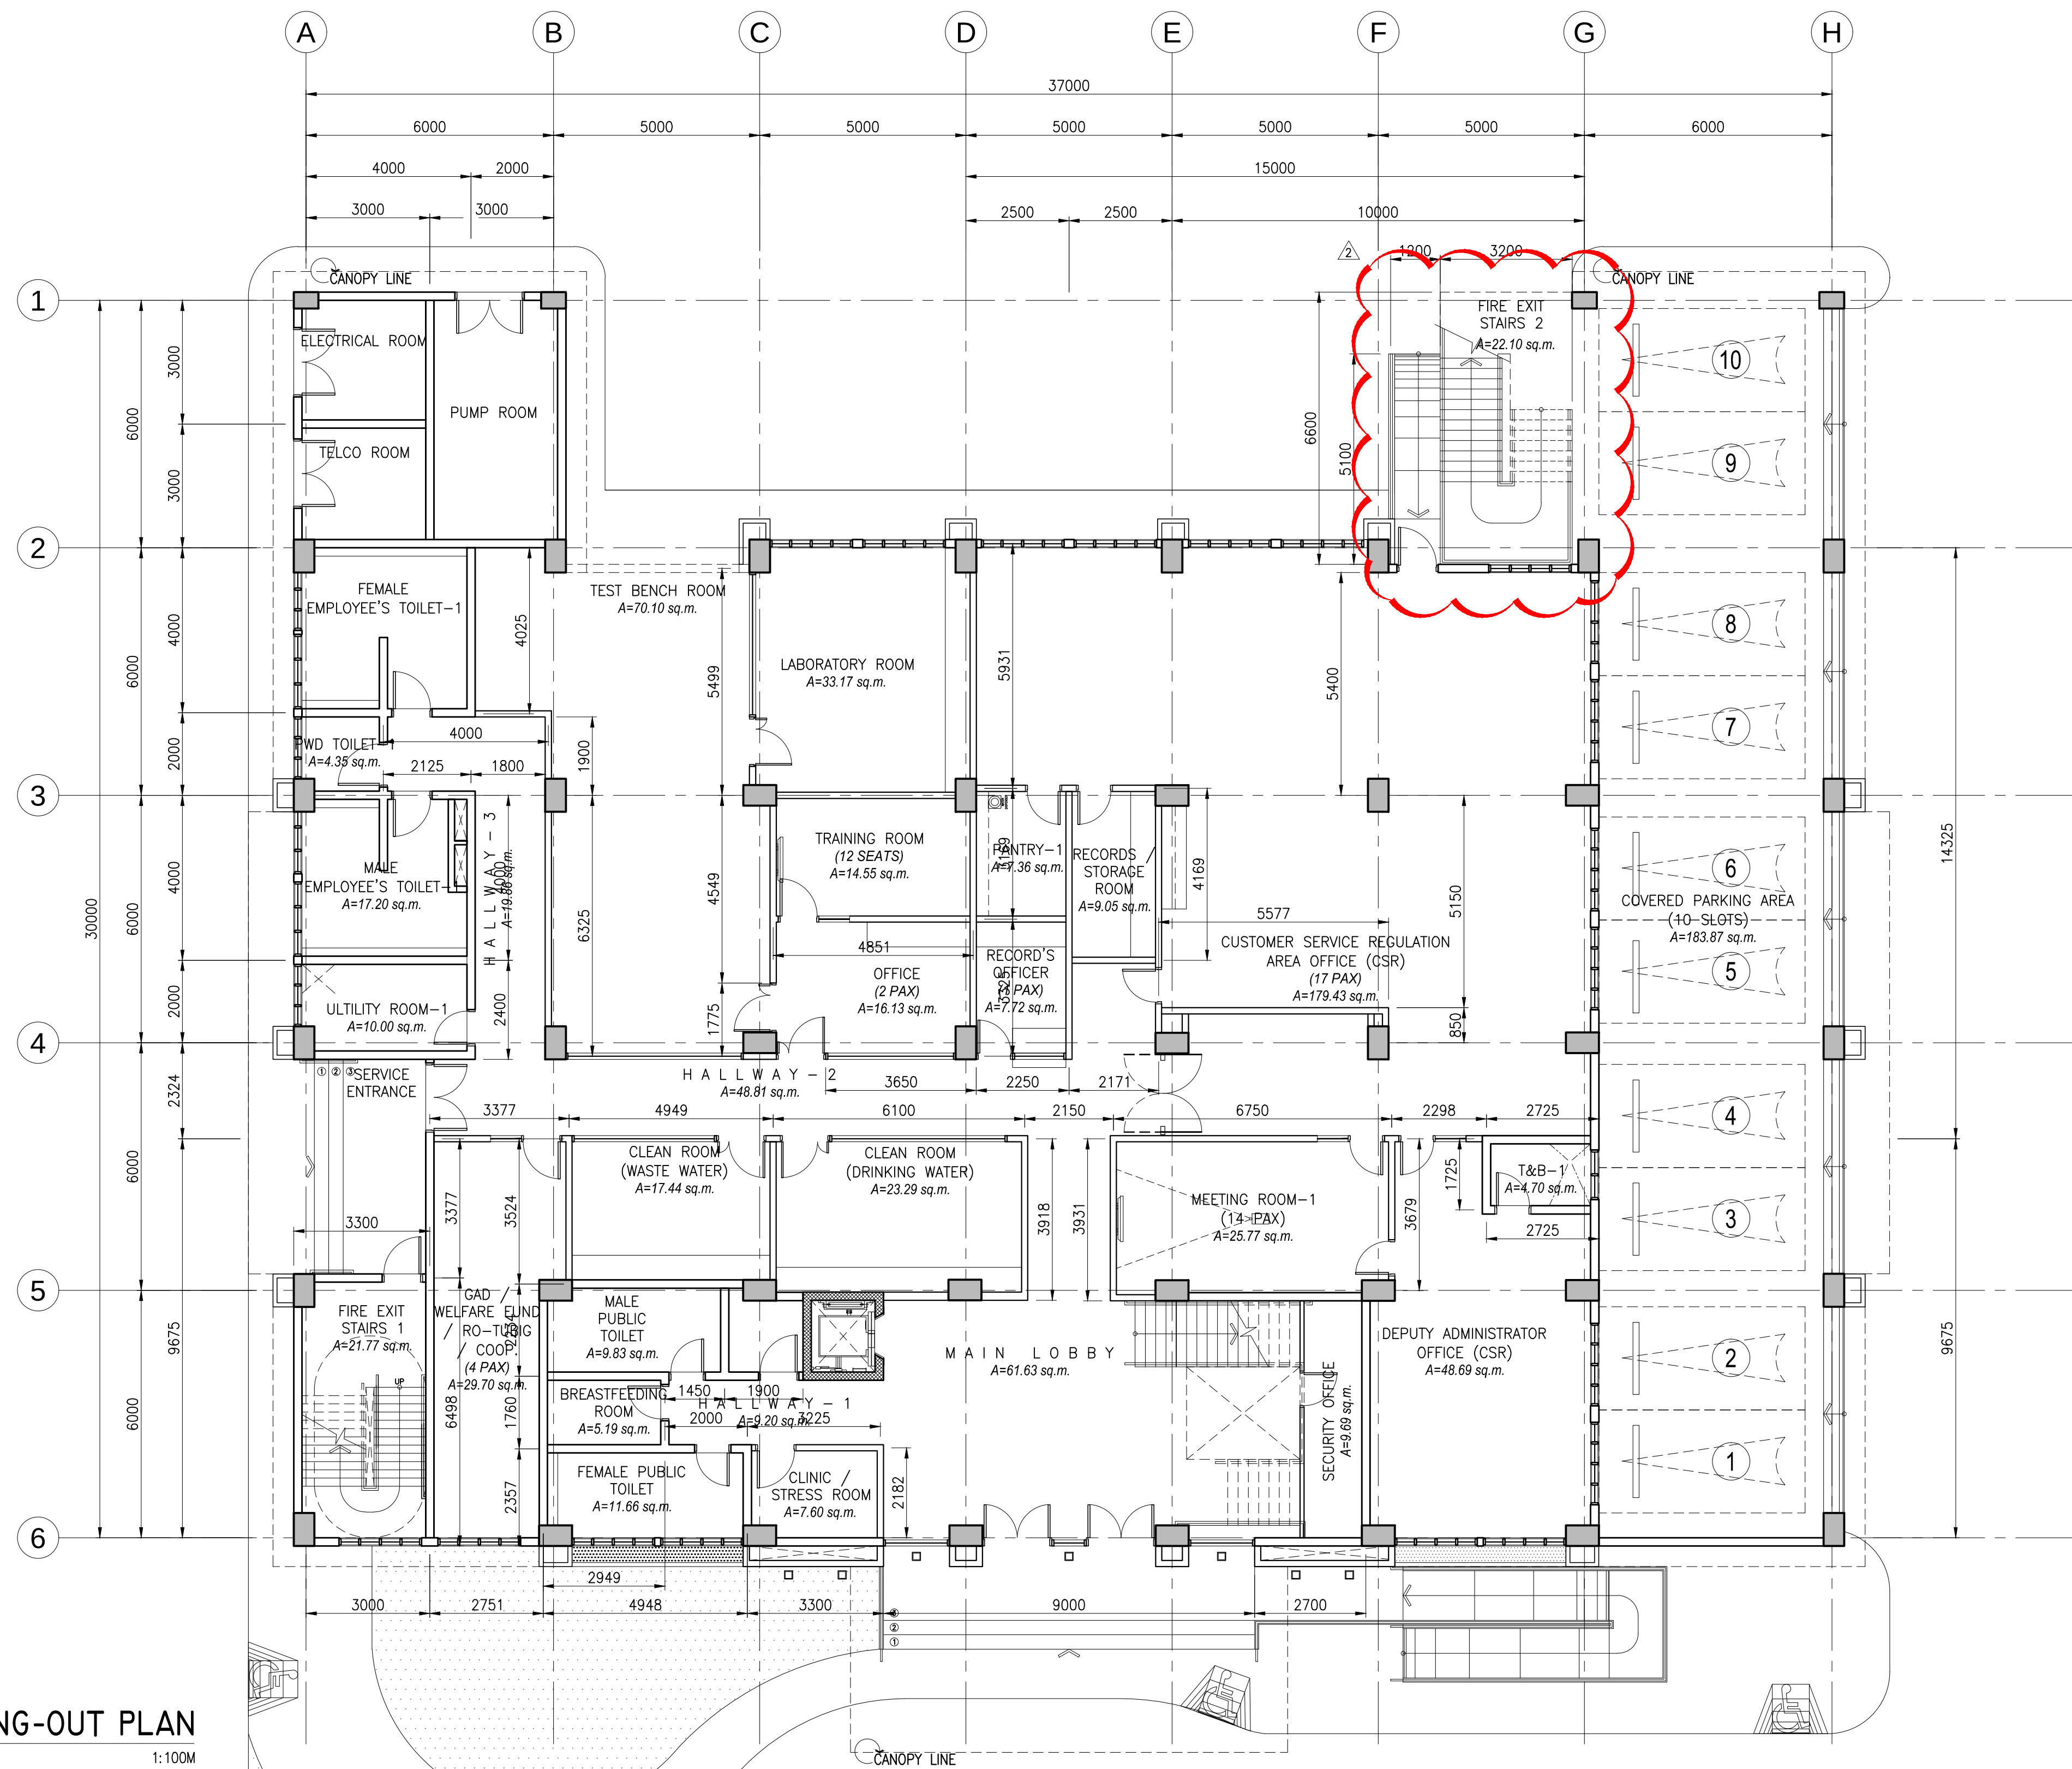


I GROUND FLOOR SETTING-OUT PLAN
A-141 SCALE 1:100M

CERTIFIED BY		OWNER	PROJECT TITLE/LOCATION	CLIENT	SHEET CONTENTS	R.A. 9266 SEC. 33 DRAWINGS AND SPECIFICATIONS AND CONTRACT DOCUMENTS DULY SIGNED, STAMPED OR SEALED AS INSTRUMENTS FOR SERVICE ARE THE INTELLECTUAL PROPERTY AND DOCUMENTS OF ARCHITECT, WHETHER THE OBJECT FOR WHICH THEY ARE MADE IS EXECUTED OR NOT. IT SHALL BE UNLAWFUL FOR ANY PERSON TO DUPLICATE OR TO MAKE COPIES OF SAID DOCUMENTS FOR USE IN THE REPETITION OF AND FOR OTHER PROJECTS OR BUILDINGS, WHETHER EXECUTED PARTLY OR IN WHOLE, WITHOUT THE WRITTEN CONSENT OF THE ARCHITECT OR AUTHOR OF SAID DOCUMENTS.	CADD	DATE	NO.	REVISIONS	CHK	DATE	PAPER SIZE	SHEET NO.
MICHELANGELA O. SALVADOR, UAP		METROPOLITAN WATERWORKS AND SEWERAGE SYSTEM REGULATORY OFFICE	3-STOREY OFFICE BUILDING WITH ROOF DECK	PROJECT PROPONENT	GROUND FLOOR SETTING-OUT PLAN		GMT/NBR/SC/	JUL 2018					20X30	A-141
ARCHITECT				APPROVED BY:			DESIGNED	DATE					SCALE	PROJECT NO.
							JDEC	JUL 2018					AS SHOWN	SO-G-17-036
REG. NO.: 0021601 IAPOA : 17156228123072318 TIN NO. : 271-680-669-000 PTR NO. : 6679972 DATE : 2/8/2018 PLACE : MAKATI CITY		MWSS COMPOUND, KATIPUNAN AVENUE, MATANDANG BALARA, QUEZON CITY	MWSS COMPOUND, KATIPUNAN AVENUE, MATANDANG BALARA, QUEZON CITY	MELCHOR S. CORDOVA ALTERNATE END-USER FOR RO BUILDING	PATRICK LESTER N. TY CHIEF REGULATOR, MWSS RO		APPROVED	DATE	1	ADDITIONAL FIRE EXIT STAIRS	10-30-2018			
							MOS	JUL 2018		SCHEMATIC DESIGN	03-09-2018			

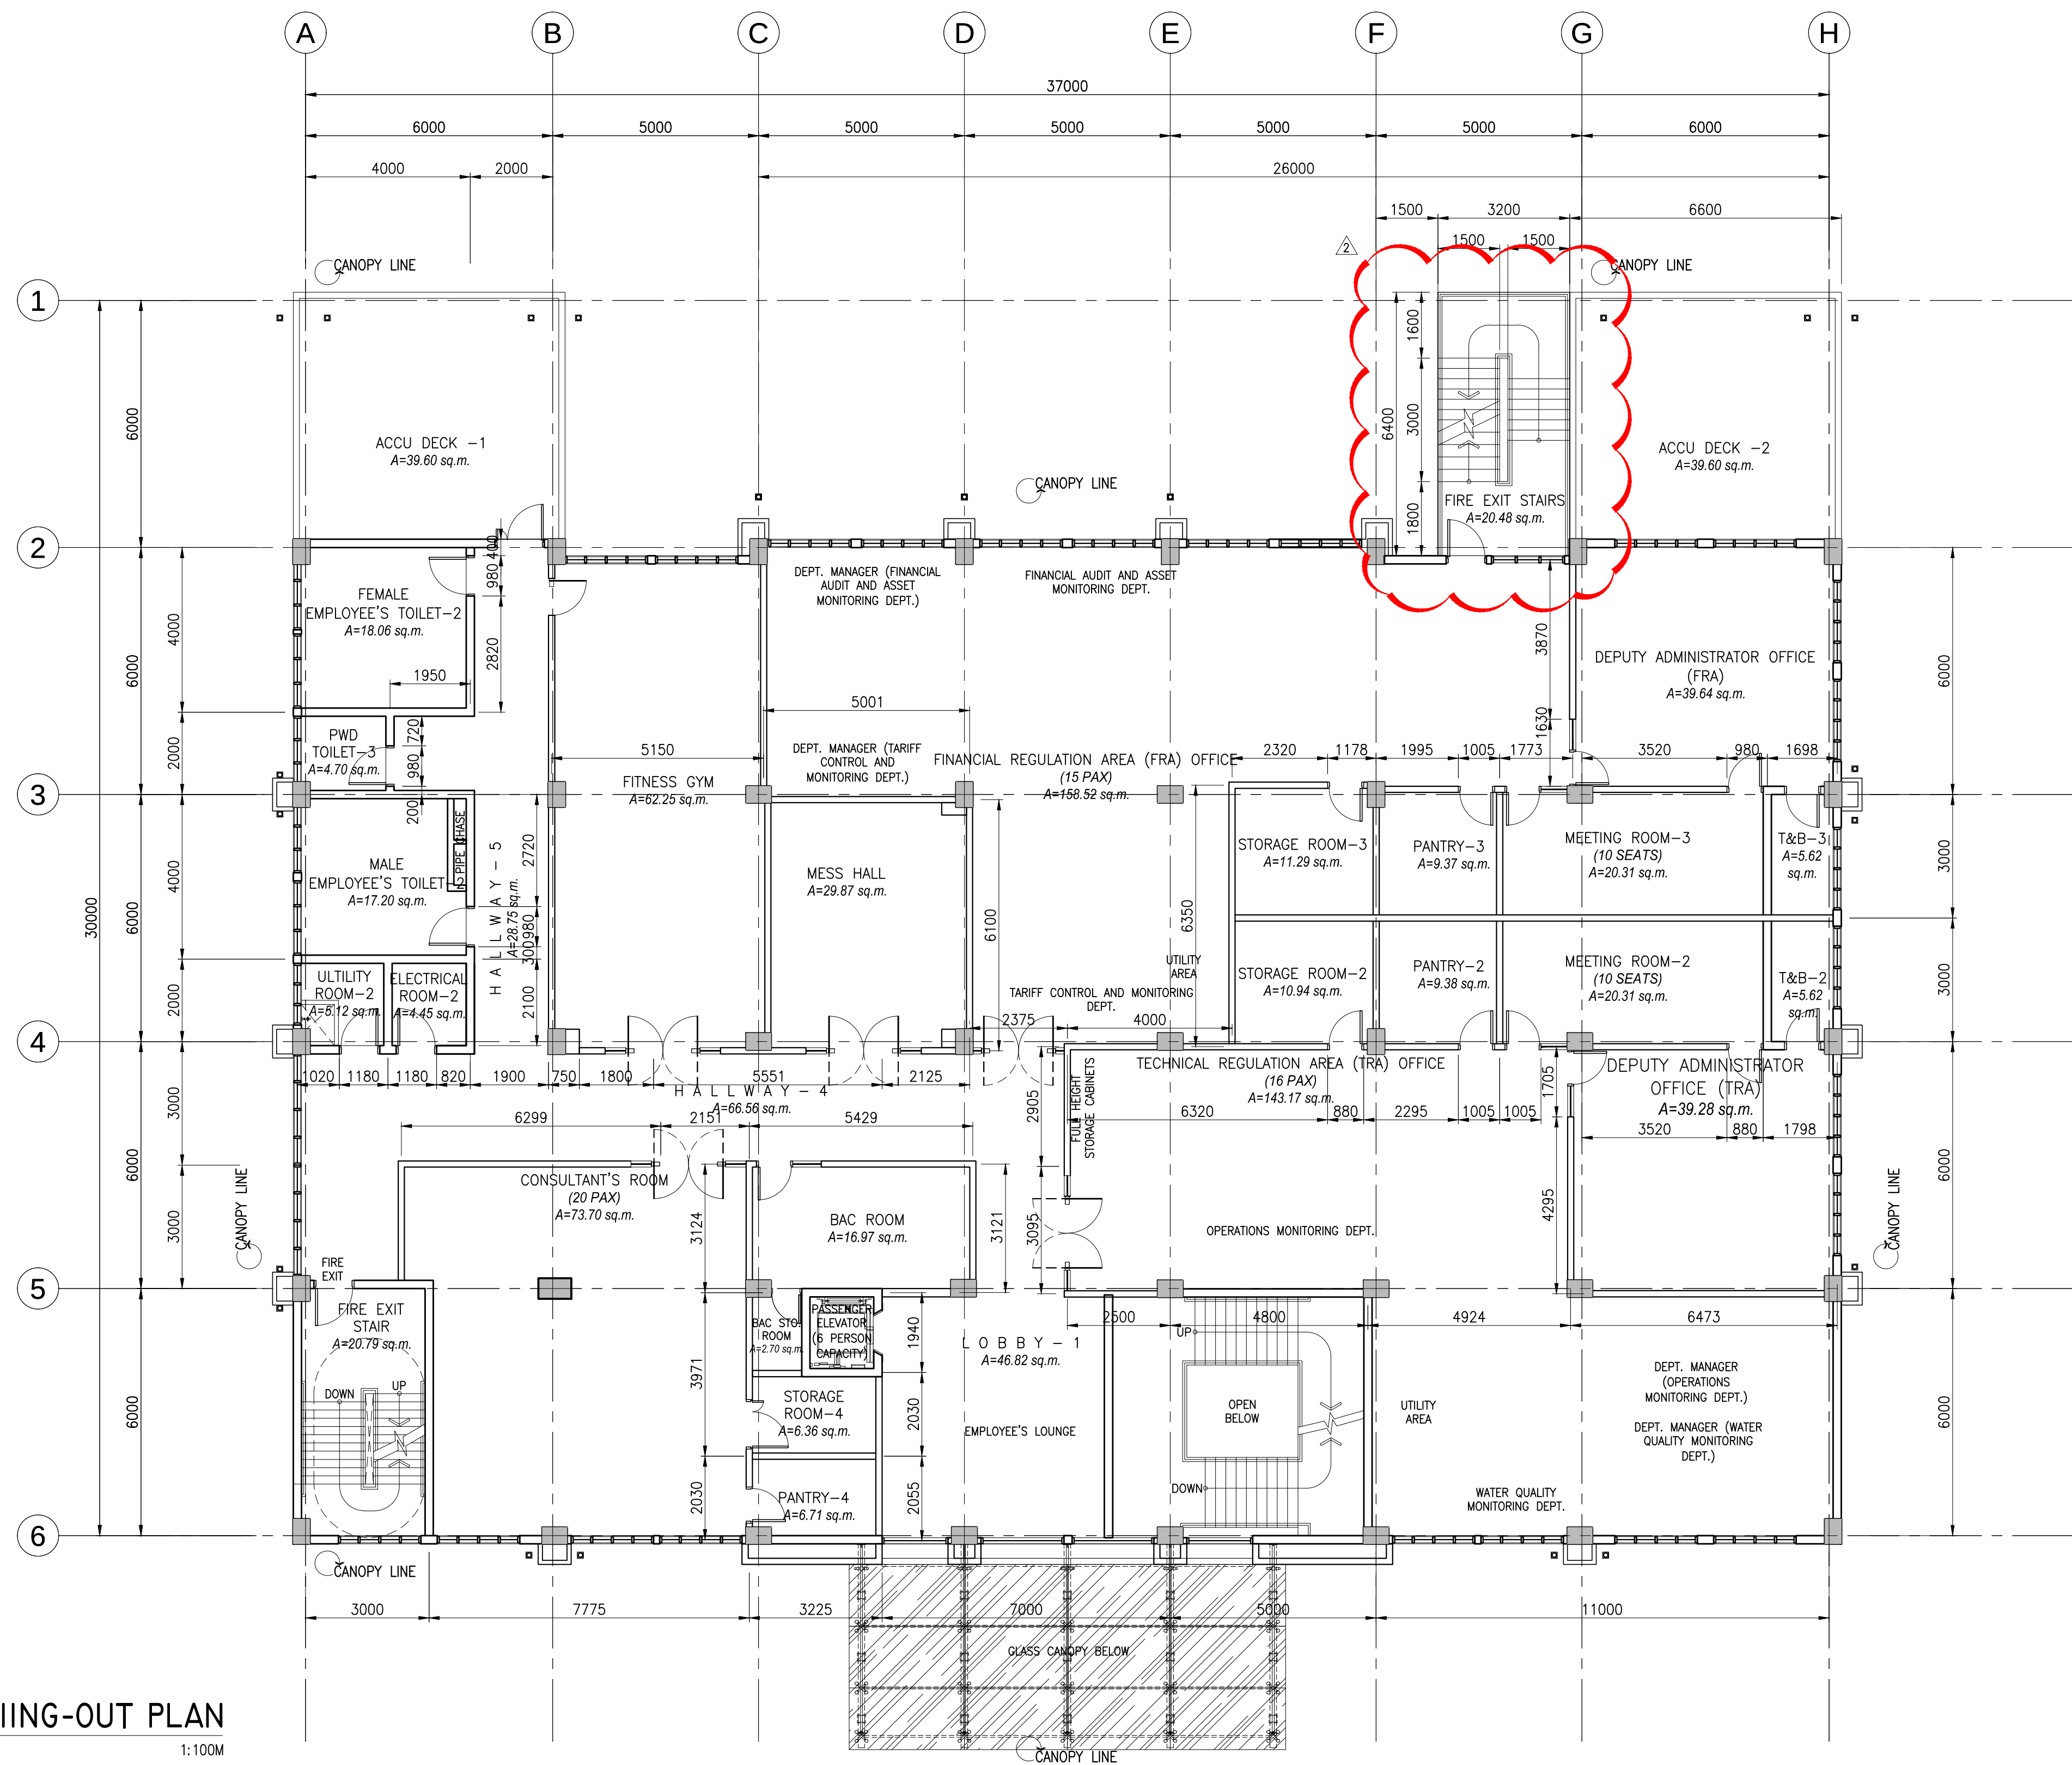


I SECOND FLOOR SETIING-OUT PLAN
A-142 SCALE 1:100M

CERTIFIED BY MICHELANGELA O. SALVADOR, UAP ARCHITECT	REG. NO.: 0021601 IAPOA : 17156228123072318 TIN NO. : 271-680-669-000 PTR NO. : 6679972 DATE : 2/8/2018 PLACE : MAKATI CITY	OWNER METROPOLITAN WATERWORKS AND SEWERAGE SYSTEM REGULATORY OFFICE MWSS COMPOUND, KATIPUNAN AVENUE, MATANDANG BALARA, QUEZON CITY	PROJECT TITLE/LOCATION 3-STOREY OFFICE BUILDING WITH ROOF DECK MWSS COMPOUND, KATIPUNAN AVENUE, MATANDANG BALARA, QUEZON CITY	CLIENT PROJECT PROPONENT MELCHOR S. CORDOVA ALTERNATE END-USER FOR RO BUILDING	APPROVED BY: PATRICK LESTER N. TY CHIEF REGULATOR, MWSS RO	SHEET CONTENTS SECOND FLOOR SETIING-OUT PLAN	R.A. 9266 SEC. 33 DRAWINGS AND SPECIFICATIONS AND CONTRACT DOCUMENTS DULY SIGNED, STAMPED OR SEALED AS INSTRUMENTS FOR SERVICE ARE THE INTELLECTUAL PROPERTY AND DOCUMENTS OF ARCHITECT, WHETHER THE OBJECT FOR WHICH THEY ARE MADE IS EXECUTED OR NOT. IT SHALL BE UNLAWFUL FOR ANY PERSON TO DUPLICATE OR TO MAKE COPIES OF SAID DOCUMENTS FOR USE IN THE REPETITION OF AND FOR OTHER PROJECTS OR BUILDINGS, WHETHER EXECUTED PARTLY OR IN WHOLE, WITHOUT THE WRITTEN CONSENT OF THE ARCHITECT OR AUTHOR OF SAID DOCUMENTS.	CADD	DATE	NO.	REVISIONS	CHK	DATE	PAPER SIZE	SHEET NO.
								GMT/NBR/SC/	JUL 2018					20X30	A-142
								DESIGNED	DATE					SCALE	PROJECT NO.
								JDEC	JUL 2018						
APPROVED	DATE														
MOS	JUL 2018													AS SHOWN	SO-G-17-036

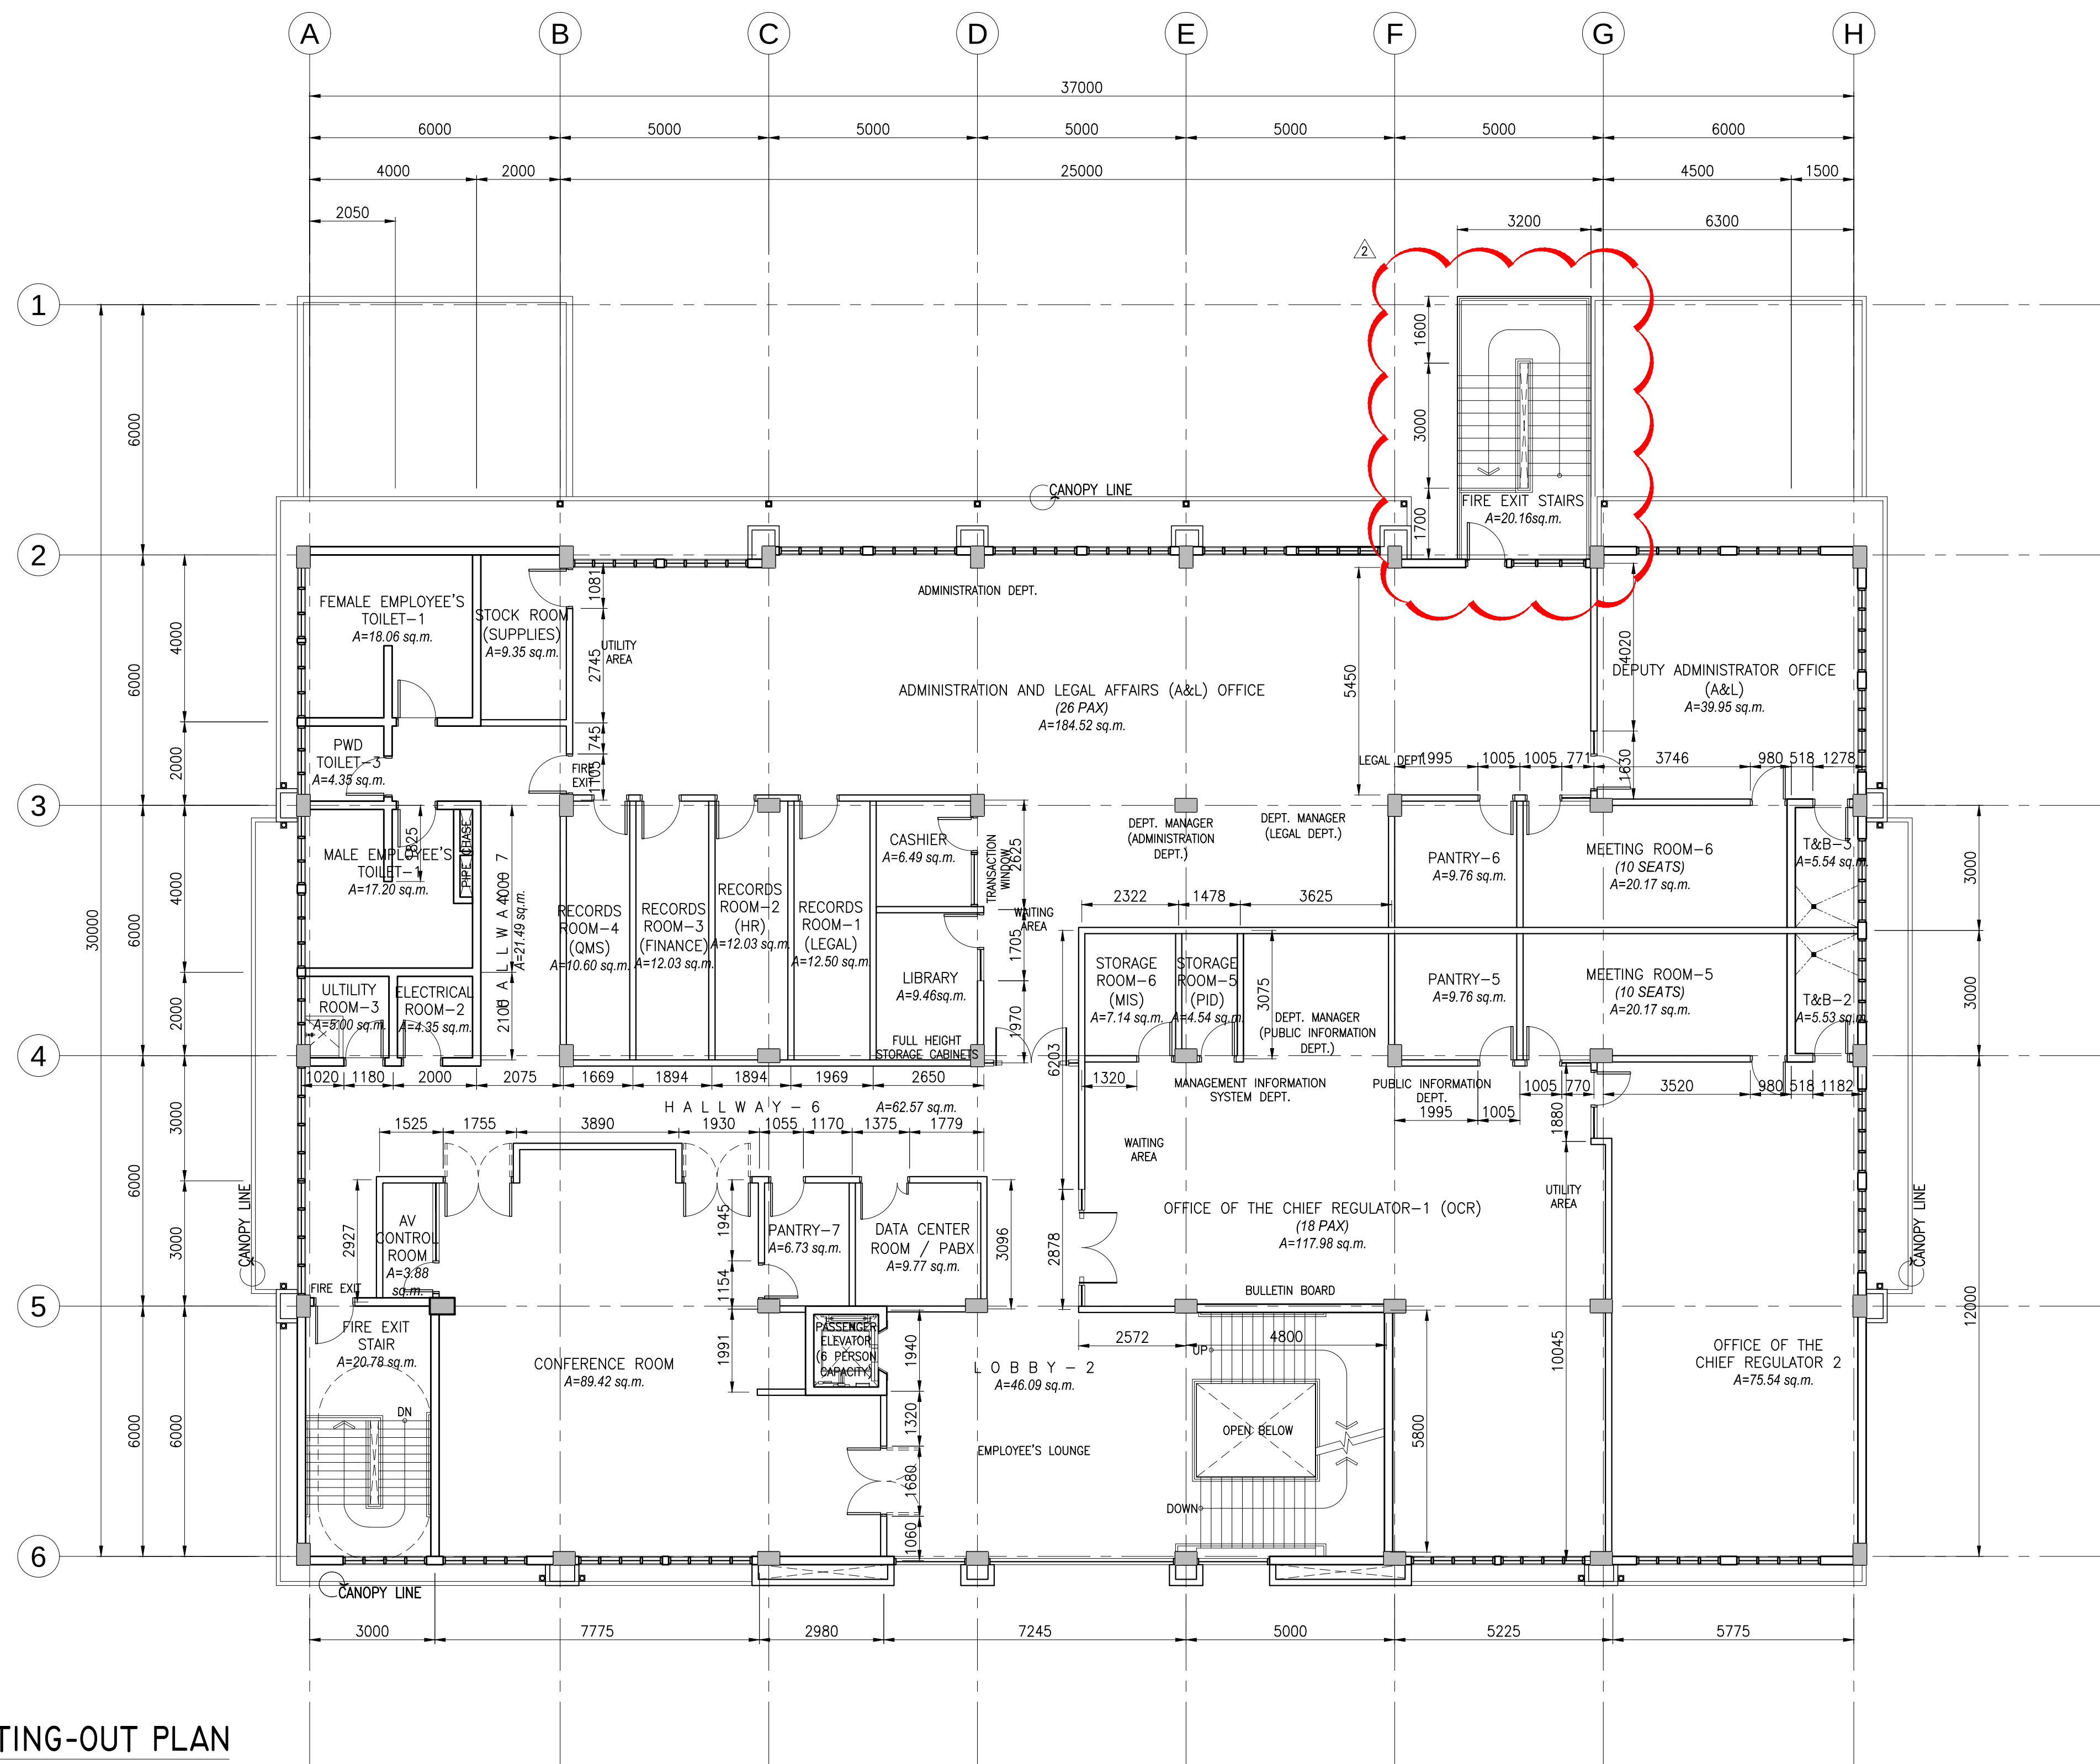

I THIRD FLOOR SETTING-OUT PLAN
A-143 SCALE 1:100M

CERTIFIED BY		OWNER	PROJECT TITLE/LOCATION	CLIENT	SHEET CONTENTS	R.A. 9266 SEC. 33 DRAWINGS AND SPECIFICATIONS AND CONTRACT DOCUMENTS DULY SIGNED, STAMPED OR SEALED AS INSTRUMENTS FOR SERVICE ARE THE INTELLECTUAL PROPERTY AND DOCUMENTS OF ARCHITECT, WHETHER THE OBJECT FOR WHICH THEY ARE MADE IS EXECUTED OR NOT. IT SHALL BE UNLAWFUL FOR ANY PERSON TO DUPLICATE OR TO MAKE COPIES OF SAID DOCUMENTS FOR USE IN THE REPETITION OF AND FOR OTHER PROJECTS OR BUILDINGS, WITHOUT THE WRITTEN CONSENT OF THE ARCHITECT OR AUTHOR OF SAID DOCUMENTS.	CADD	DATE	NO.	REVISIONS	CHK	DATE	PAPER SIZE	SHEET NO.
MICHELANGELA O. SALVADOR, UAP		METROPOLITAN WATERWORKS AND SEWERAGE SYSTEM REGULATORY OFFICE	3-STOREY OFFICE BUILDING WITH ROOF DECK	PROJECT PROPONENT	THIRD FLOOR SETTING-OUT PLAN		GMT/NBR/SC/	JUL 2018					20X30	A-143
ARCHITECT				APPROVED BY:			DESIGNED	DATE					SCALE	PROJECT NO.
				MELCHOR S. CORDOVA	PATRICK LESTER N. TY		JDEC	JUL 2018						
				ALTERNATE END-USER FOR RO BUILDING	CHIEF REGULATOR, MWSS RO		APPROVED	DATE	1	ADDITIONAL FIRE EXIT STAIRS		10-30-2018	AS SHOWN	SO-G-17-036
							MOS	JUL 2018		SCHEMATIC DESIGN		03-09-2018		

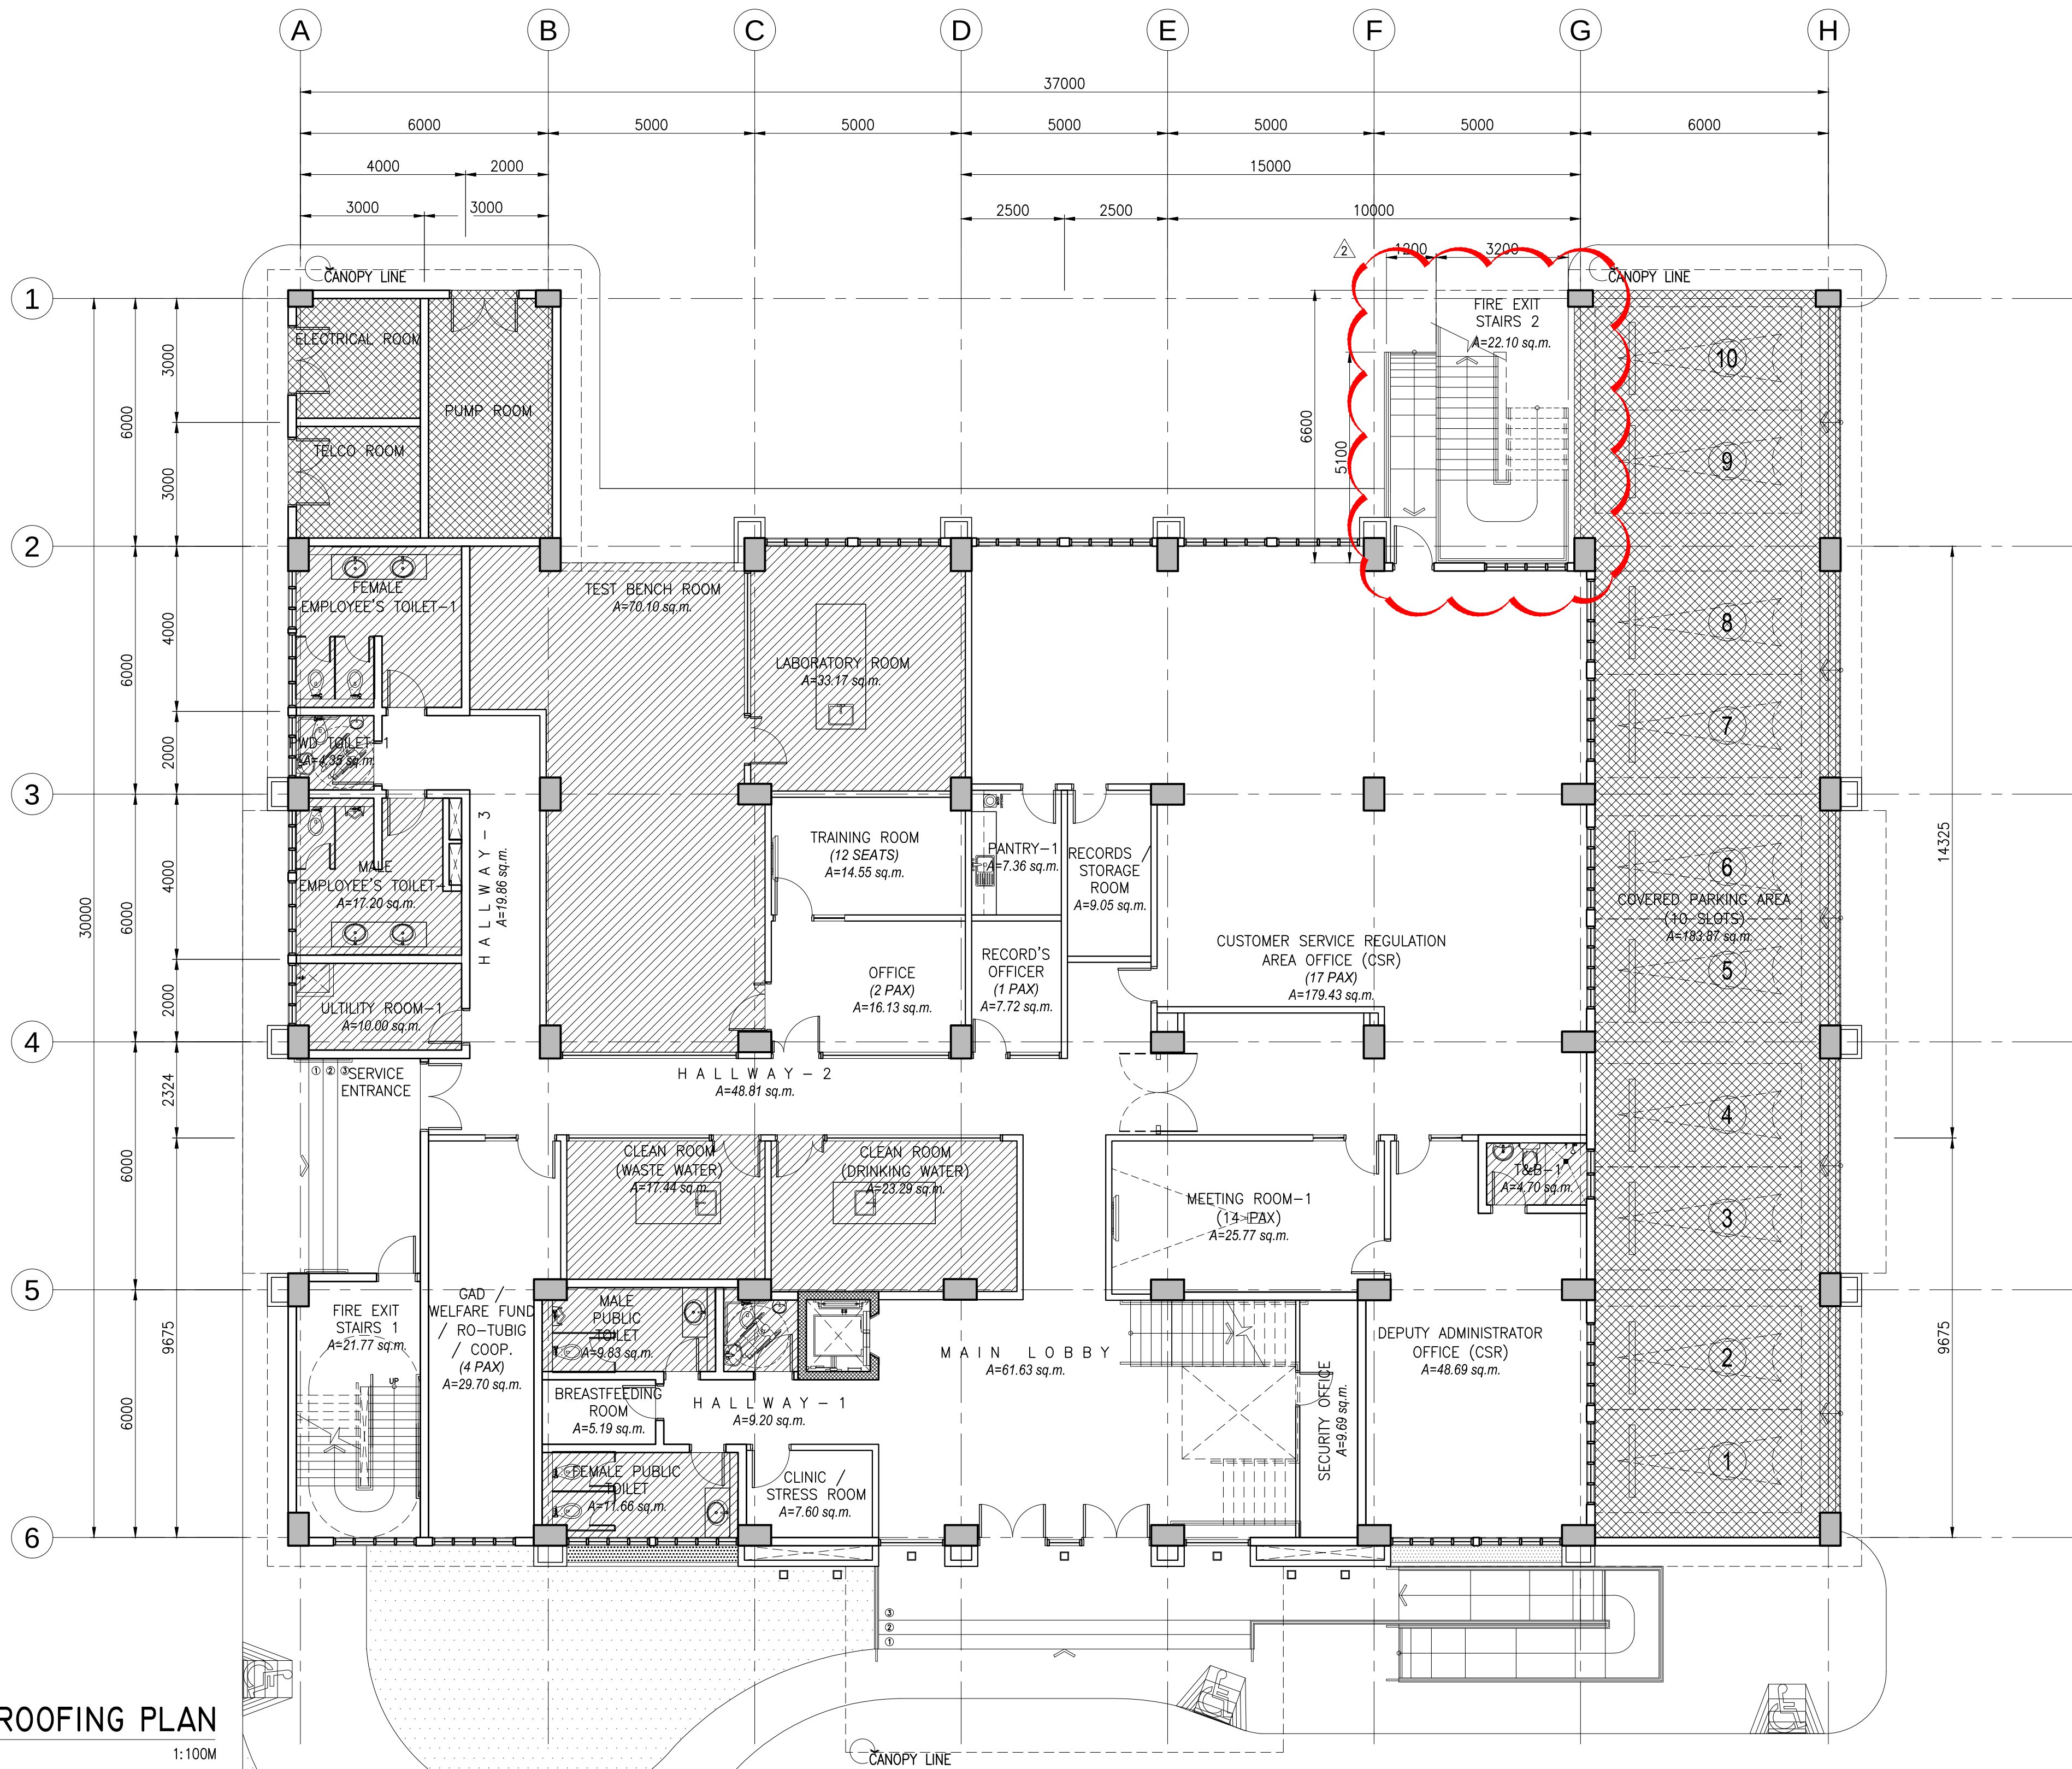

I
A-151

GROUND FLOOR WATERPROOFING PLAN

SCALE

1:100M

CERTIFIED BY

MICHELANGELA O. SALVADOR, UAP
ARCHITECT

REG. NO.: 0021601
IAPOA : 17156228123072318
TIN NO. : 271-680-669-000
PTR NO. : 6679972
DATE : 2/8/2018
PLACE : MAKATI CITY

OWNER

METROPOLITAN WATERWORKS
AND SEWERAGE SYSTEM
REGULATORY OFFICE

MWSS COMPOUND, KATIPUNAN AVENUE,
MATANGANG BALARA, QUEZON CITY

PROJECT TITLE/LOCATION

3-STOREY OFFICE BUILDING
WITH ROOF DECK

MWSS COMPOUND, KATIPUNAN AVENUE,
MATANGANG BALARA, QUEZON CITY

CLIENT

PROJECT PROONENT
MELCHOR S. CORDOVA
ALTERNATE END-USER FOR
RO BUILDING

APPROVED BY:

PATRICK LESTER N. TY
CHIEF REGULATOR, MWSS RO

SHEET CONTENTS

GROUND FLOOR WATERPROOFING PLAN

R.A. 9266 SEC. 33
DRAWINGS AND SPECIFICATIONS AND CONTRACT
DOCUMENTS DULY SIGNED, STAMPED OR SEALED
AS INSTRUMENTS FOR SERVICE ARE THE
INTELLECTUAL PROPERTY AND DOCUMENTS OF
ARCHITECT, WHETHER THE OBJECT FOR WHICH
THEY ARE MADE IS EXECUTED OR NOT. IT
SHALL BE UNLAWFUL, FOR ANY PERSON TO
DUPLICATE OR TO MAKE COPIES OF SAID
DOCUMENTS FOR USE IN THE REPETITION OF
AND FOR OTHER PROJECTS OR BUILDINGS,
WHETHER EXECUTED PARTLY OR IN WHOLE,
WITHOUT THE WRITTEN CONSENT OF THE
ARCHITECT OR AUTHOR OF SAID DOCUMENTS.

CADD

GMT/NBR/SCCH
DESIGNED
JDEC
APPROVED
MOS

DATE

JUL 2018
DATE
JUL 2018
DATE
JUL 2018

NO.

1

REVISIONS

ADDITIONAL FIRE EXIT STAIRS
SCHEMATIC DESIGN

CHK

10-30-2018
03-09-2018


DATE

PAPER SIZE

20X30
SCALE
AS SHOWN

SHEET NO.


A-151
PROJECT NO.
SO-G-17-036

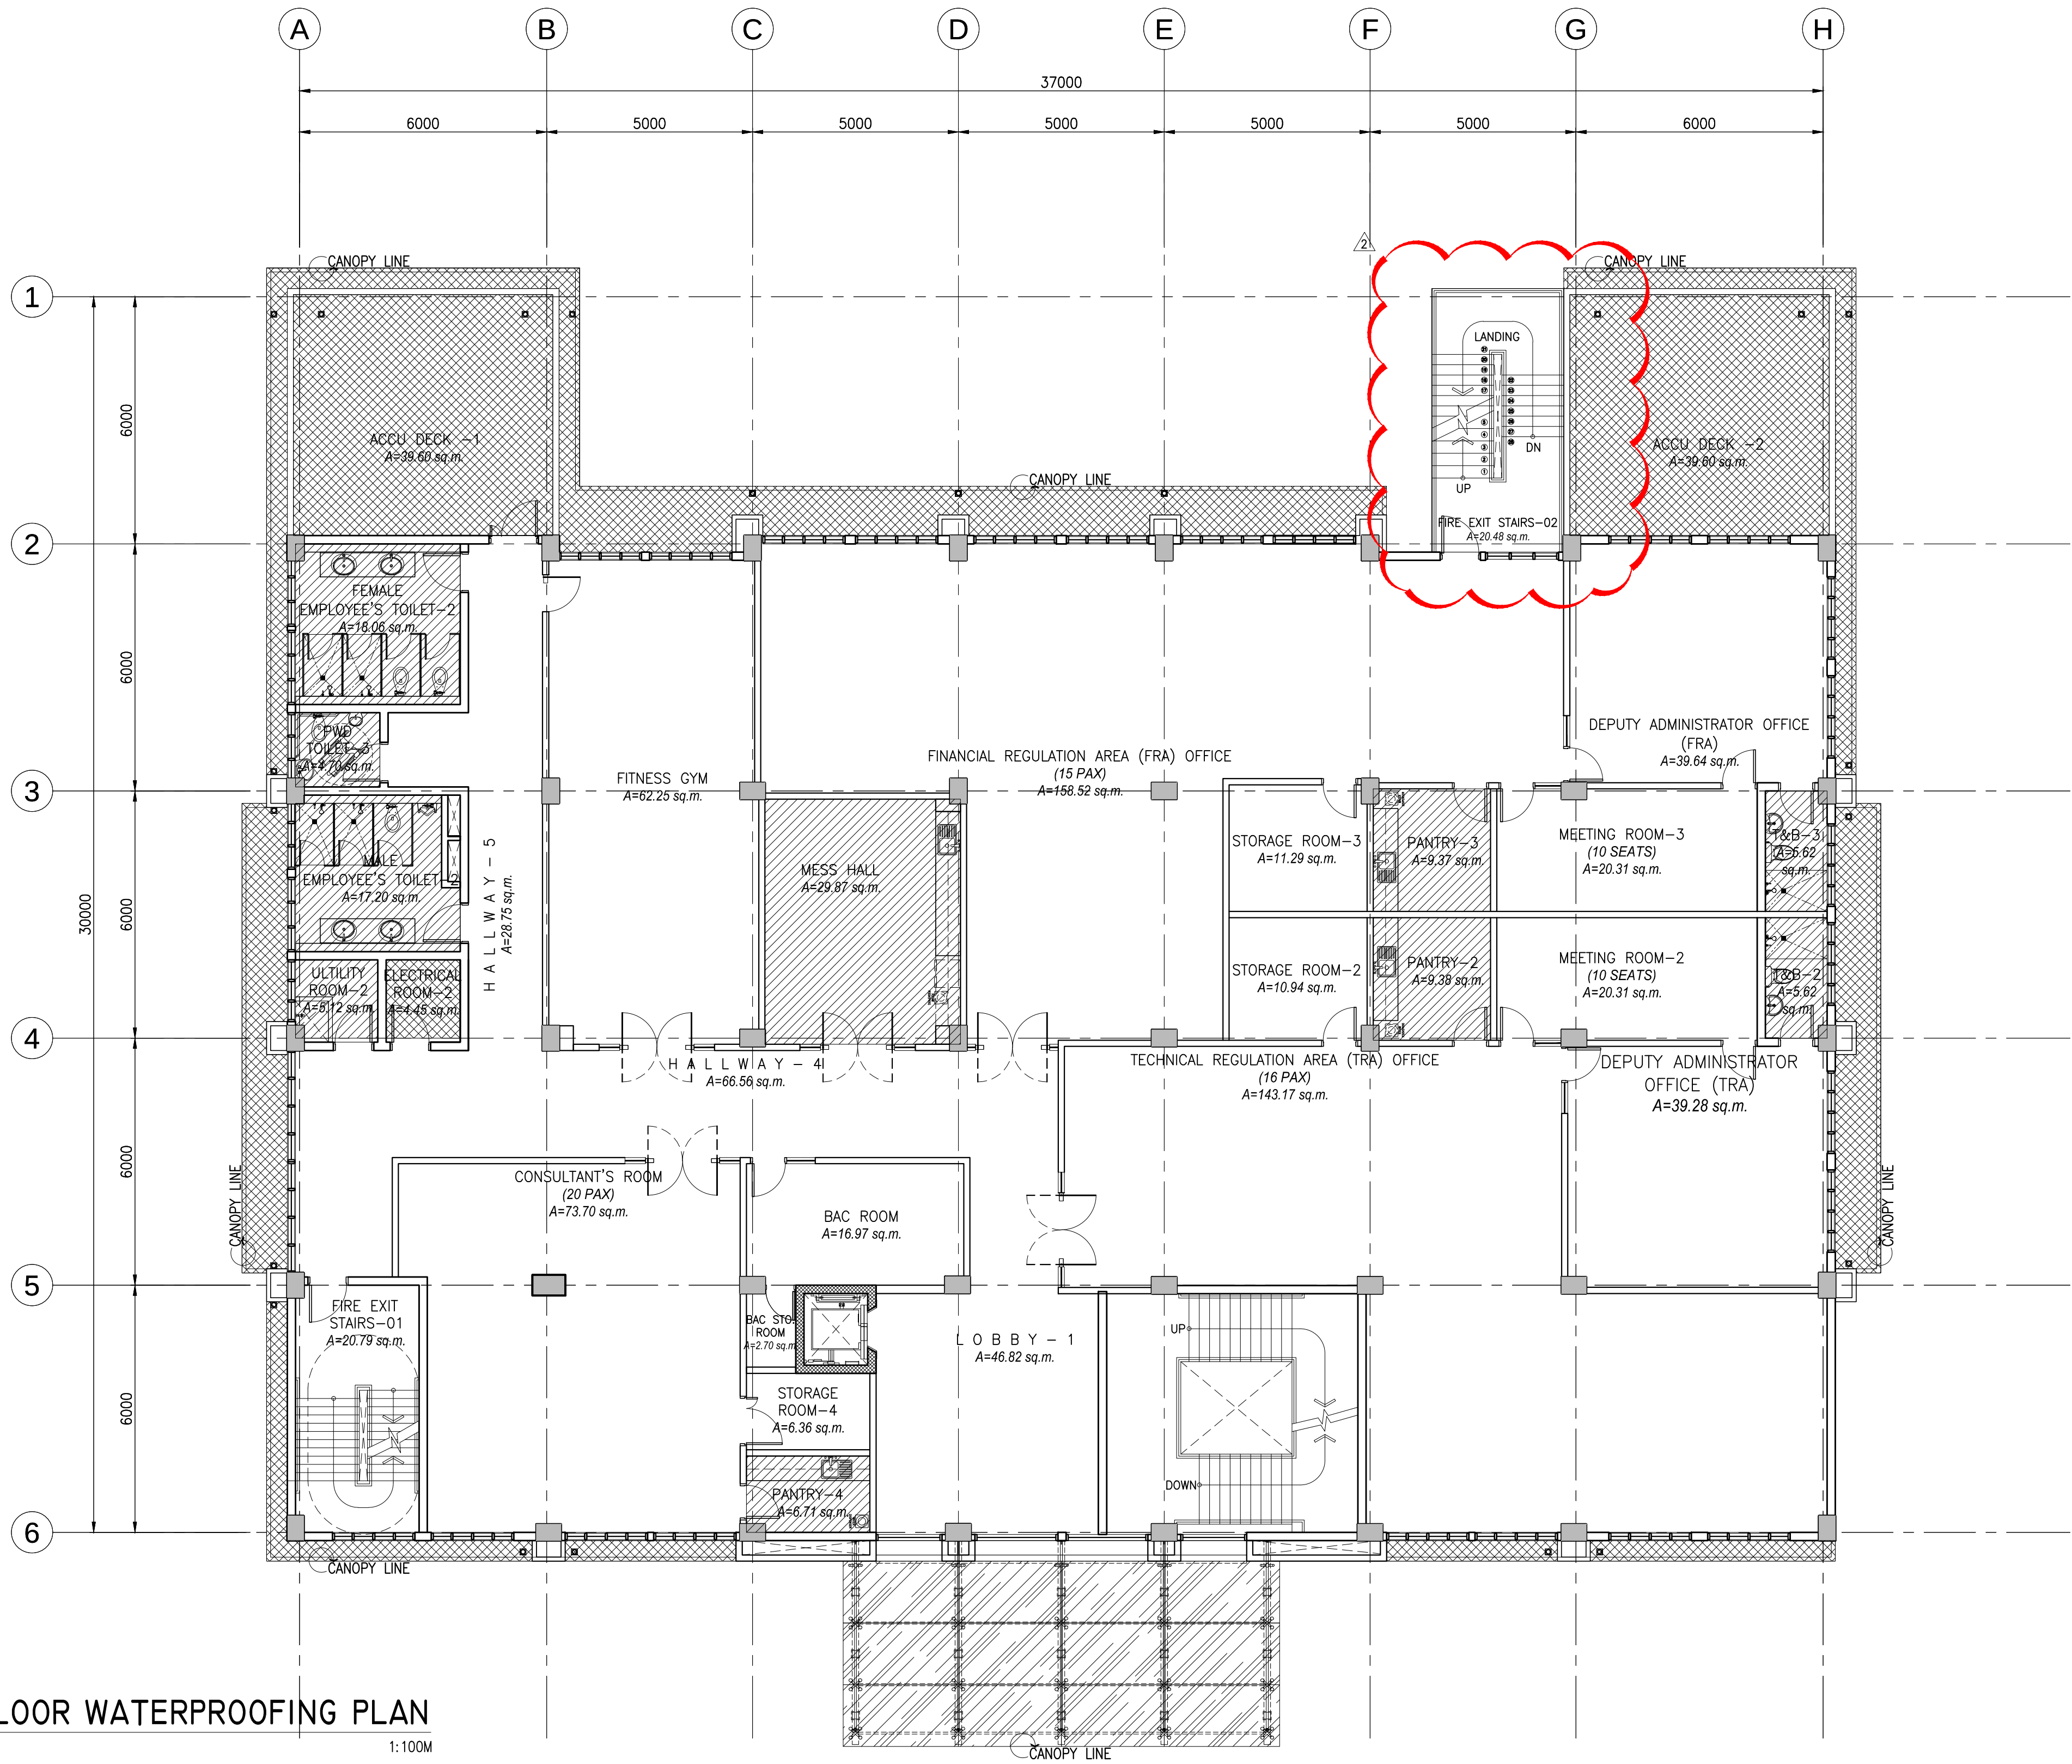

LEGEND	
	FLUID-APPLIED WATERPROOFING
	TRAFFICABLE LIQUID-APPLIED WATERPROOFING

I SECOND FLOOR WATERPROOFING PLAN
A-152 SCALE 1:100M


CERTIFIED BY		OWNER	PROJECT TITLE/LOCATION	CLIENT		SHEET CONTENTS	R.A. 9266 SEC. 33		CADD	DATE	NO.	REVISIONS	CHK	DATE	PAPER SIZE	SHEET NO.
MICHELANGELO O. SALVADOR, UAP ARCHITECT	REG. NO. : 0021601	METROPOLITAN WATERWORKS AND SEWERAGE SYSTEM REGULATORY OFFICE	3-STOREY OFFICE BUILDING WITH ROOF DECK	PROJECT PROPONENT	APPROVED BY:	SECOND FLOOR WATERPROOFING PLAN	DRAWINGS AND SPECIFICATIONS AND CONTRACT DOCUMENTS DULY SIGNED, STAMPED OR SEALED AS INSTRUMENTS FOR SERVICE ARE THE INTELLECTUAL PROPERTY AND DOCUMENTS OF ARCHITECT, WHETHER THE OBJECT FOR WHICH THEY ARE MADE IS EXECUTED OR NOT. IT SHALL BE UNLAWFUL FOR ANY PERSON TO DUPLICATE OR TO MAKE COPIES OF SAID DOCUMENTS FOR USE IN THE REPETITION OF AND FOR OTHER PROJECTS OR BUILDINGS, WHETHER EXECUTED PARTLY OR IN WHOLE, WITHOUT THE WRITTEN CONSENT OF THE ARCHITECT OR AUTHOR OF SAID DOCUMENTS.	GMT/NBR/SCDH	JUL 2018						20X30	A-152
	DESIGNED							DATE								
	JDEC							JUL 2018								
	APPROVED	DATE		ADDITIONAL FIRE EXIT STAIRS	10-30-2018			AS SHOWN	SO-G-17-036							
	TIN NO. : 271-680-669-000															
	PTR NO. : 6679972															
	DATE : 2/8/2018	MWSS COMPOUND, KATIPUNAN AVENUE, MATANGDANG BALARA, QUEZON CITY	MWSS COMPOUND, KATIPUNAN AVENUE, MATANGDANG BALARA, QUEZON CITY	MELCHOR S. CORDOVA ALTERNATE END-USER FOR RO BUILDING	PATRICK LESTER N. TY CHIEF REGULATOR, MWSS RO											
	PLACE : MAKATI CITY							MOS	JUL 2018	1	SCHEMATIC DESIGN			03-09-2018		

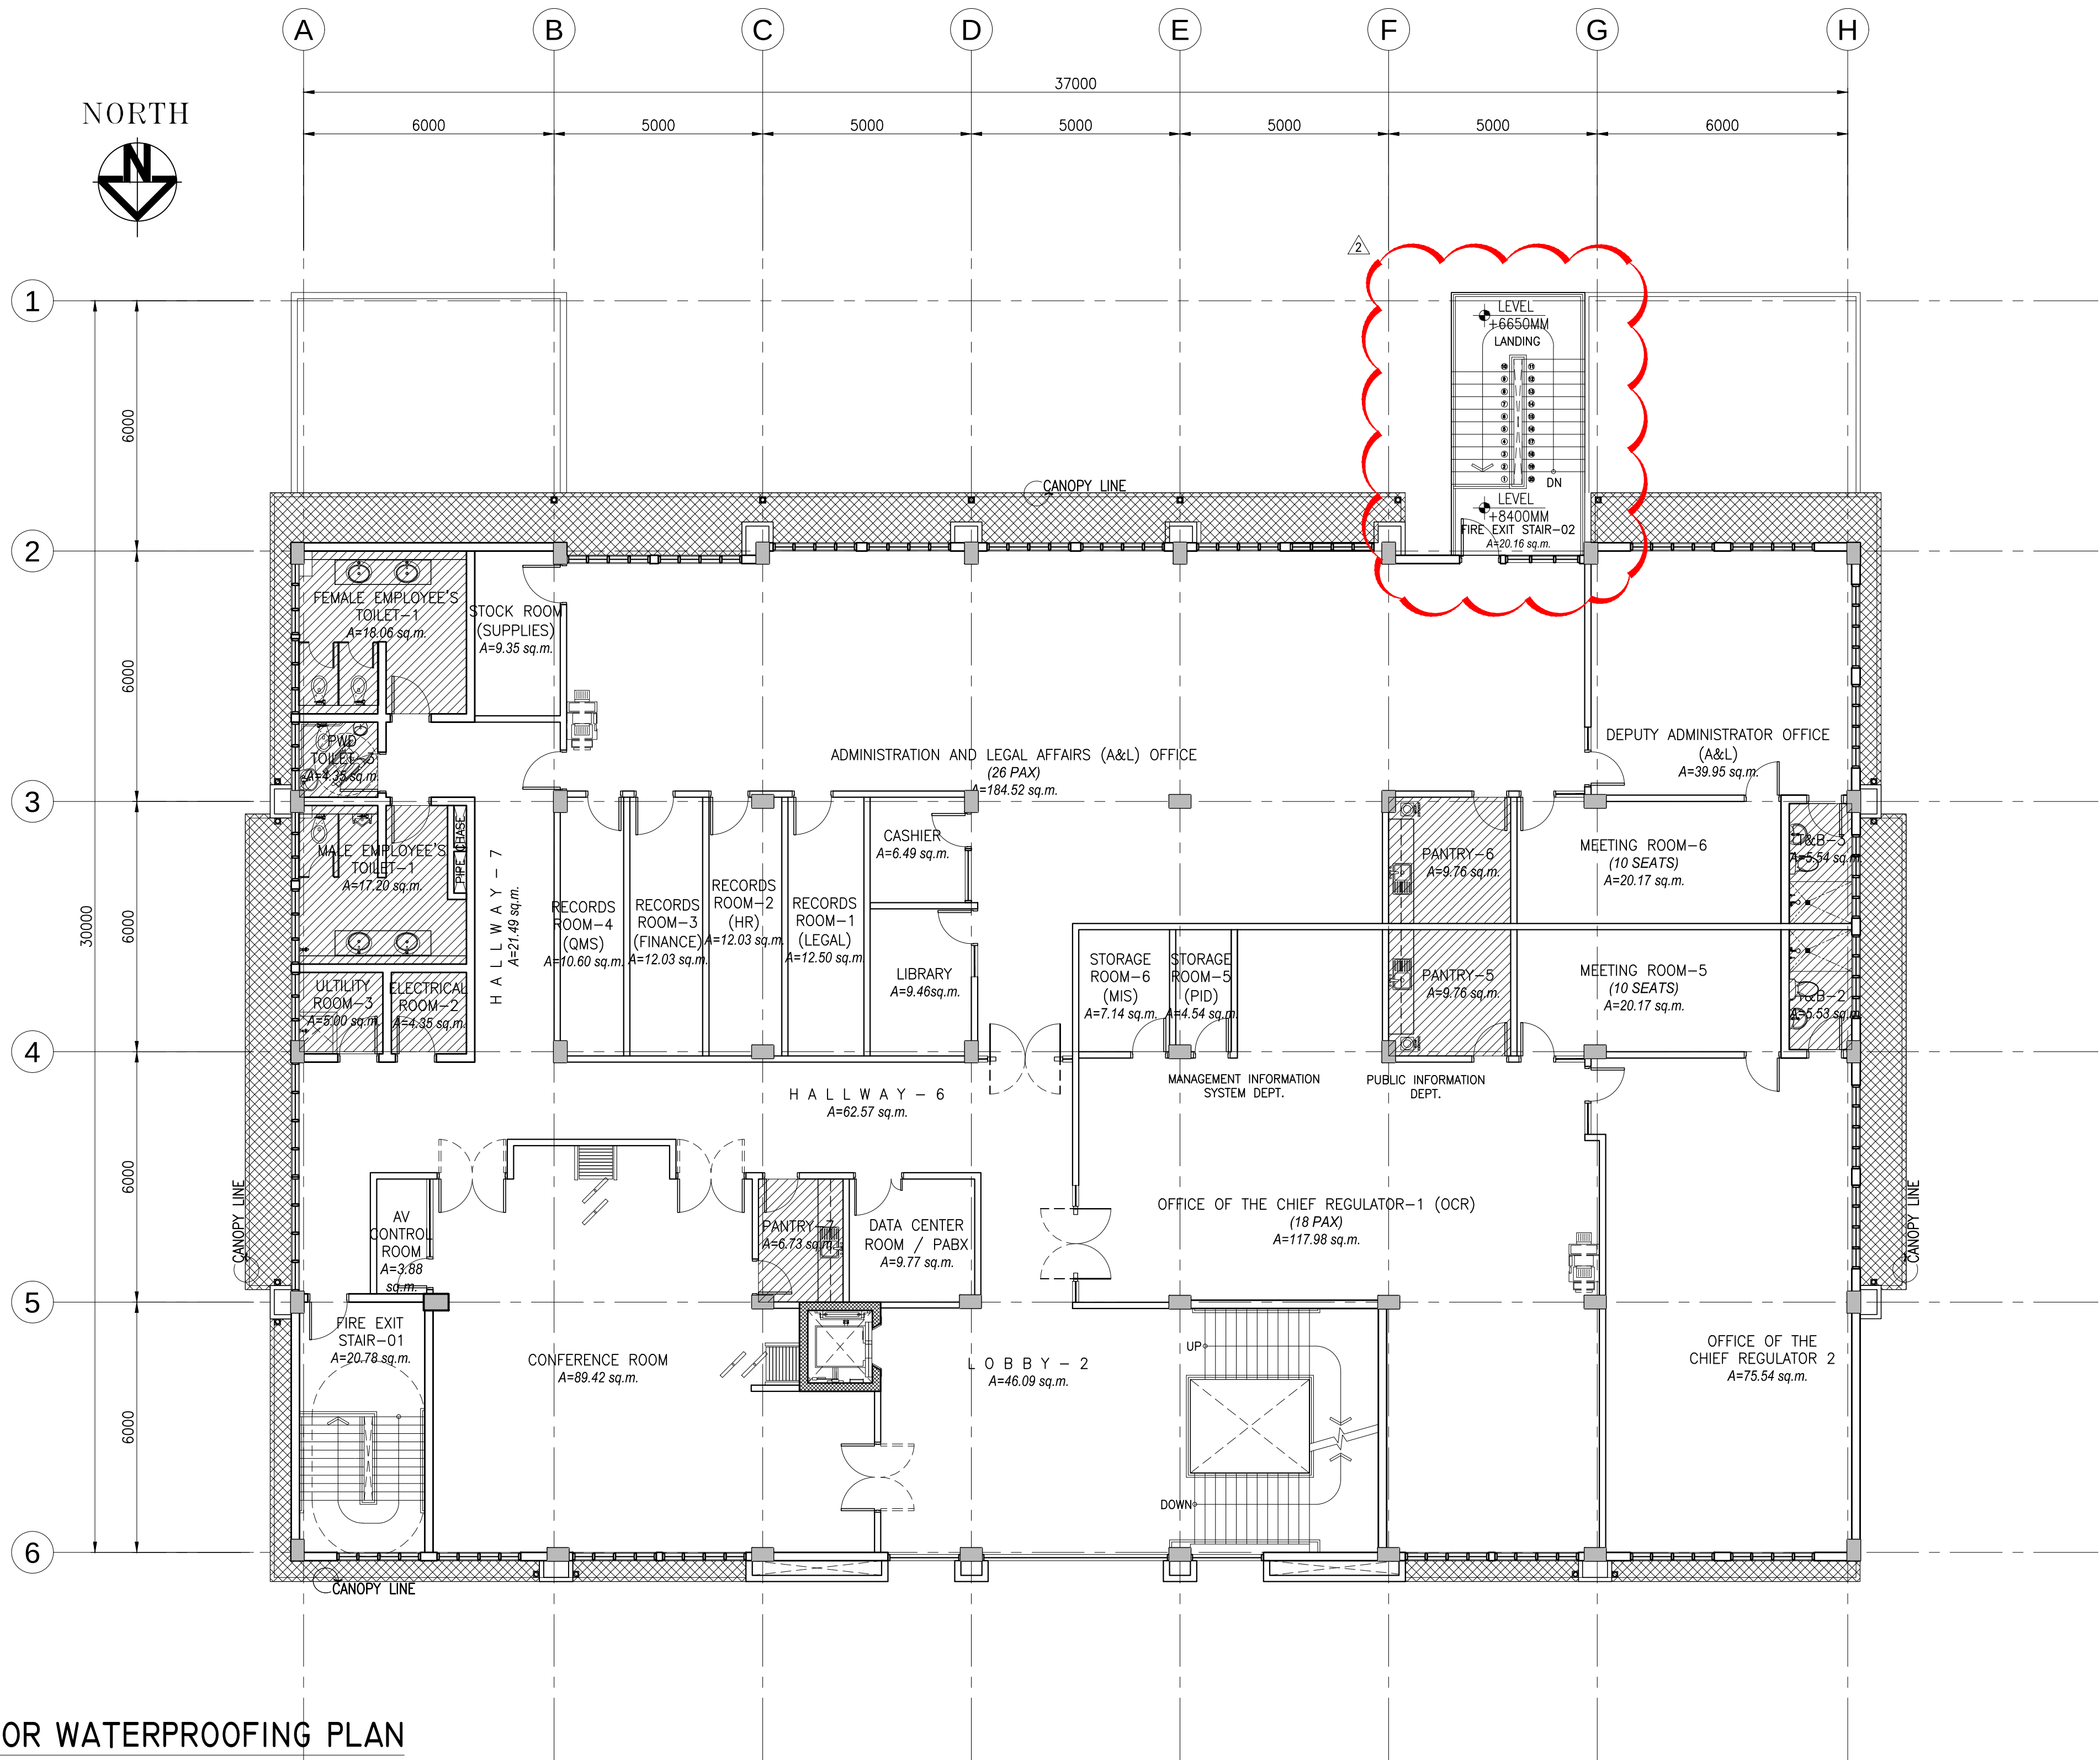

LEGEND	
	FLUID-APPLIED WATERPROOFING
	TRAFFICABLE LIQUID-APPLIED WATERPROOFING

I THIRD FLOOR WATERPROOFING PLAN
A-153 SCALE 1:100M


CERTIFIED BY		OWNER	PROJECT TITLE/LOCATION	CLIENT	SHEET CONTENTS	R.A. 9266 SEC. 33	CADD	DATE	NO.	REVISIONS	CHK	DATE	PAPER SIZE	SHEET NO.
MICHELANGELA O. SALVADOR, UAP ARCHITECT		METROPOLITAN WATERWORKS AND SEWERAGE SYSTEM REGULATORY OFFICE MWSS COMPOUND, KATIPUNAN AVENUE, MATandang BALARA, QUEZON CITY	3-STOREY OFFICE BUILDING WITH ROOF DECK MWSS COMPOUND, KATIPUNAN AVENUE, MATandang BALARA, QUEZON CITY	PROJECT PROPONENT MELCHOR S. CORDOVA ALTERNATE END-USER FOR RO BUILDING	APPROVED BY: PATRICK LESTER N. TY CHIEF REGULATOR, MWSS RO	DRAWINGS AND SPECIFICATIONS AND CONTRACT DOCUMENTS DULY SIGNED, STAMPED OR SEALED AS INSTRUMENTS FOR SERVICE ARE THE INTELLECTUAL PROPERTY AND DOCUMENTS OF ARCHITECT, WHETHER THE OBJECT FOR WHICH THEY ARE MADE IS EXECUTED OR NOT. IT SHALL BE UNLAWFUL, FOR ANY PERSON TO DUPLICATE OR TO MAKE COPIES OF SAID DOCUMENTS FOR USE IN THE REPETITION OF AND FOR OTHER PROJECTS OR BUILDINGS, WITHOUT THE WRITTEN CONSENT OF THE ARCHITECT OR AUTHOR OF SAID DOCUMENTS.	GMT/NBR/SC/	JUL 2018					20X30	A-153
							DESIGNED	DATE					SCALE	PROJECT NO.
							JDEC	JUL 2018						
							APPROVED	DATE		ADDITIONAL FIRE EXIT STAIRS		10-30-2018	AS SHOWN	SO-G-17-036
							MOS	JUL 2018	1	SCHEMATIC DESIGN		03-09-2018		

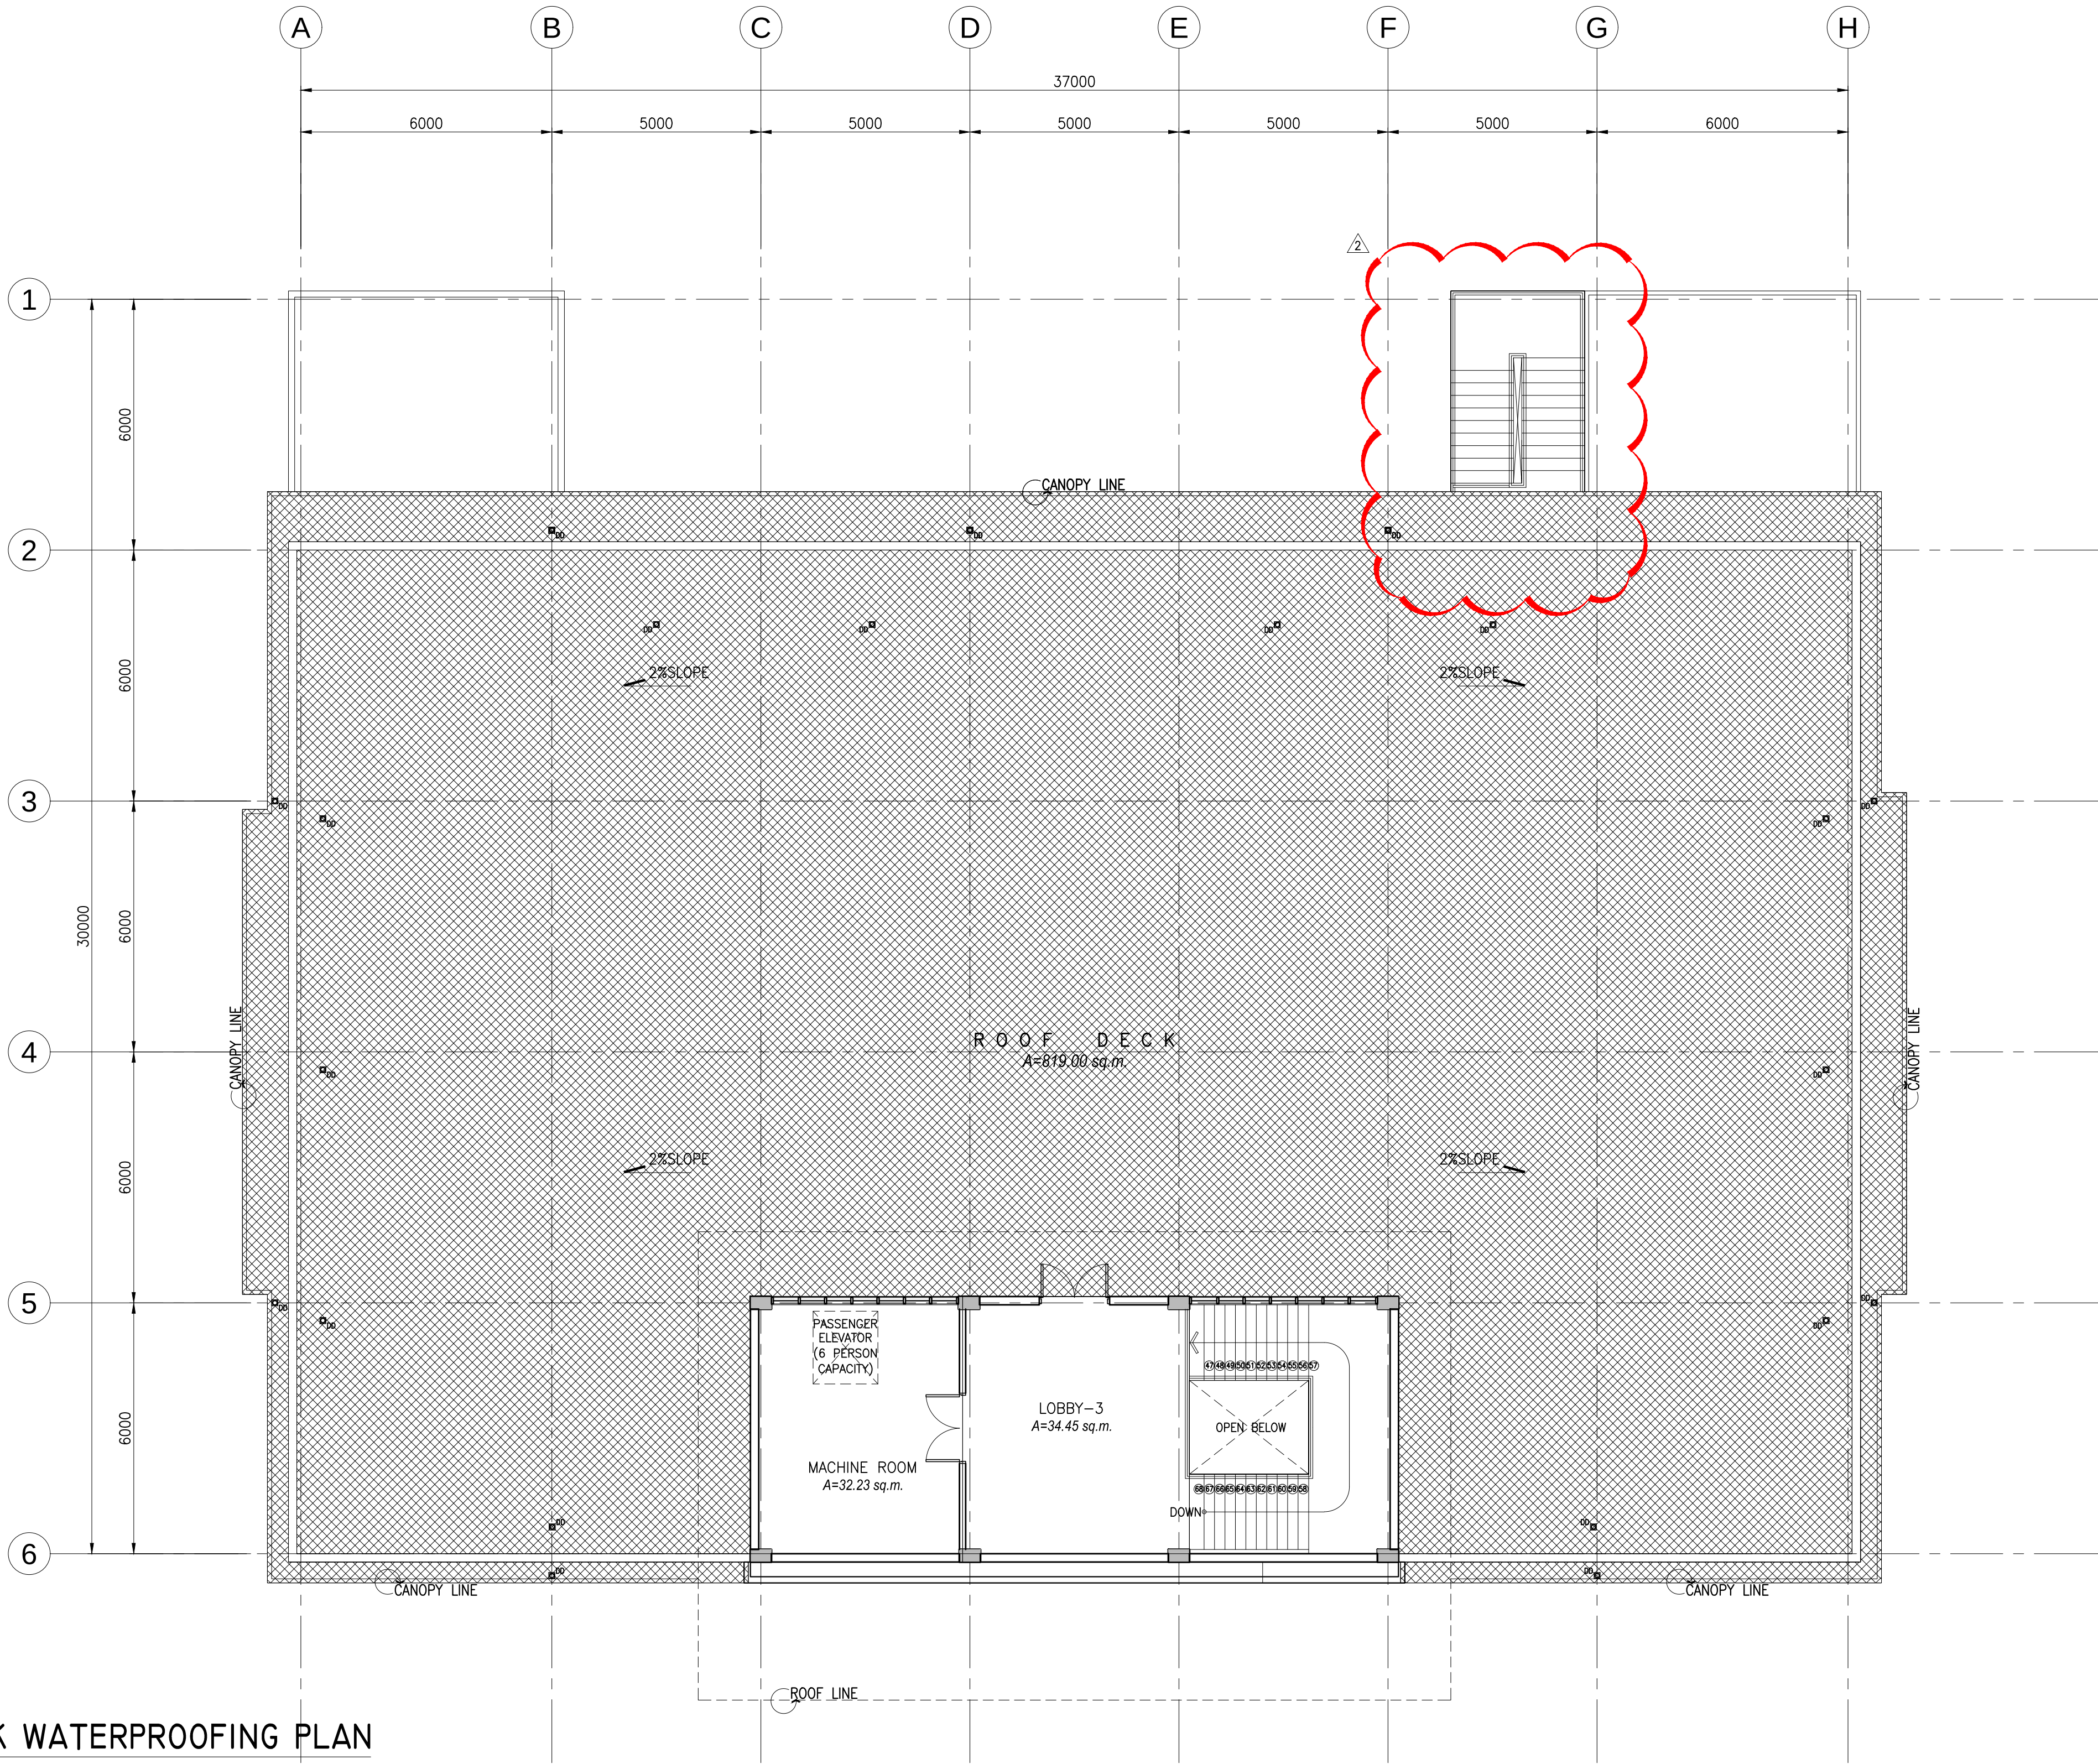


LEGEND	
	FLUID-APPLIED WATERPROOFING
	TRAFFICABLE LIQUID-APPLIED WATERPROOFING

I ROOF DECK WATERPROOFING PLAN
A-154 SCALE 1:100M

CERTIFIED BY		OWNER	PROJECT TITLE/LOCATION	CLIENT	SHEET CONTENTS	R.A. 9266 SEC. 33 DRAWINGS AND SPECIFICATIONS AND CONTRACT DOCUMENTS DULY SIGNED, STAMPED OR SEALED AS INSTRUMENTS FOR SERVICE ARE THE INTELLECTUAL PROPERTY AND DOCUMENTS OF ARCHITECT, WHETHER THE OBJECT FOR WHICH THEY ARE MADE IS EXECUTED OR NOT. IT SHALL BE UNLAWFUL FOR ANY PERSON TO DUPLICATE OR TO MAKE COPIES OF SAID DOCUMENTS FOR USE IN THE REPETITION OF AND FOR OTHER PROJECTS OR BUILDINGS, WHETHER EXECUTED PARTLY OR IN WHOLE, WITHOUT THE WRITTEN CONSENT OF THE ARCHITECT OR AUTHOR OF SAID DOCUMENTS.	CADD	DATE	NO.	REVISIONS	CHK	DATE	PAPER SIZE	SHEET NO.
MICHELANGELA O. SALVADOR, UAP		METROPOLITAN WATERWORKS AND SEWERAGE SYSTEM REGULATORY OFFICE	3-STOREY OFFICE BUILDING WITH ROOF DECK	PROJECT PROPONENT	ROOF DECK WATERPROOFING PLAN		GMT/NBR/SCEH	JUL 2018					20X30	A-154
ARCHITECT				MELCHOR S. CORDOVA ALTERNATE END-USER FOR RO BUILDING	PATRICK LESTER N. TY CHIEF REGULATOR, MWSS RO		DESIGNED	DATE					SCALE	PROJECT NO.
							JDEC	JUL 2018						
							APPROVED	DATE		ADDITIONAL FIRE EXIT STAIRS		10-30-2018	AS SHOWN	SO-G-17-036
							MOS	JUL 2018	1	SCHEMATIC DESIGN		03-09-2018		

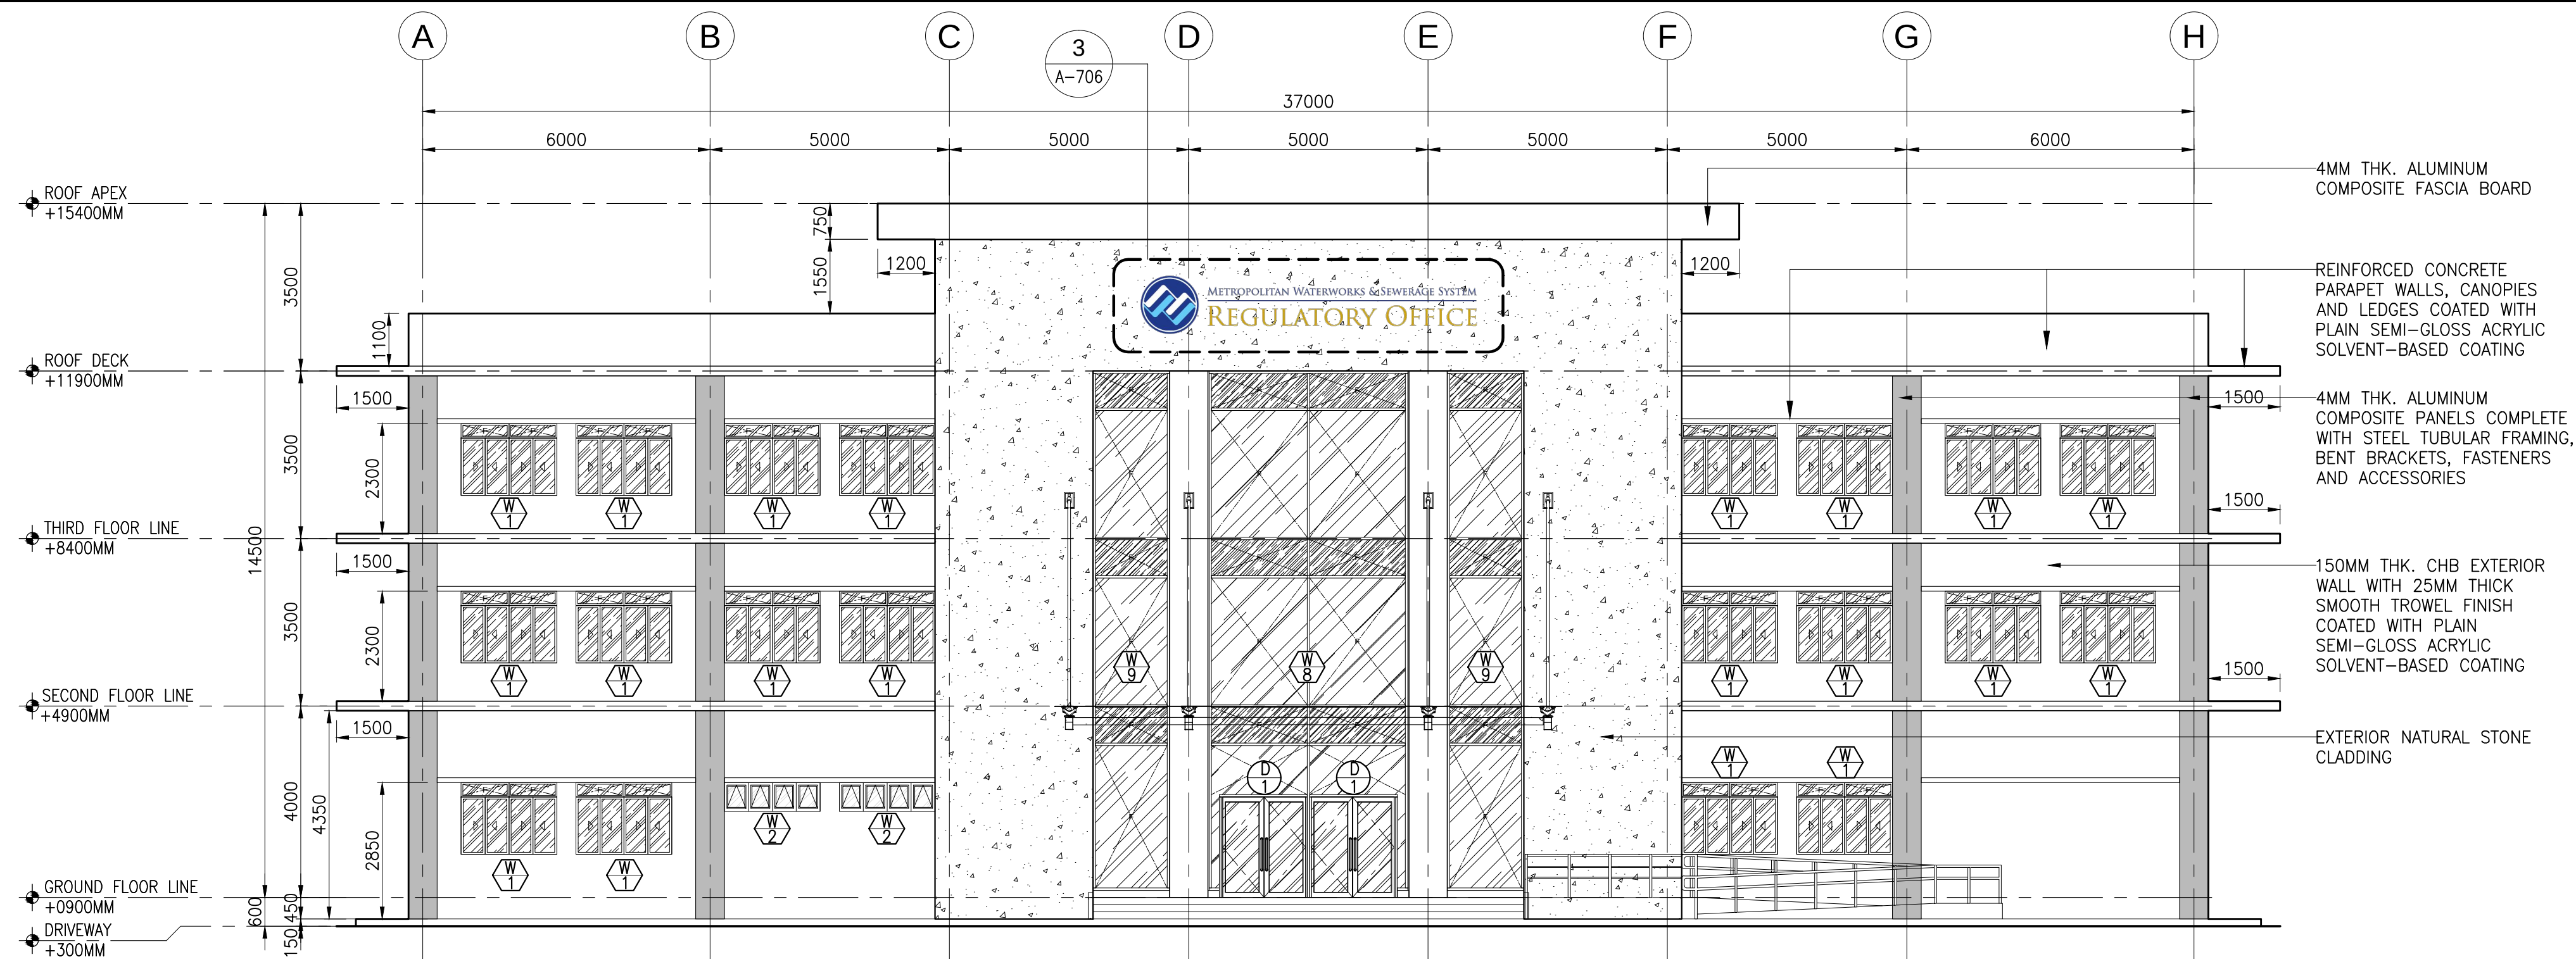


I FRONT ELEVATION
A-201 SCALE 1:100M

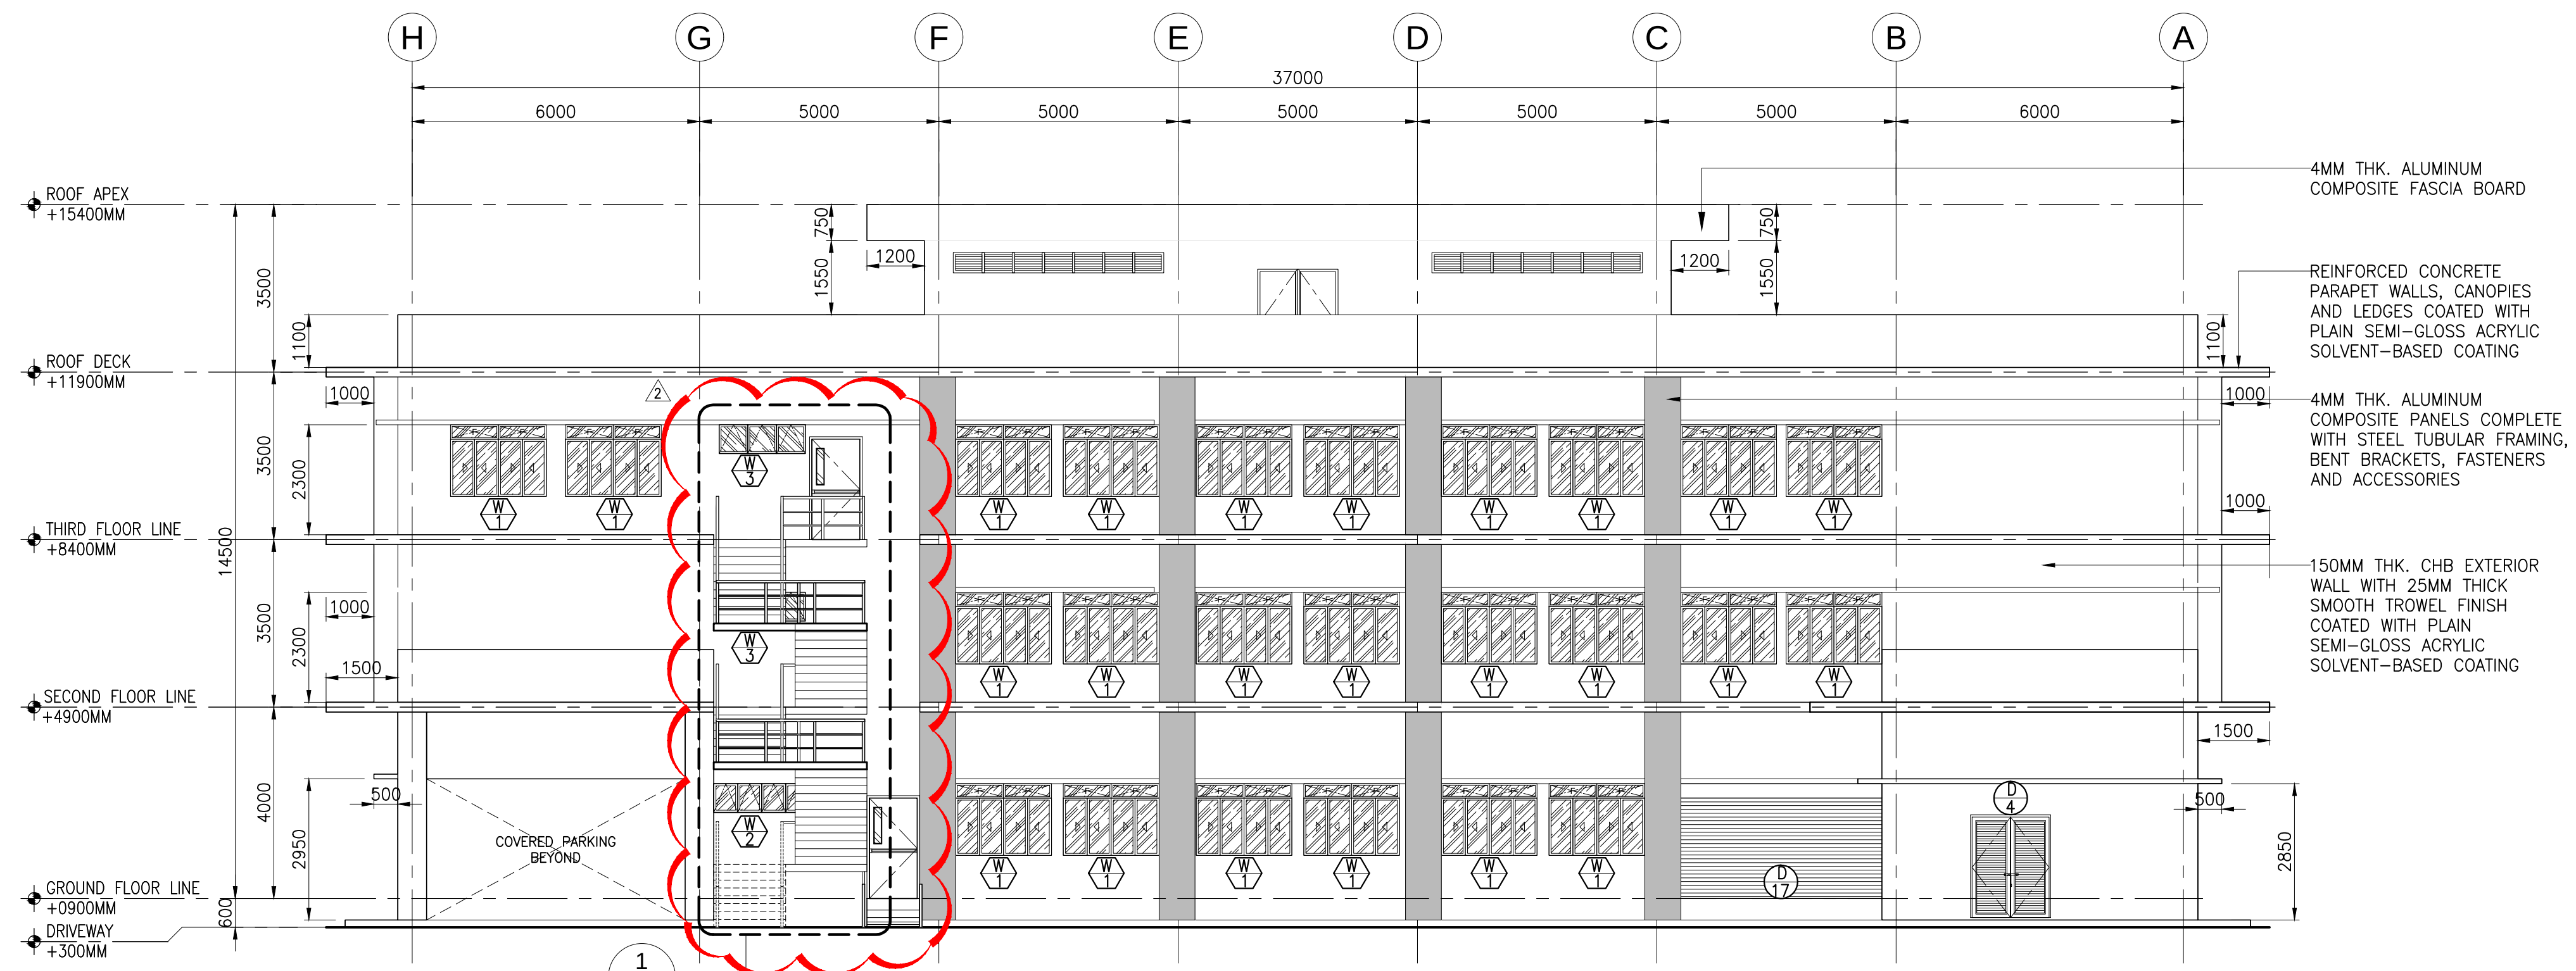


2 REAR ELEVATION
A-201 SCALE 1:100M

CERTIFIED BY		OWNER	PROJECT TITLE/LOCATION	CLIENT		SHEET CONTENTS	R.A. 9266 SEC. 33		CADD	DATE	NO.	REVISIONS	CHK	DATE	PAPER SIZE	SHEET NO.
MICHELANGELA O. SALVADOR, UAP ARCHITECT	REG. NO.: 0021601	METROPOLITAN WATERWORKS AND SEWERAGE SYSTEM REGULATORY OFFICE	3-STOREY OFFICE BUILDING WITH ROOF DECK	PROJECT PROPONENT	APPROVED BY:	FRONT ELEVATION REAR ELEVATION	DRAWINGS AND SPECIFICATIONS AND CONTRACT DOCUMENTS DULY SIGNED, STAMPED OR SEALED AS INSTRUMENTS FOR SERVICE ARE THE INTELLECTUAL PROPERTY AND DOCUMENTS OF ARCHITECT, WHETHER THE OBJECT FOR WHICH THEY ARE MADE IS EXECUTED OR NOT. IT SHALL BE UNLAWFUL FOR ANY PERSON TO DUPLICATE OR TO MAKE COPIES OF SAID DOCUMENTS FOR USE IN THE REPETITION OF AND FOR OTHER PROJECTS OR BUILDINGS, WHETHER EXECUTED PARTLY OR IN WHOLE, WITHOUT THE WRITTEN CONSENT OF THE ARCHITECT OR AUTHOR OF SAID DOCUMENTS.		GMT/NBR/SCCH	JUL 2018					20X30	A-201
	IAPOA : 17156228123072318															
	TIN NO. : 271-680-669-000															
	PTR NO. : 6679972															
	DATE : 2/8/2018	MWSS COMPOUND, KATIPUNAN AVENUE, MATANGANG BALARA, QUEZON CITY	MWSS COMPOUND, KATIPUNAN AVENUE, MATANGANG BALARA, QUEZON CITY	MELCHOR S. CORDOVA ALTERNATE END-USER FOR RO BUILDING	PATRICK LESTER N. TY CHIEF REGULATOR, MWSS RO											
PLACE : MAKATI CITY								JDEC	DATE	JUL 2018					SCALE	PROJECT NO.
								APPROVED	DATE	 2	ADDITIONAL FIRE EXIT STAIRS	10-30-2018			AS SHOWN	SO-G-17-036
								MOS	JUL 2018	1	SCHEMATIC DESIGN	03-09-2018				

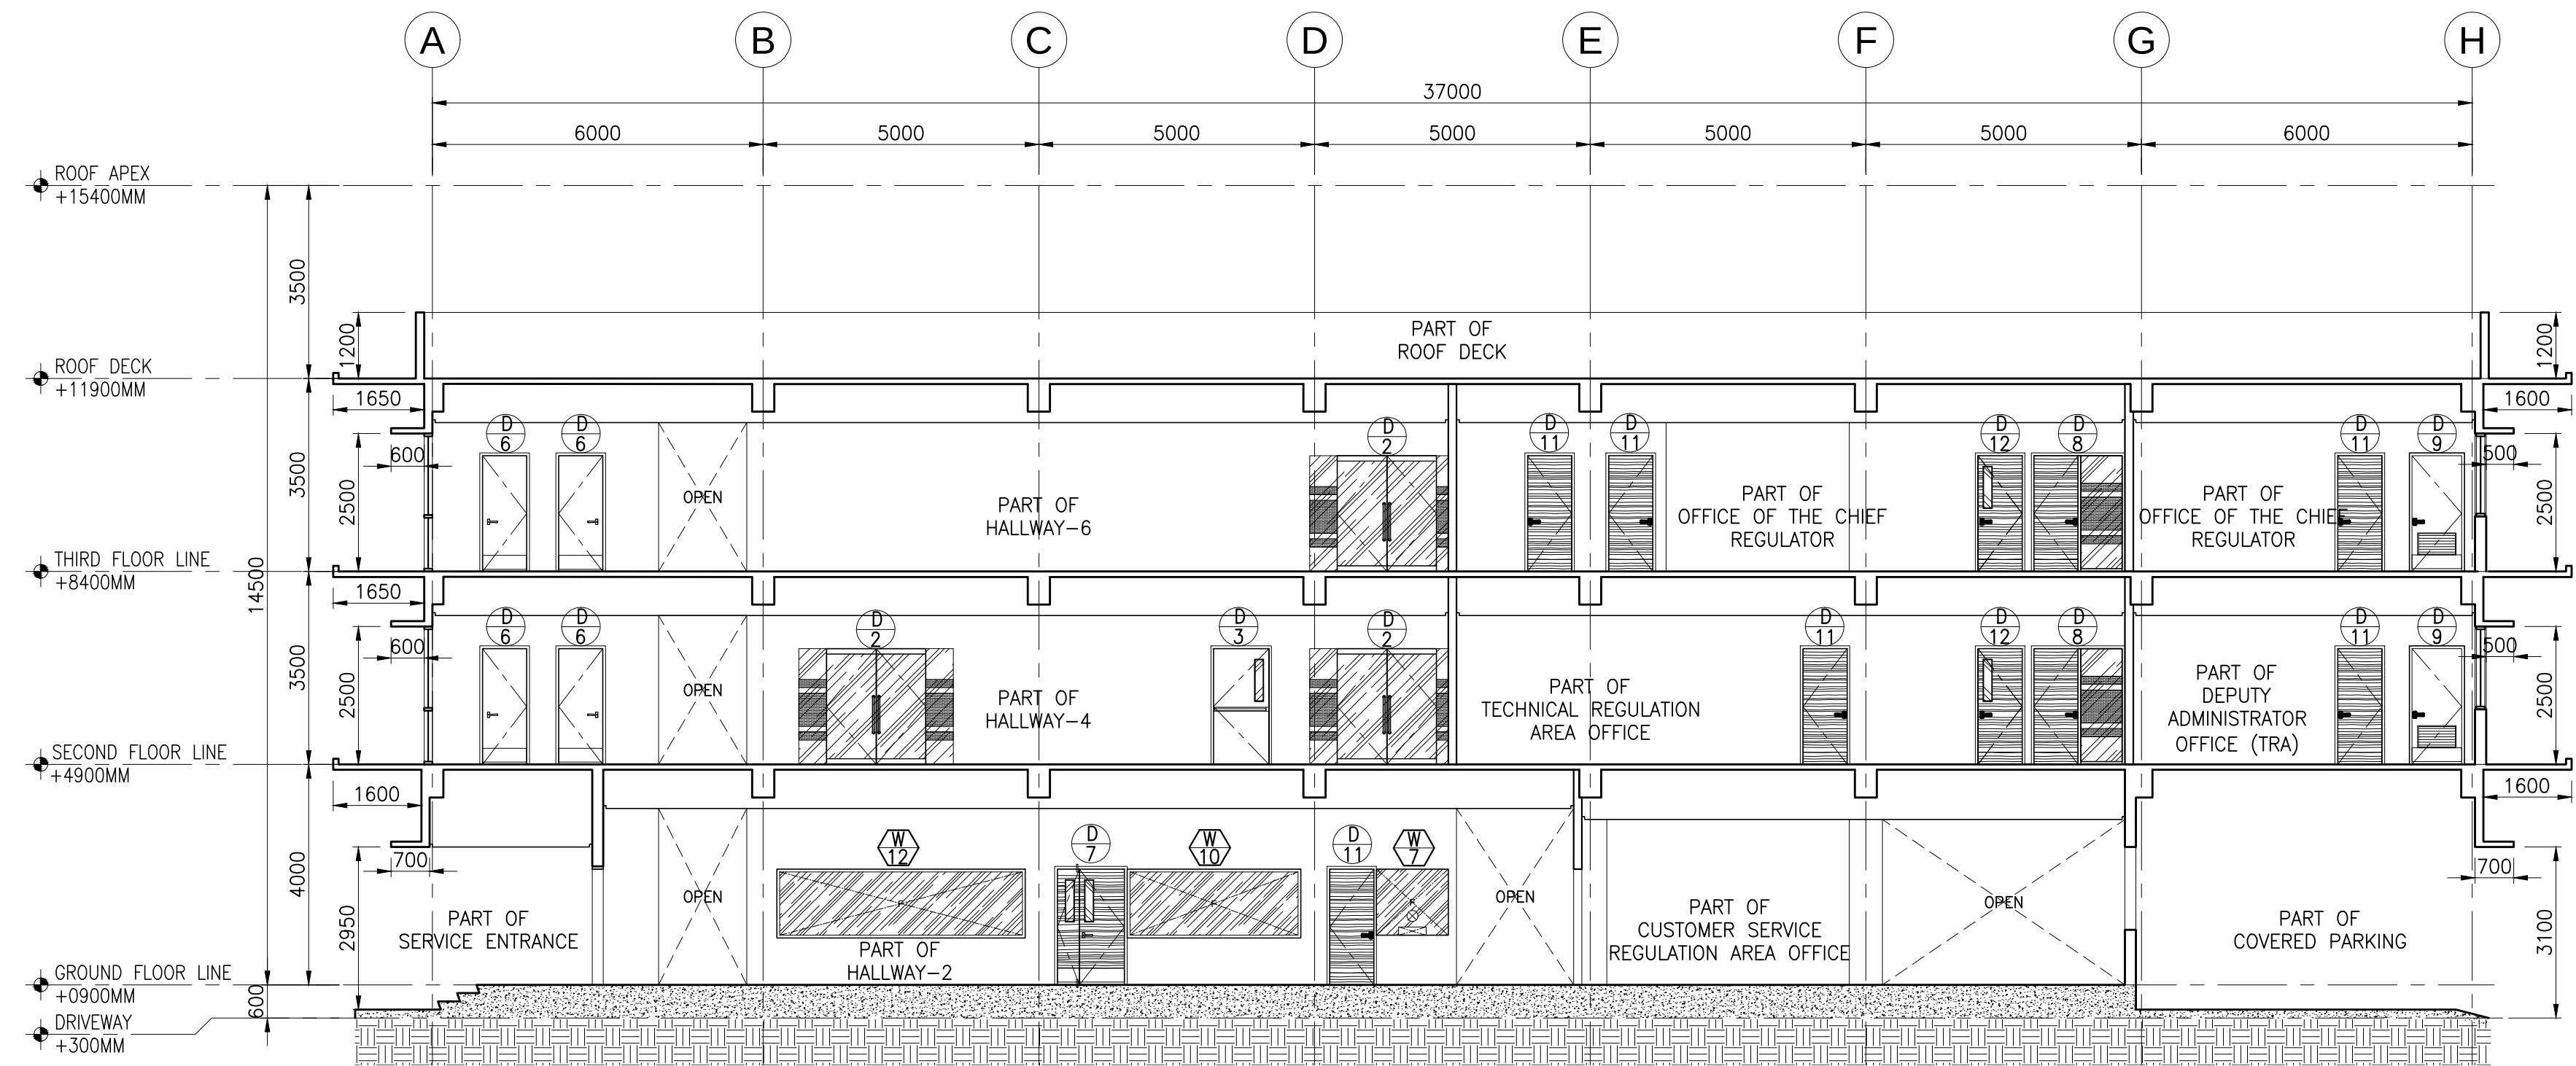

1 CROSS SECTION
A-301 SCALE 1:100M

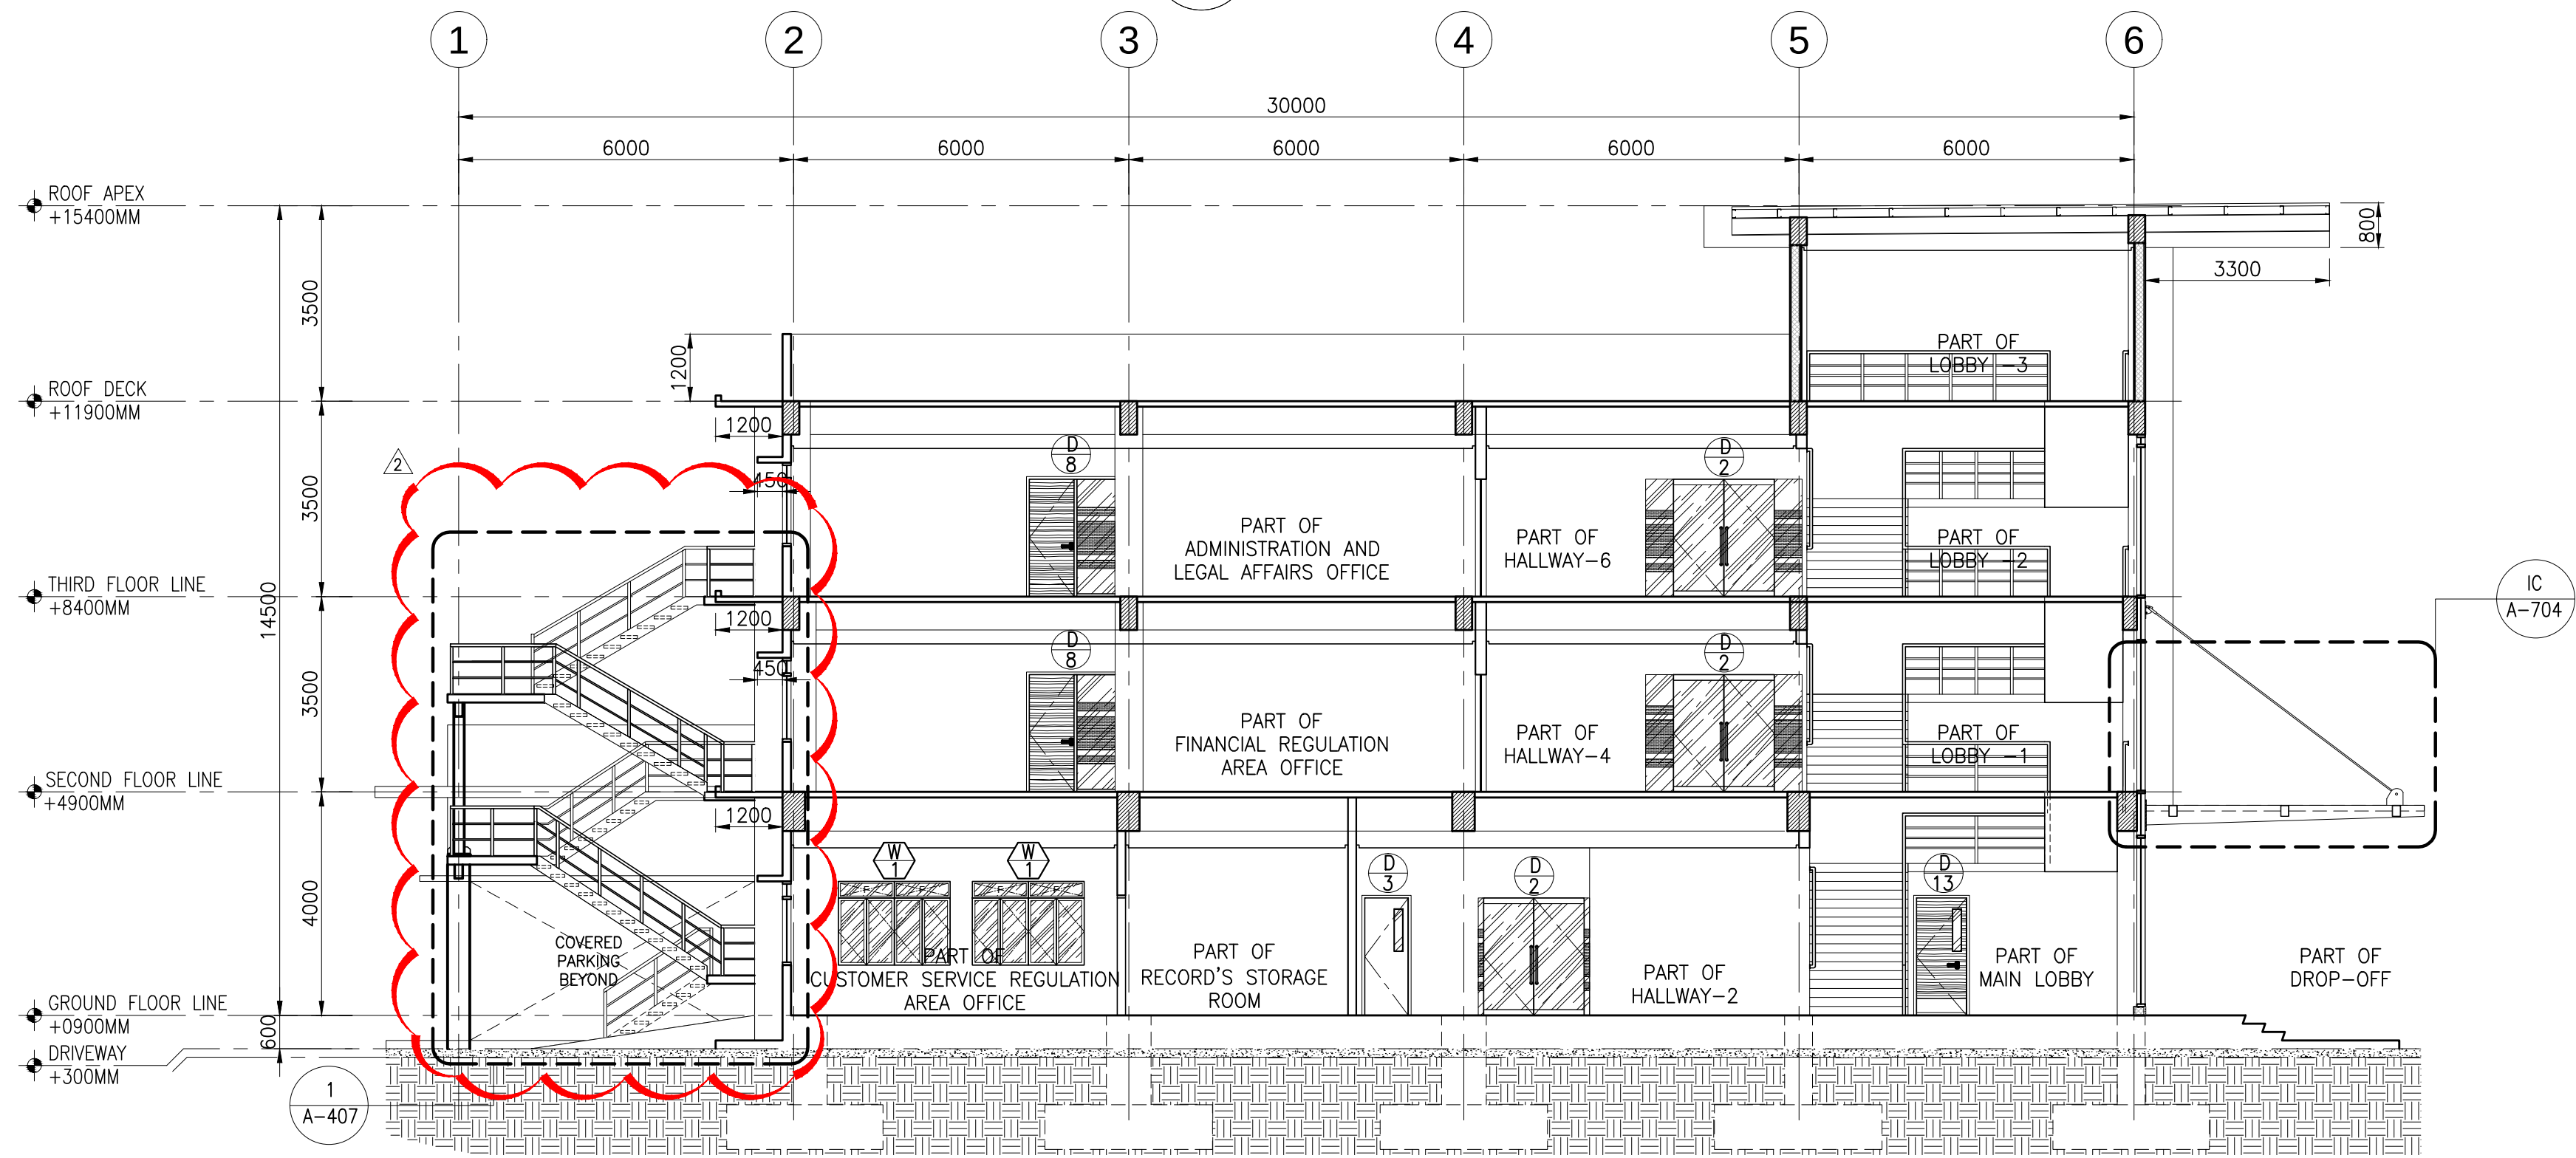


2 LONGITUDINAL SECTION
A-301 SCALE 1:100M

CERTIFIED BY		OWNER	PROJECT TITLE/LOCATION	CLIENT		SHEET CONTENTS	R.A. 9266 SEC. 33		CADD	DATE	NO.	REVISIONS	CHK	DATE	PAPER SIZE	SHEET NO.		
MICHELANGELA O. SALVADOR, UAP ARCHITECT	REG. NO.: 0021601	METROPOLITAN WATERWORKS AND SEWERAGE SYSTEM REGULATORY OFFICE	3-STOREY OFFICE BUILDING WITH ROOF DECK	PROJECT PROPONENT	APPROVED BY:	CROSS SECTION LONGITUDINAL SECTION	DRAWINGS AND SPECIFICATIONS AND CONTRACT DOCUMENTS DULY SIGNED, STAMPED OR SEALED AS INSTRUMENTS FOR SERVICE ARE THE INTELLECTUAL PROPERTY AND DOCUMENTS OF ARCHITECT, WHETHER THE OBJECT FOR WHICH THEY ARE MADE IS EXECUTED OR NOT. IT SHALL BE UNLAWFUL FOR ANY PERSON TO DUPLICATE OR TO MAKE COPIES OF SAID DOCUMENTS FOR USE IN THE REPETITION OF AND FOR OTHER PROJECTS OR BUILDINGS, WHETHER EXECUTED PARTLY OR IN WHOLE, WITHOUT THE WRITTEN CONSENT OF THE ARCHITECT OR AUTHOR OF SAID DOCUMENTS.	GMT/NBR/SCEH	JUL 2018						20X30	A-301		
	IAPOA : 17156228123072318																	
	TIN NO. : 271-680-669-000																	
	PTR NO. : 6679972																	
	DATE : 2/8/2018				MELCHOR S. CORDOVA	PATRICK LESTER N. TY												
PLACE : MAKATI CITY		MWSS COMPOUND, KATIPUNAN AVENUE, MATANGANG BALARA, QUEZON CITY	MWSS COMPOUND, KATIPUNAN AVENUE, MATANGANG BALARA, QUEZON CITY	ALTERNATE END-USER FOR RO BUILDING	CHIEF REGULATOR, MWSS RO			APPROVED	DATE		ADDITIONAL FIRE EXIT STAIRS	10-30-2018		AS SHOWN	SO-G-17-036			
								MOS	JUL 2018	1	SCHEMATIC DESIGN	03-09-2018						




INTERIOR DESIGN

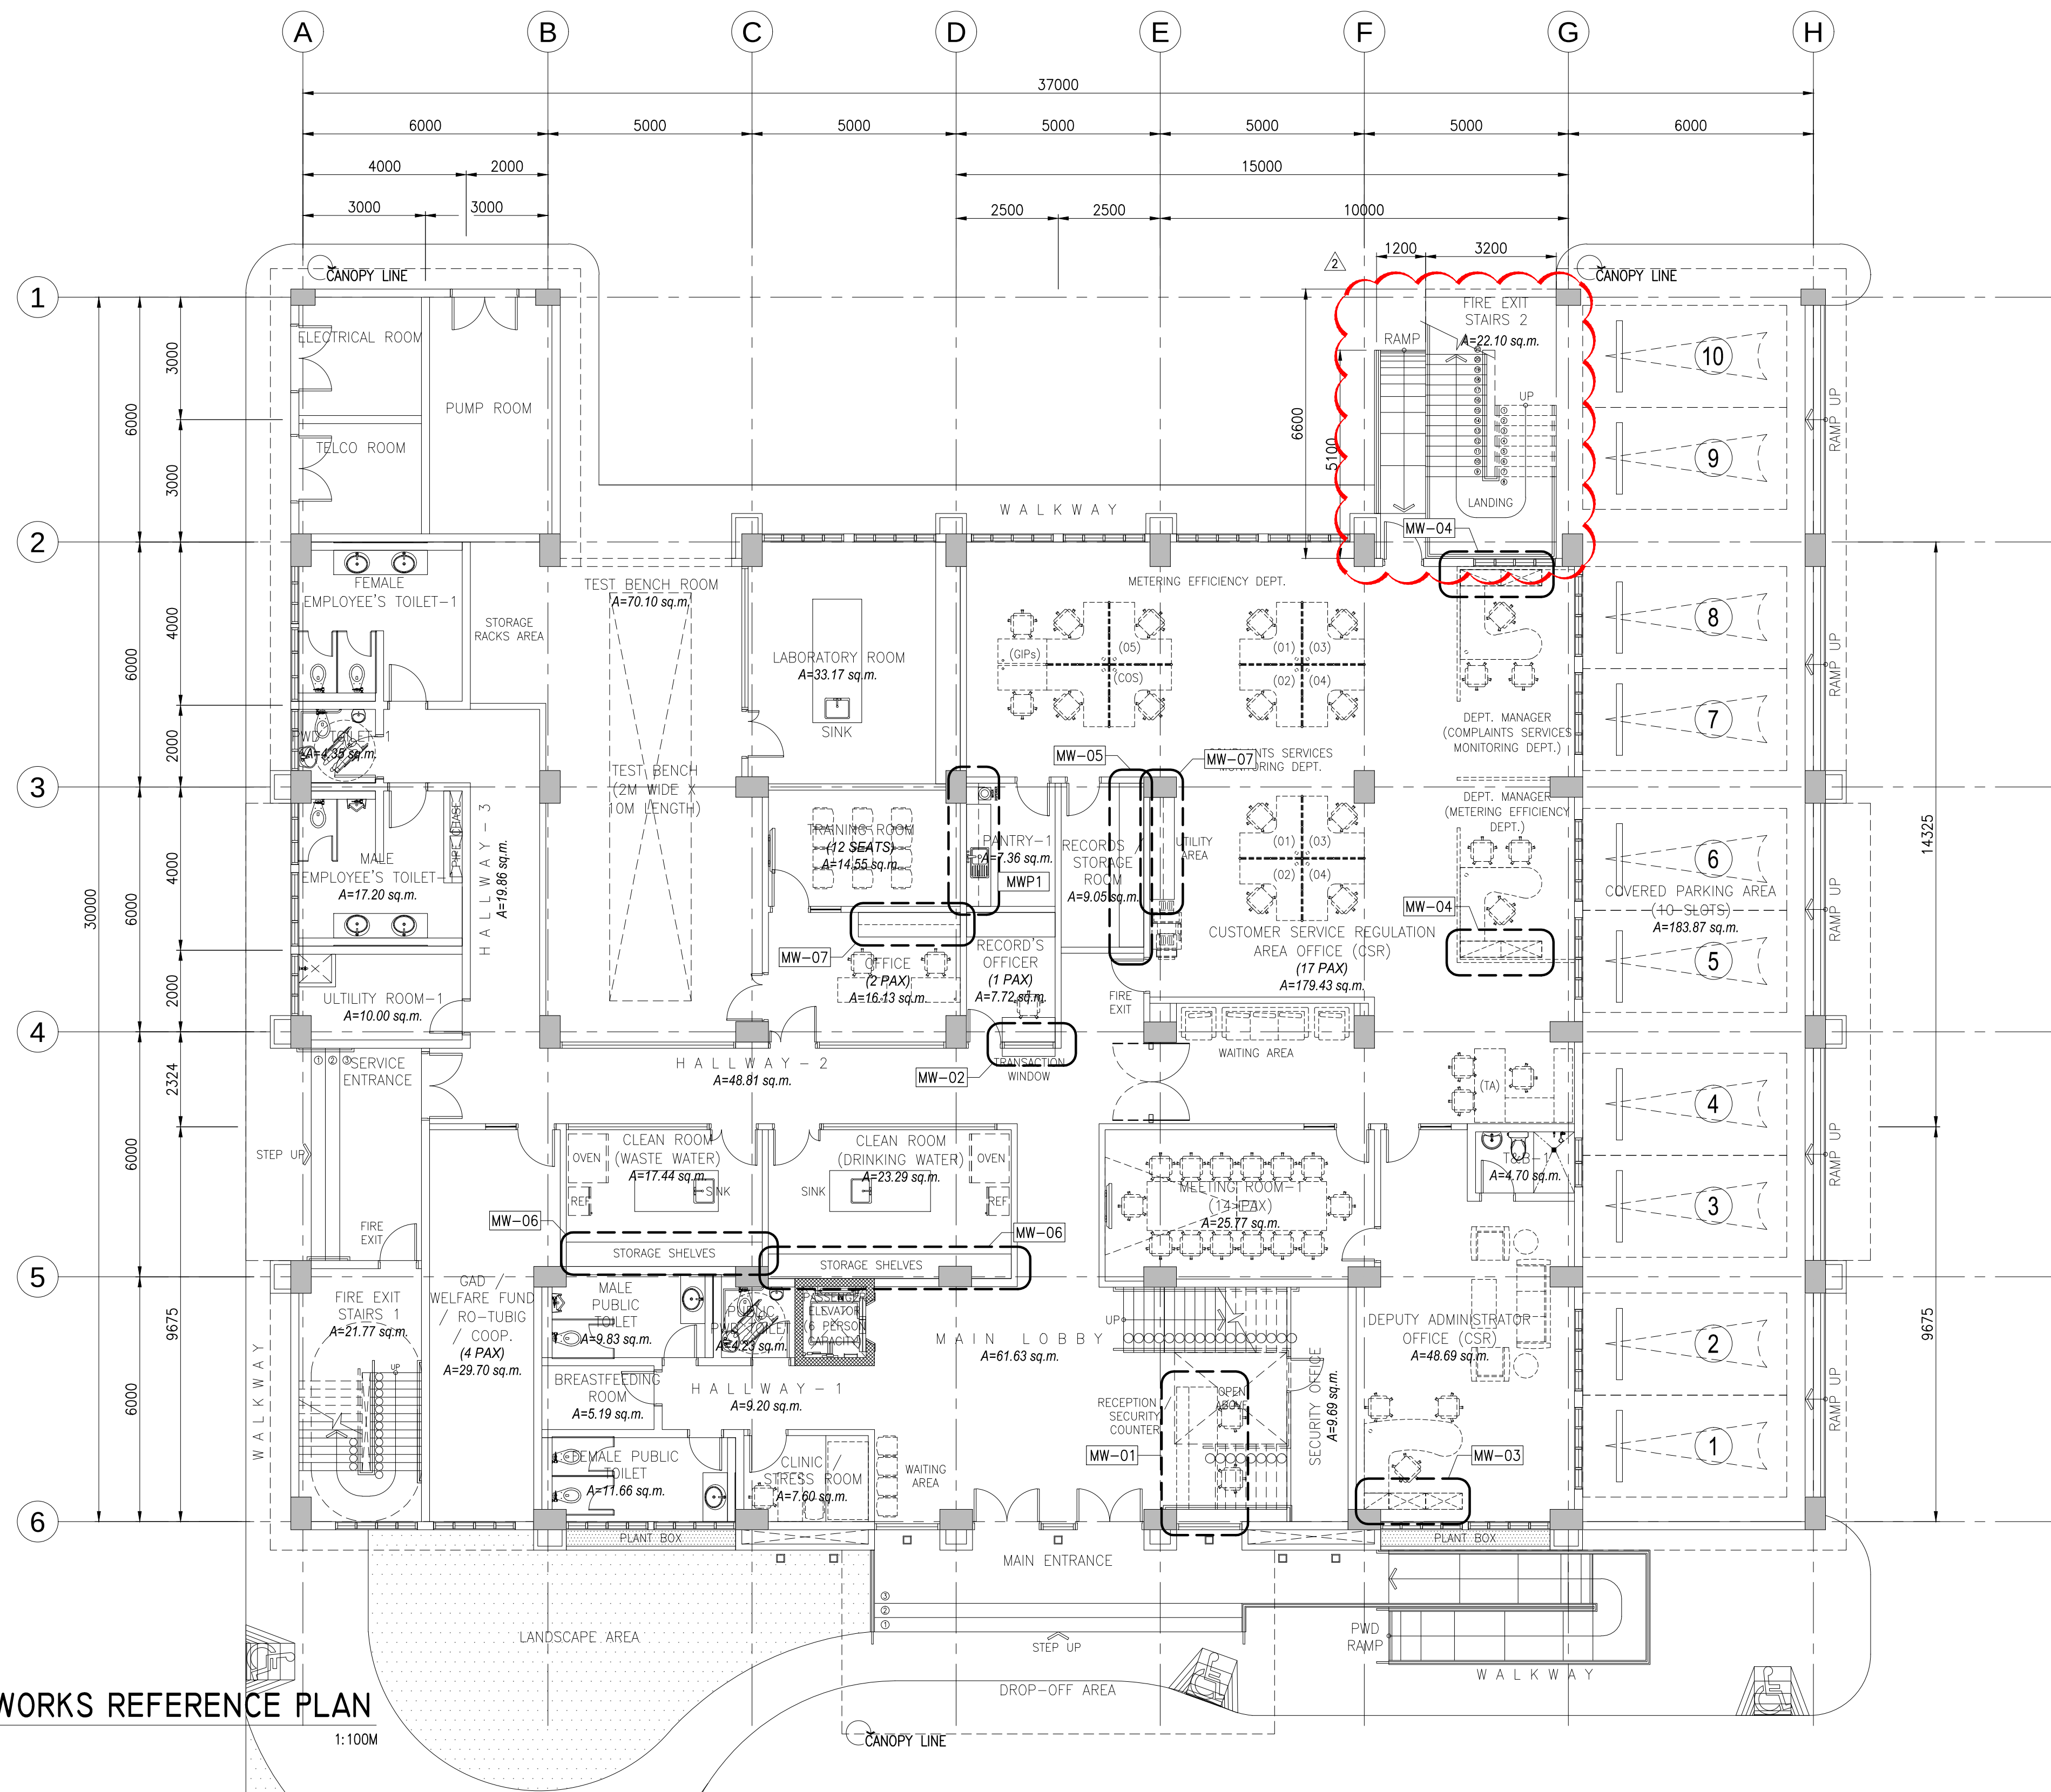


I GROUND FLOOR MILLWORKS REFERENCE PLAN
AI-101 SCALE 1:100M

CERTIFIED BY	REG. NO.: 0021601	OWNER	PROJECT TITLE/LOCATION	CLIENT	SHEET CONTENTS	R.A. 9266 SEC. 33	CADD	DATE	NO.	REVISIONS	CHK	DATE	PAPER SIZE	SHEET NO.
MICHELANGELA O. SALVADOR, UAP	IAPOA : 17156228123072318	METROPOLITAN WATERWORKS AND SEWERAGE SYSTEM REGULATORY OFFICE	3-STOREY OFFICE BUILDING WITH ROOF DECK	PROJECT PROPONENT	GROUND FLOOR MILLWORKS REFERENCE PLAN	DRAWINGS AND SPECIFICATIONS AND CONTRACT DOCUMENTS DULY SIGNED, STAMPED OR SEALED AS INSTRUMENTS FOR SERVICE ARE THE INTELLECTUAL PROPERTY AND DOCUMENTS OF ARCHITECT, WHETHER THE OBJECT FOR WHICH THEY ARE MADE IS EXECUTED OR NOT. IT SHALL BE UNLAWFUL FOR ANY PERSON TO DUPLICATE OR TO MAKE COPIES OF SAID DOCUMENTS FOR USE IN THE REPETITION OF AND FOR OTHER PROJECTS OR BUILDINGS, WHETHER EXECUTED PARTLY OR IN WHOLE, WITHOUT THE WRITTEN CONSENT OF THE ARCHITECT OR AUTHOR OF SAID DOCUMENTS.	GMT/NBR/SC/	JUL 2018					20X30	AI-101
ARCHITECT	TIN NO. : 271-680-669-000						DESIGNED	DATE					SCALE	PROJECT NO.
	PTR NO. : 6679972						JDEC	JUL 2018						
	DATE : 2/8/2018						APPROVED	DATE		ADDITIONAL FIRE EXIT STAIRS		10-30-2018	AS SHOWN	SO-G-17-036
	PLACE : MAKATI CITY	MWSS COMPOUND, KATIPUNAN AVENUE, MATANGANG BALARA, QUEZON CITY	MWSS COMPOUND, KATIPUNAN AVENUE, MATANGANG BALARA, QUEZON CITY	MELCHOR S. CORDOVA ALTERNATE END-USER FOR RO BUILDING	PATRICK LESTER N. TY CHIEF REGULATOR, MWSS RO		MOS	JUL 2018	1	SCHEMATIC DESIGN		03-09-2018		

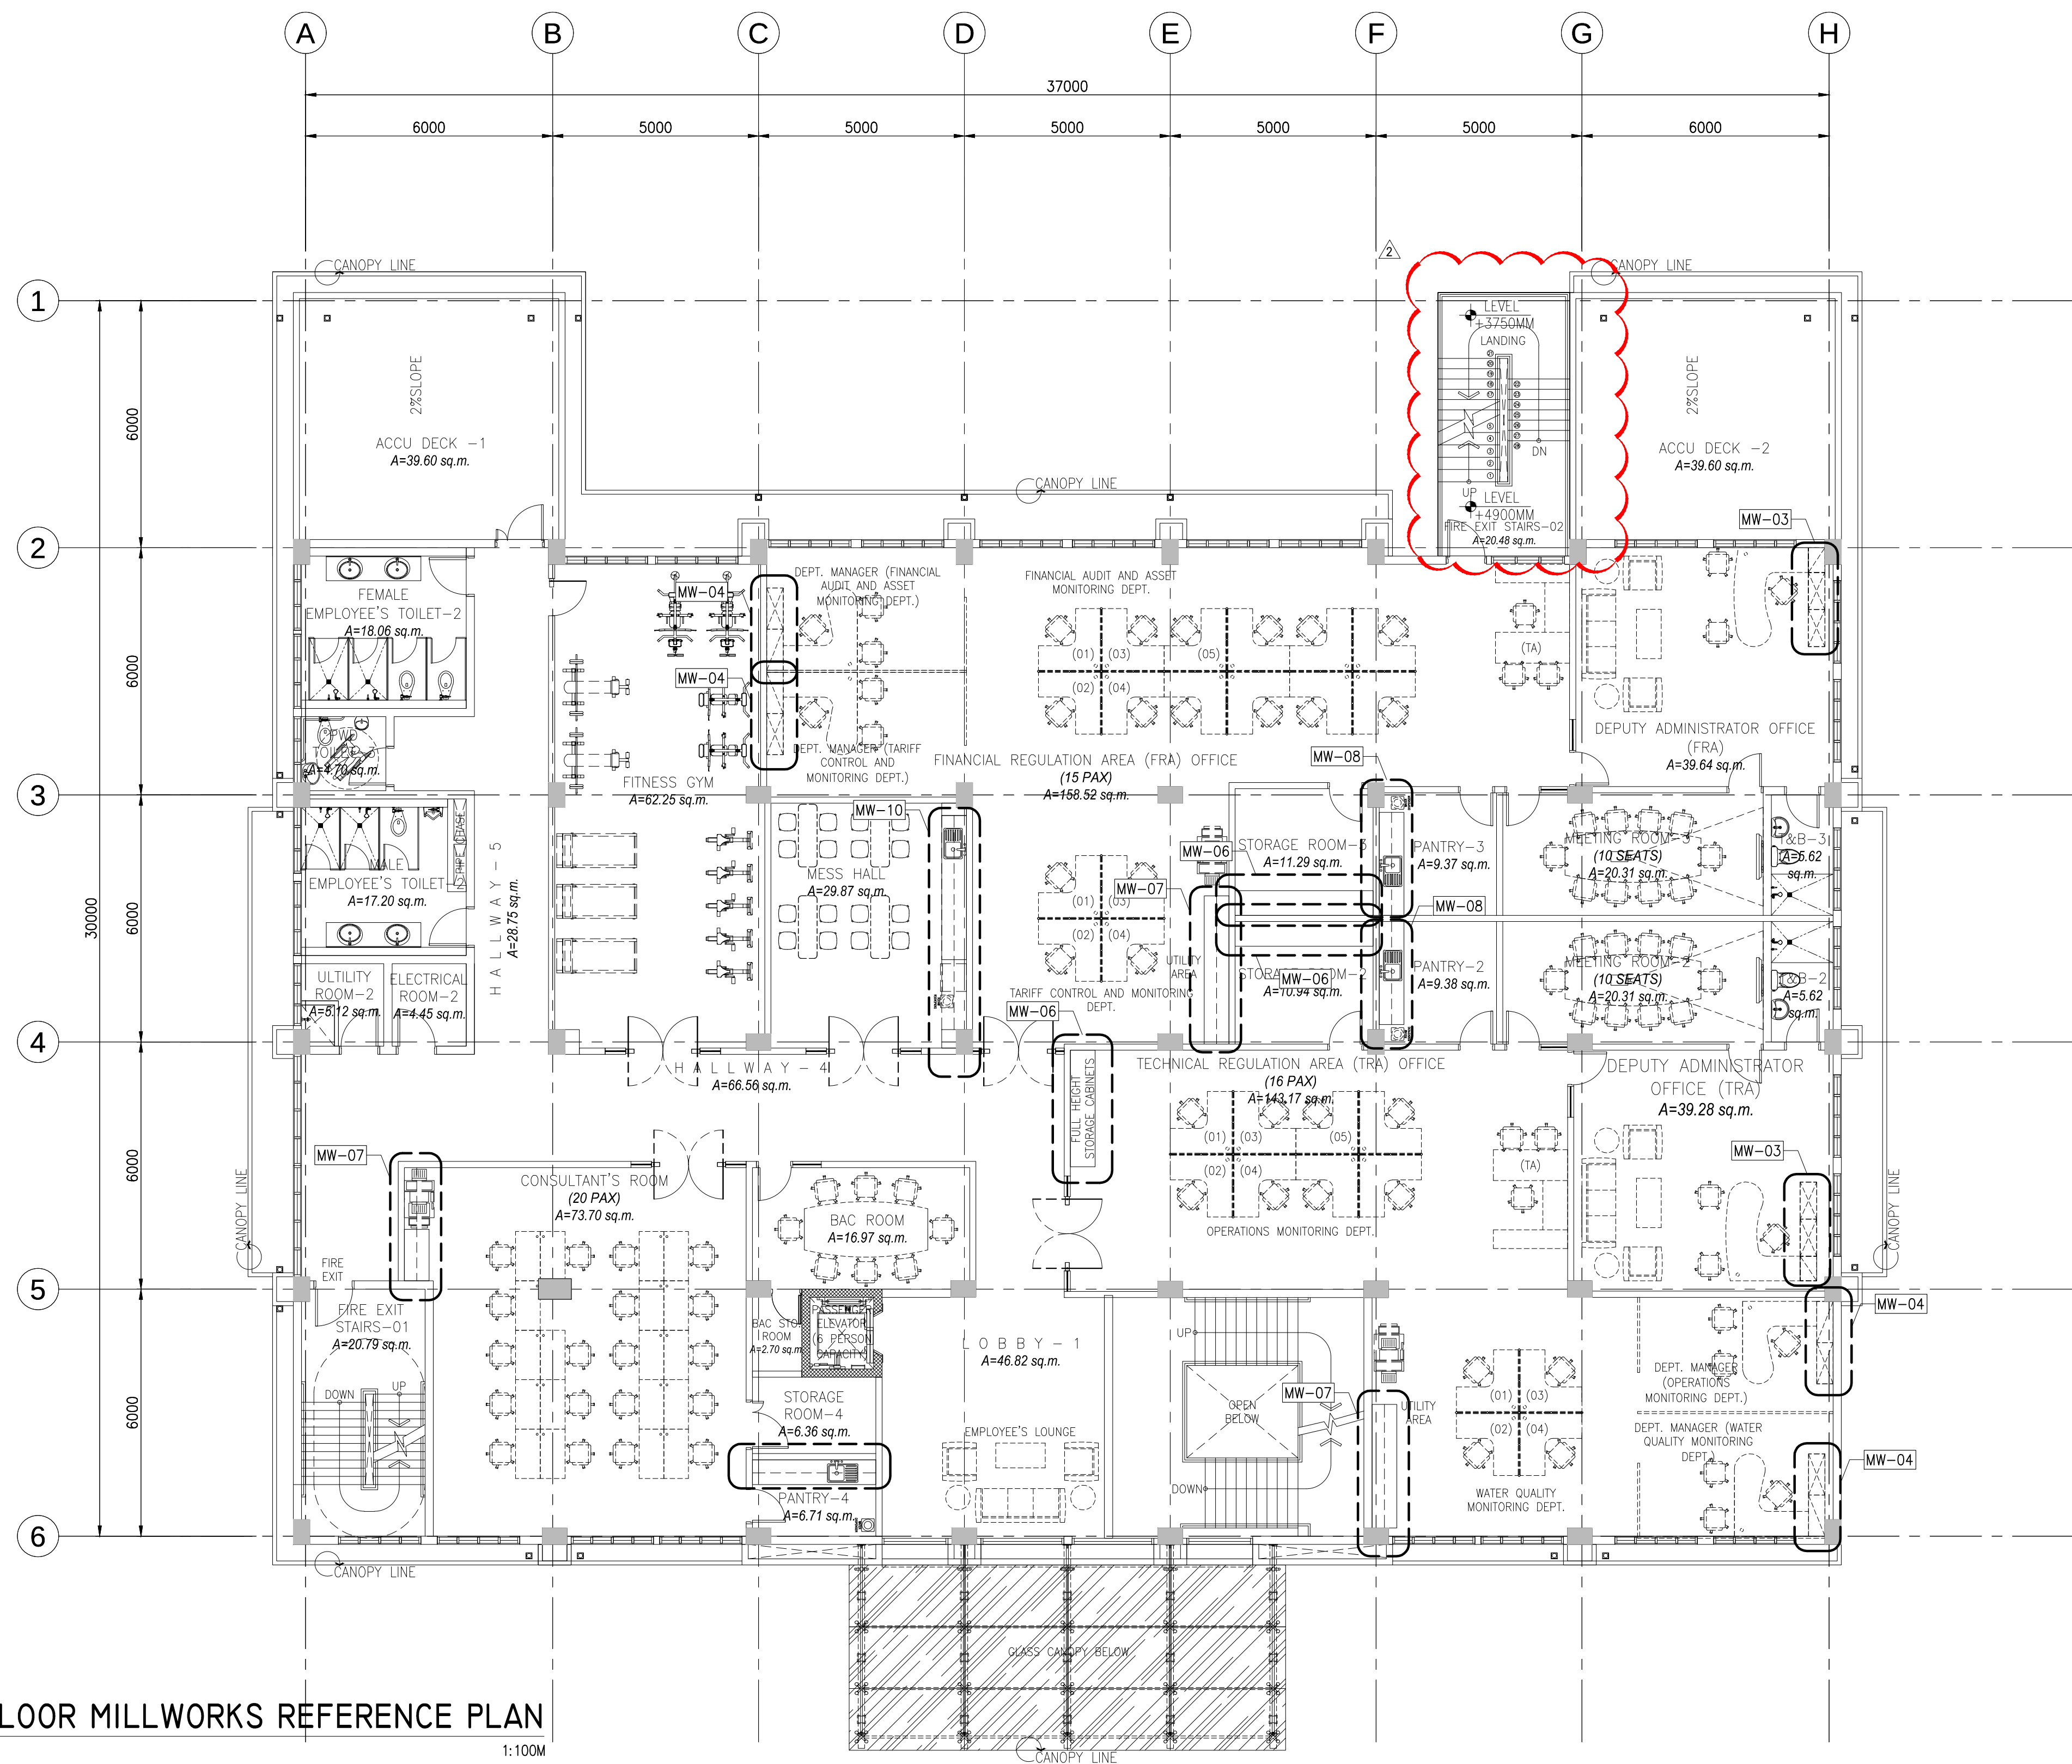


I SECOND FLOOR MILLWORKS REFERENCE PLAN
AI-102 SCALE 1:100M

CERTIFIED BY		OWNER	PROJECT TITLE/LOCATION	CLIENT	SHEET CONTENTS	R.A. 9266 SEC. 33		CADD	DATE	NO.	REVISIONS	CHK	DATE	PAPER SIZE	SHEET NO.
MICHELANGELA O. SALVADOR, UAP		METROPOLITAN WATERWORKS AND SEWERAGE SYSTEM REGULATORY OFFICE	3-STOREY OFFICE BUILDING WITH ROOF DECK	PROJECT PROPONENT	APPROVED BY:	DRAWINGS AND SPECIFICATIONS AND CONTRACT DOCUMENTS DULY SIGNED, STAMPED OR SEALED AS INSTRUMENTS FOR SERVICE ARE THE INTELLECTUAL PROPERTY AND DOCUMENTS OF ARCHITECT, WHETHER THE OBJECT FOR WHICH THEY ARE MADE IS EXECUTED OR NOT. IT SHALL BE UNLAWFUL FOR ANY PERSON TO DUPLICATE OR TO MAKE COPIES OF SAID DOCUMENTS FOR USE IN THE REPETITION OF AND FOR OTHER PROJECTS OR BUILDINGS, WHETHER EXECUTED PARTLY OR IN WHOLE, WITHOUT THE WRITTEN CONSENT OF THE ARCHITECT OR AUTHOR OF SAID DOCUMENTS.		GMT/NBR/SC/	JUL 2018					20X30	AI-102
ARCHITECT		MWSS COMPOUND, KATIPUNAN AVENUE, MATandang BALARA, QUEZON CITY	MWSS COMPOUND, KATIPUNAN AVENUE, MATandang BALARA, QUEZON CITY	MELCHOR S. CORDOVA ALTERNATE END-USER FOR RO BUILDING	PATRICK LESTER N. TY CHIEF REGULATOR, MWSS RO	SECOND FLOOR MILLWORKS REFERENCE PLAN		DESIGNED	DATE					SCALE	PROJECT NO.
								JDEC	JUL 2018						
								APPROVED	DATE		ADDITIONAL FIRE EXIT STAIRS		10-30-2018	AS SHOWN	SO-G-17-036
								MOS	JUL 2018	1	SCHEMATIC DESIGN		03-09-2018		

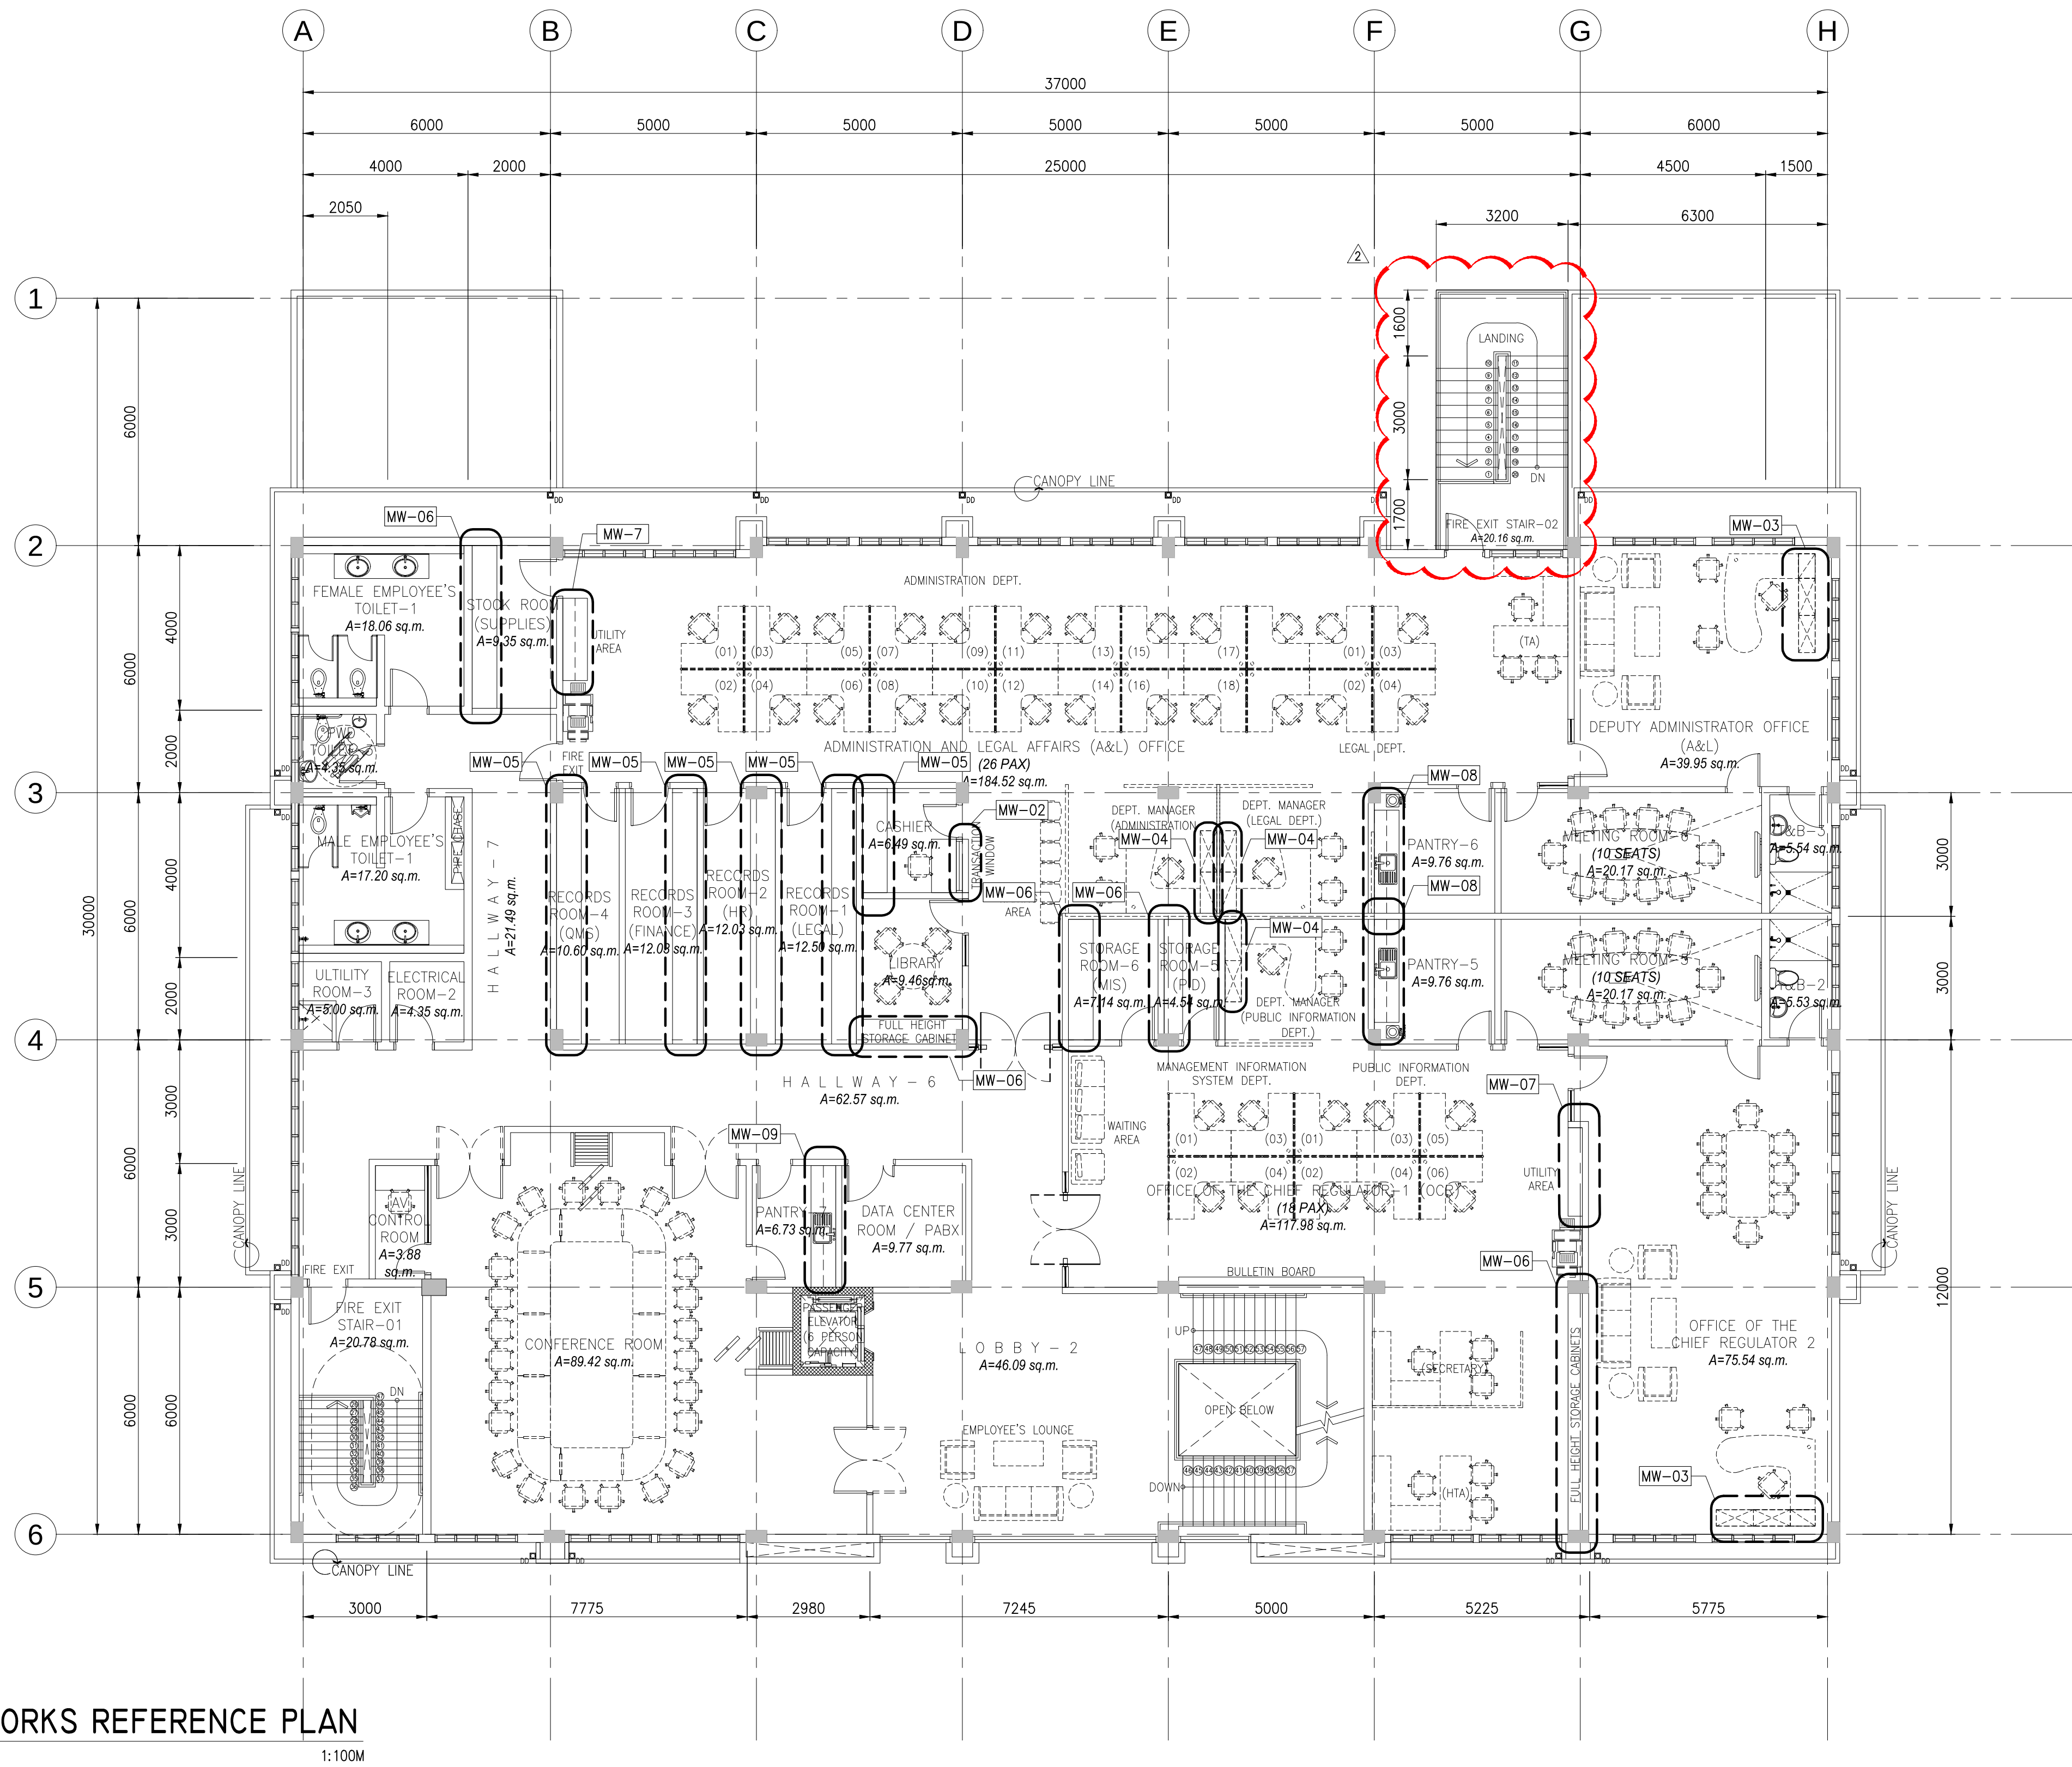


I THIRD FLOOR MILLWORKS REFERENCE PLAN
AI-103 SCALE 1:100M



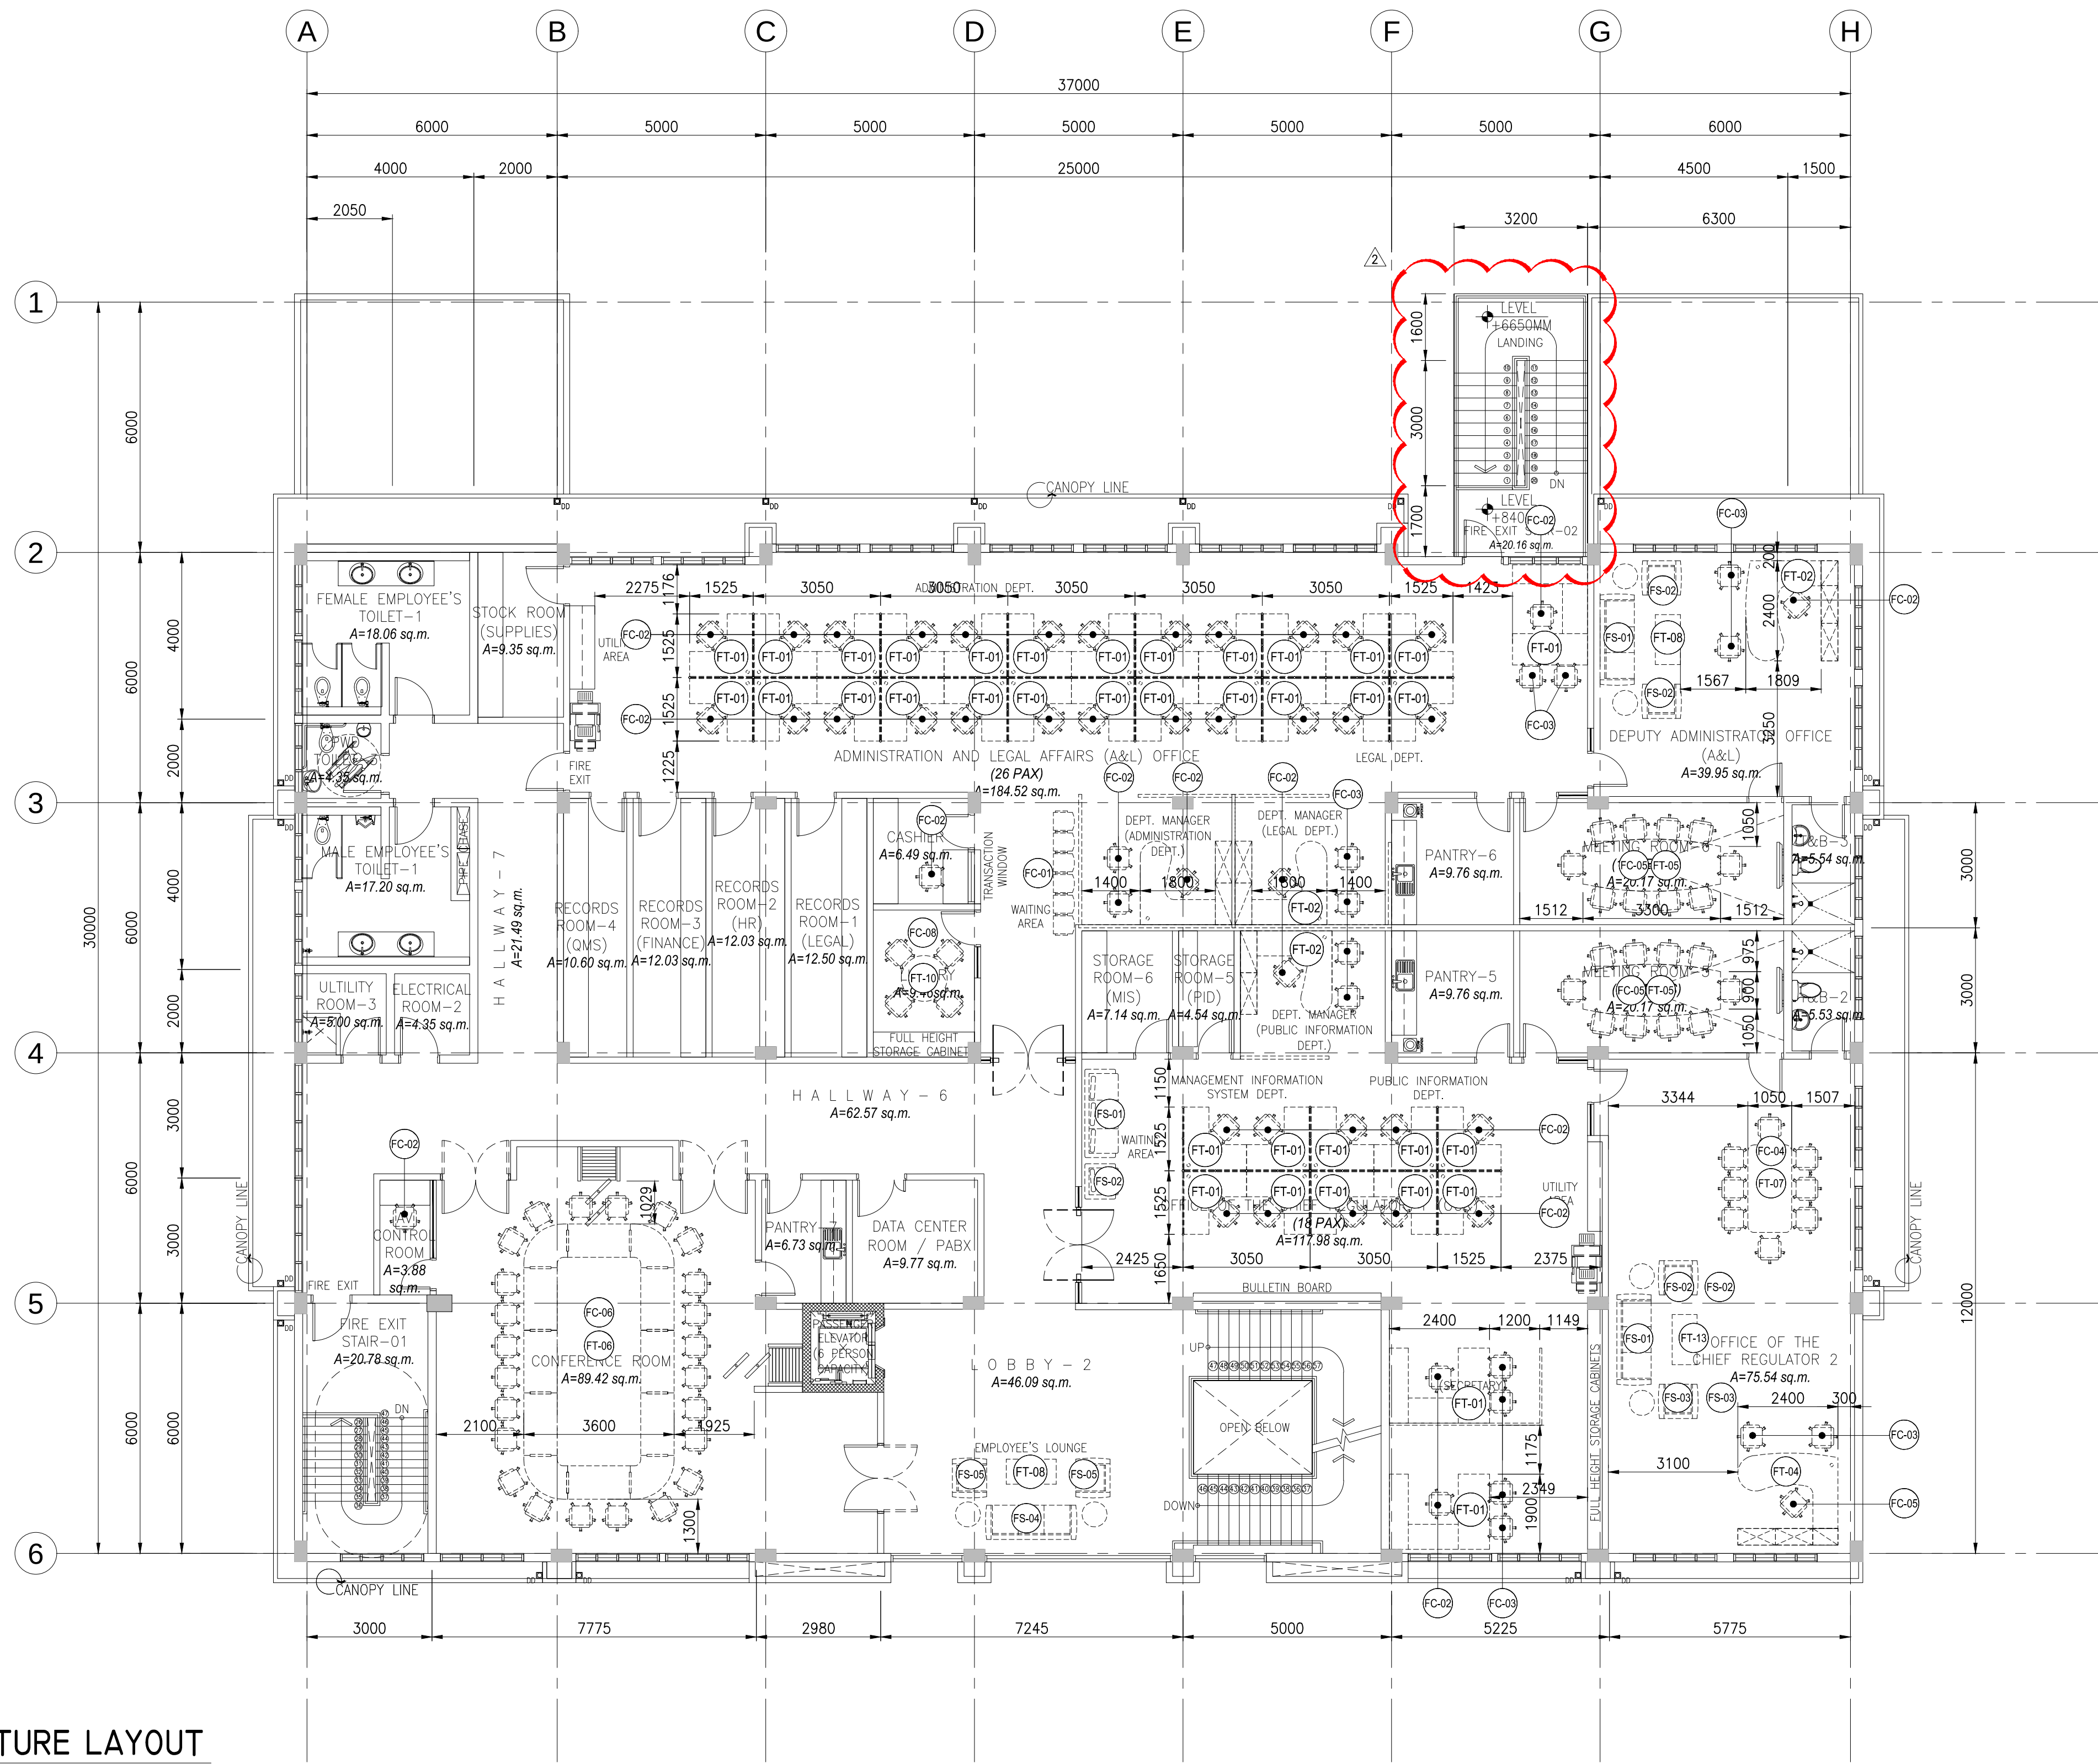


I THIRD FLOOR FURNITURE LAYOUT
AI-203 SCALE 1:100M

acoing CONSULTING INC. Engineering + Management ISO 9001:2015 Certified 2F LTA Building 118 Perera Village, 1229 Makati City, Philippines Tel. Nos.: +63 2 8935827 Fax No.: +63 2 8935829 Email: acoconsulting@aco.com.ph Website: www.aco.com.ph	CERTIFIED BY		OWNER	PROJECT TITLE/LOCATION		CLIENT		SHEET CONTENTS		R.A. 9266 SEC. 33		CADD	DATE	NO.	REVISIONS		CHK	DATE	PAPER SIZE	SHEET NO.
	MICHELANGELA O. SALVADOR, UAP		METROPOLITAN WATERWORKS AND SEWERAGE SYSTEM REGULATORY OFFICE	3-STOREY OFFICE BUILDING WITH ROOF DECK	PROJECT PROPONENT	APPROVED BY:	THIRD FLOOR FURNITURE LAYOUT	DRAWINGS AND SPECIFICATIONS AND CONTRACT DOCUMENTS DULY SIGNED, STAMPED OR SEALED AS INSTRUMENTS FOR SERVICE ARE THE INTELLECTUAL PROPERTY AND DOCUMENTS OF ARCHITECT, WHETHER THE OBJECT FOR WHICH THEY ARE MADE IS EXECUTED OR NOT. IT SHALL BE UNLAWFUL FOR ANY PERSON TO DUPLICATE OR TO MAKE COPIES OF SAID DOCUMENTS FOR USE IN THE REPUTATION OF AND FOR OTHER PROJECTS OR BUILDINGS, WHETHER EXECUTED PARTLY OR IN WHOLE, WITHOUT THE WRITTEN CONSENT OF THE ARCHITECT OR AUTHOR OF SAID DOCUMENTS.	GMT/NBR/SC/	JUL 2018		DESIGNED	DATE			20X30	AI-203			
	ARCHITECT		MWSS COMPOUND, KATIPUNAN AVENUE, MATANDANG BALARA, QUEZON CITY	MWSS COMPOUND, KATIPUNAN AVENUE, MATANDANG BALARA, QUEZON CITY	MELCHOR S. CORDOVA ALTERNATE END-USER FOR RO BUILDING	PATRICK LESTER N. TY CHIEF REGULATOR, MWSS RO			JDEC	JUL 2018		APPROVED	DATE	1	ADDITIONAL FIRE EXIT STAIRS	10-30-2018	AS SHOWN	SO-G-17-036		
		REG. NO.: 0021601																		
		IAPOA : 17156228123072318																		
		TIN NO. : 271-680-669-000																		
		PTR NO. : 6679972																		
		DATE : 2/8/2018																		
		PLACE : MAKATI CITY																		

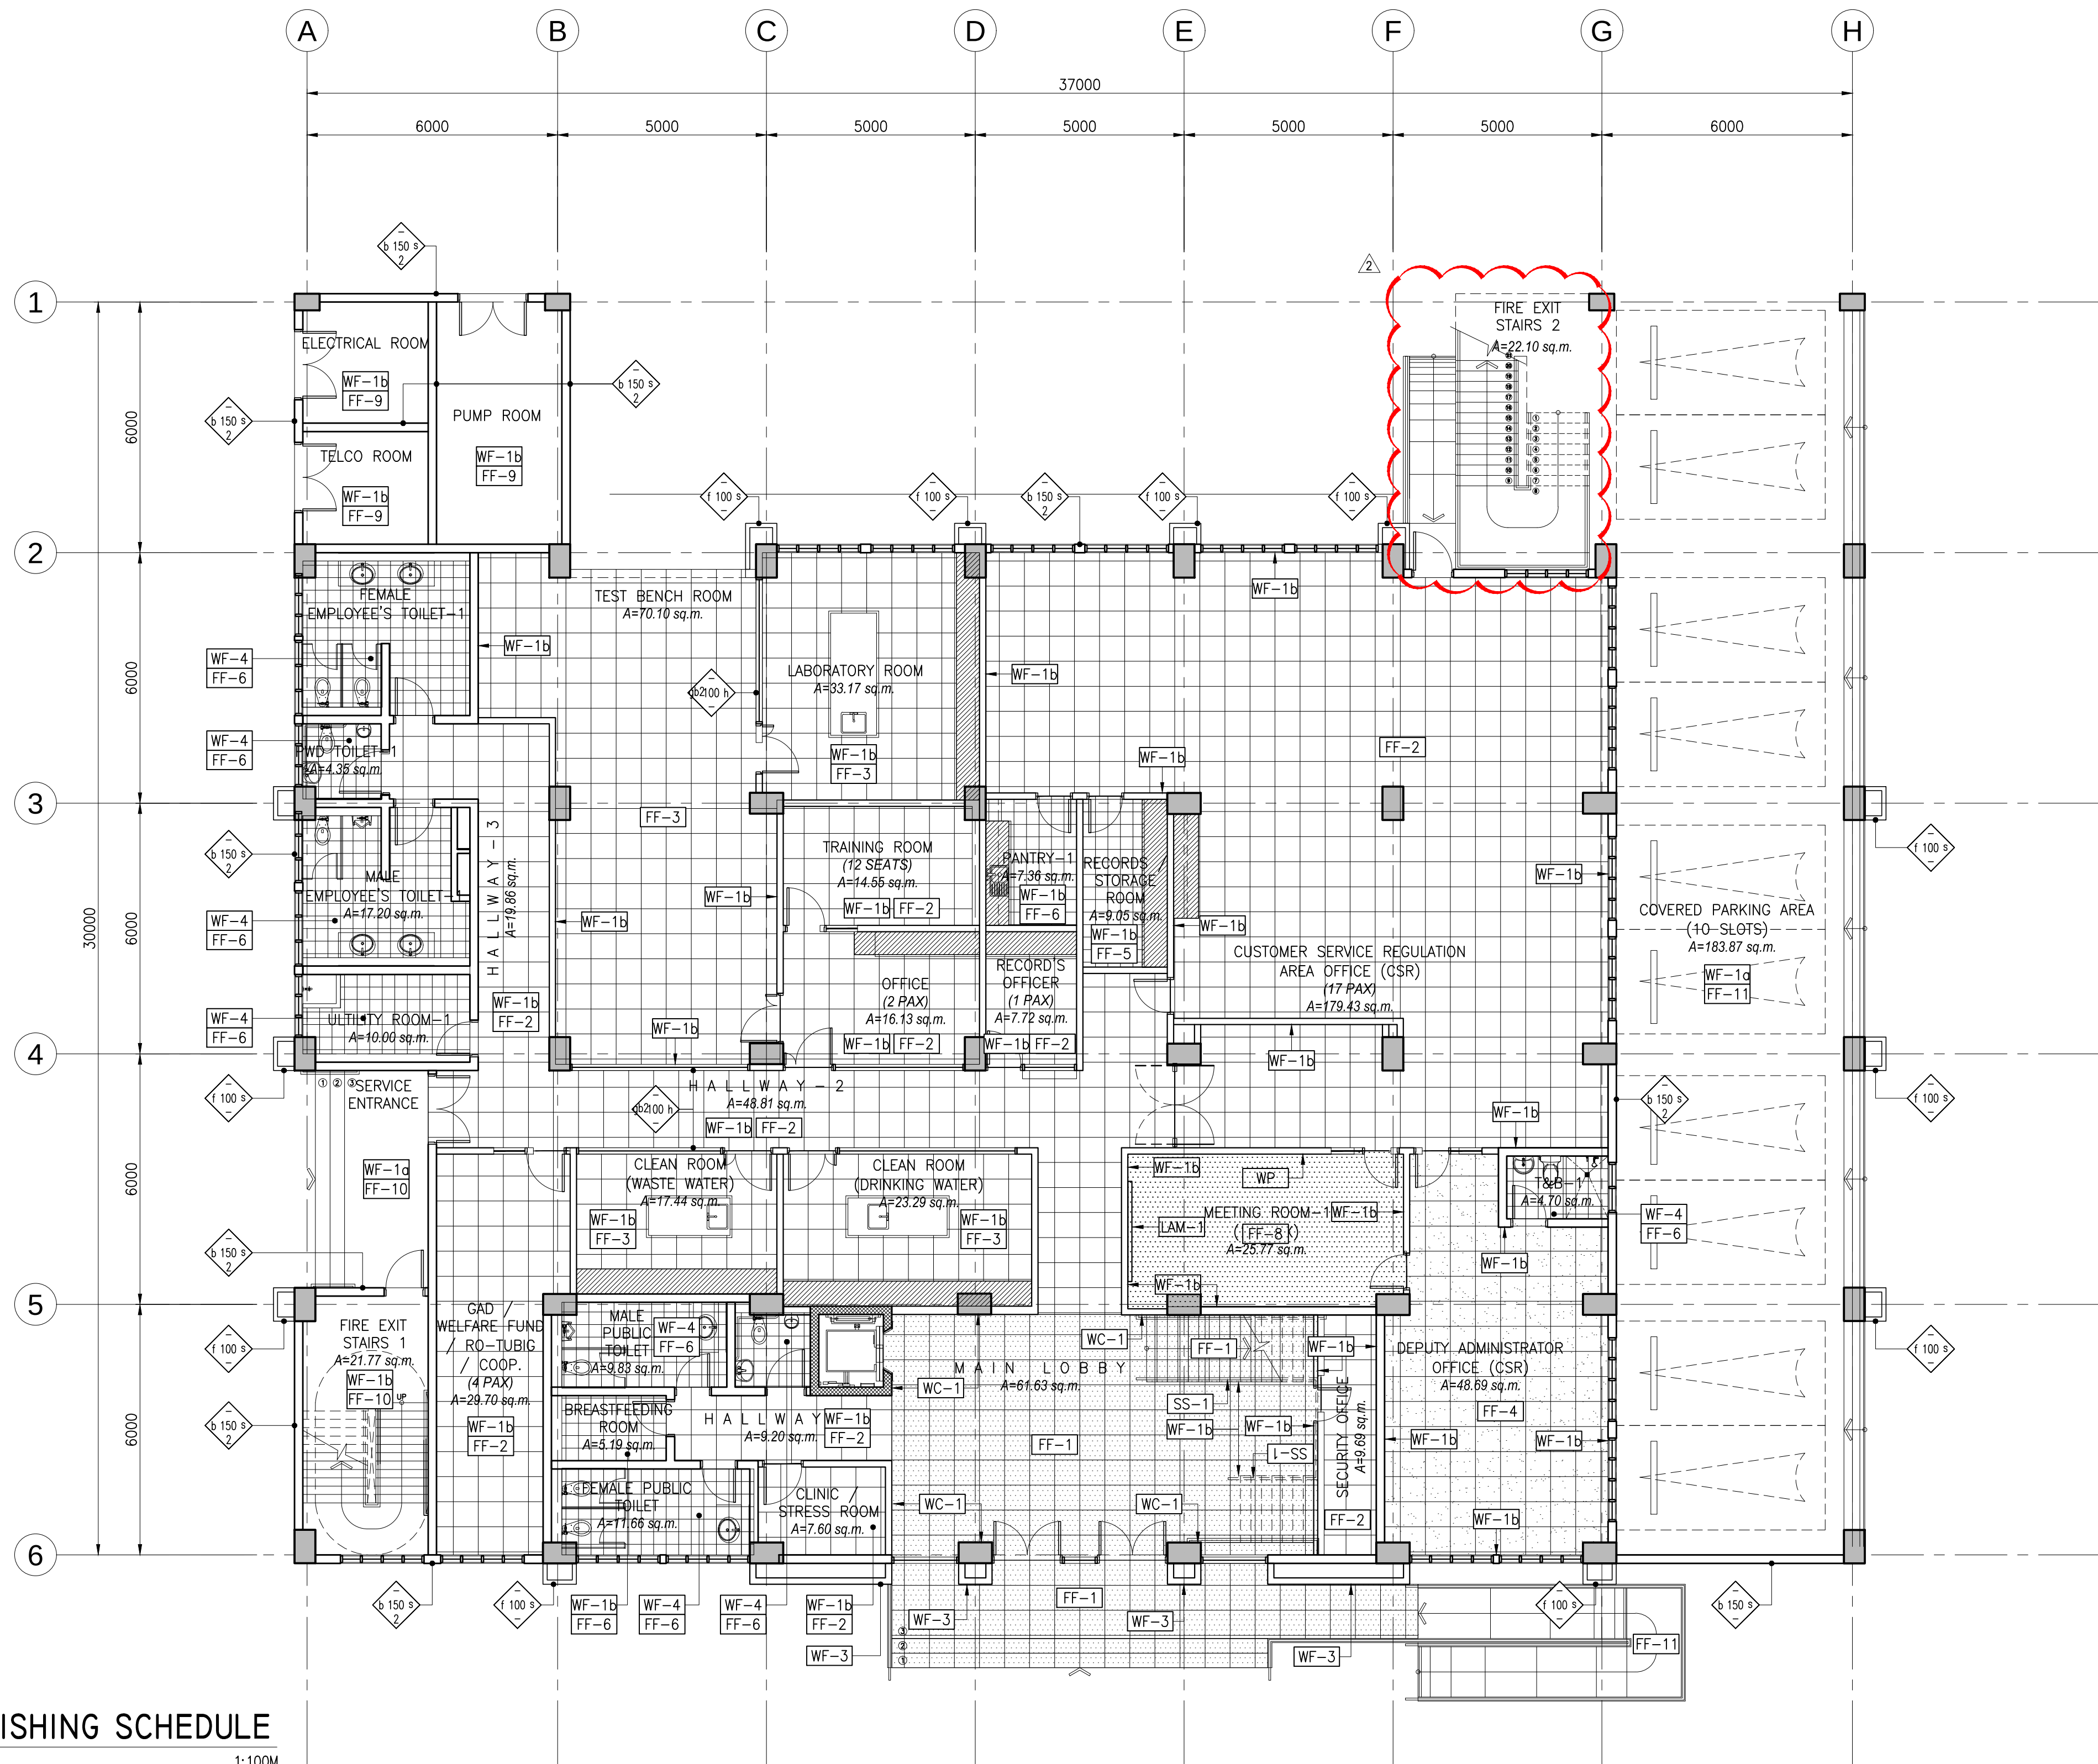


I GROUND FLOOR FINISHING SCHEDULE
SCALE 1:100M

LEGEND	
WALL TYPE DESIGNATOR	
WALL TYPE	WALL HEIGHT
WALL SIZE	FIRE RATING REQUIRED IN HOURS
WALL SIZE - WALL THICKNESS IN MILLIMETER * - AS PER MANUFACTURERS STANDARD	
WALL HEIGHT h = LIMITED HEIGHT AS INDICATED p = TO 200MM ABOVE CEILING s = TO STRUCTURE SLAB	
WALL TYPES b = CONCRETE MASONRY UNIT bp = CONCRETE MASONRY UNIT -PARAPET gb1 = 1 LAYER, DOUBLE SIDE GYPSUM BOARD WITH INSULATION gb2 = 1 LAYER, DOUBLE SIDE GYPSUM BOARD WITHOUT INSULATION f = ACP CLADDING ON TUBULAR STEEL FRAMING	
FIRE RATING 1 = 1 HOUR (60 MIN.) 2 = 2 HOURS (120 MIN.)	
WALL FINISH	
WF-1g	SEMI-GLOSS ACRYLIC LATEX BASED PAINT OVER PRIMER (EXTERIOR-VERIFY COLOR)
WF-1b	SEMI-GLOSS ACRYLIC LATEX BASED PAINT OVER PRIMER (INTERIOR-VERIFY COLOR)
WF-2	ALUMINUM COMPOSITE PANEL
WF-3	STONE ASSEMBLY
WF-4	300MMX300MM CERAMIC TILES (GLAZED)
WC-1	STONE WALL CLADDING
WC-2	FAUX BRICK WALL CLADDING
WP	WALL PAPER (VERIFY DESIGN)
LAM-1	WOOD LAMINATES
MI	MIRROR
SS-1	STAINLESS STEEL AND GLASS STAIR RAILINGS
FLOOR FINISH	
FF-1	19mm THK. SANDBLASTED FIELD GRANITE STONE
FF-2	600MMX600MM HOMOGENEOUS TILES (POLISHED FINISH)
FF-3	600MMX600MM HOMOGENEOUS TILES (MATTE FINISH)
FF-4	600MMX600MM GRANITE TILES
FF-5	300MMX300MM VINYL TILES
FF-6	300MMX300MM HOMOGENEOUS TILES (MATTE FINISH)
FF-7	300MMX300MM ANTI-STATIC VINYL TILES
FF-8	CARPET TILES
FF-9	TROWELLED CONCRETE TOPPING WITH EPOXY FLOOR COATING
FF-10	TROWELLED CONCRETE TOPPING WITH HARDENER AND DUSTPROOFER
FF-11	STRAIGHT TO FINISH FLOORING W/ CONCRETE FLOOR HARDENER
FF-12	RUBBER FLOORING

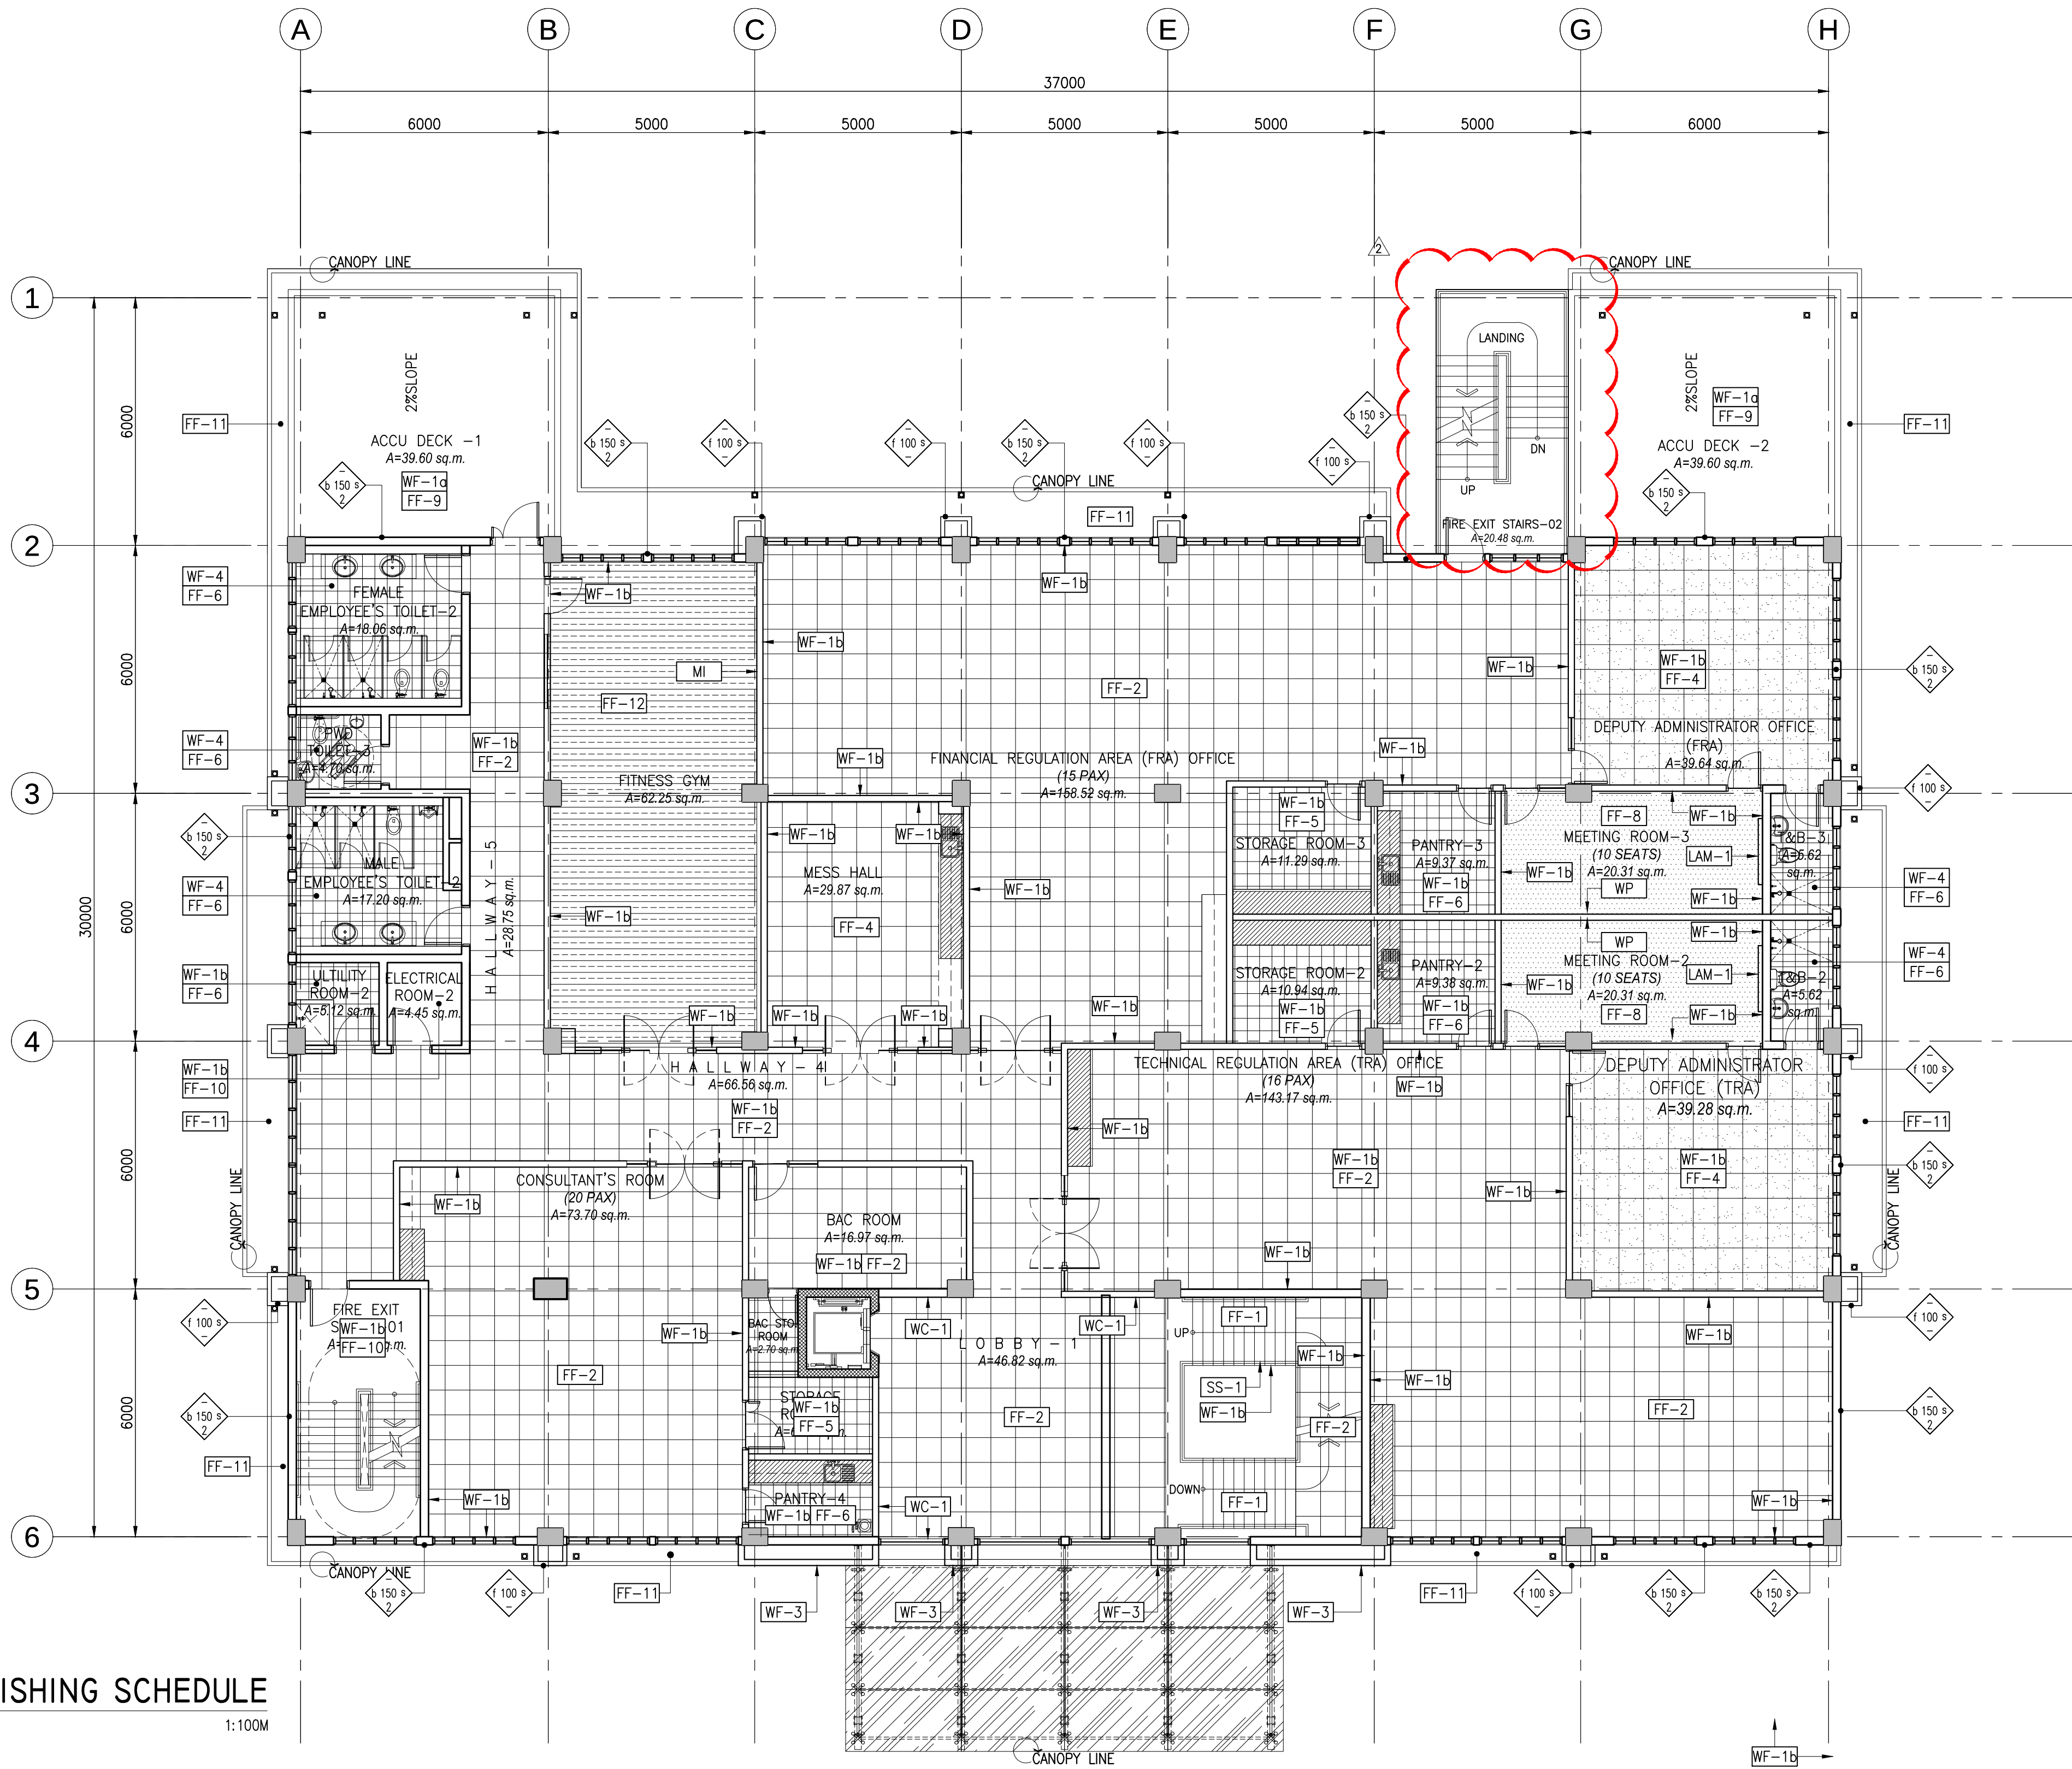

 I SECOND FLOOR FINISHING SCHEDULE
AI-30 SCALE 1:100M

LEGEND	
WALL TYPE DESIGNATOR	
WALL TYPE WALL SIZE WALL HEIGHT FIRE RATING REQUIRED IN HOURS 	
WALL SIZE	
- WALL THICKNESS IN MILLIMETER	
* - AS PER MANUFACTURERS STANDARD	
WALL HEIGHT	
h = LIMITED HEIGHT AS INDICATED	
p = TO 200MM ABOVE CEILING	
s = TO STRUCTURE SLAB	
WALL TYPES	
b = CONCRETE MASONRY UNIT	
bp = CONCRETE MASONRY UNIT -PARAPET	
gb1 = 1 LAYER, DOUBLE SIDE GYPSUM BOARD WITH INSULATION	
gb2 = 1 LAYER, DOUBLE SIDE GYPSUM BOARD WITHOUT INSULATION	
f = ACP CLADDING ON TUBULAR STEEL FRAMING	
FIRE RATING	
1 = 1 HOUR (60 MIN.)	
2 = 2 HOURS (120 MIN.)	


WALL FINISH	
WF-1a	SEMI-GLOSS ACRYLIC LATEX BASED PAINT OVER PRIMER (EXTERIOR-VERIFY COLOR)
WF-1b	SEMI-GLOSS ACRYLIC LATEX BASED PAINT OVER PRIMER (INTERIOR-VERIFY COLOR)
WF-2	ALUMINUM COMPOSITE PANEL
WF-3	STONE ASSEMBLY
WF-4	300MMX300MM CERAMIC TILES (GLAZED)
WC-1	STONE WALL CLADDING
WC-2	FAUX BRICK WALL CLADDING
WP	WALL PAPER (VERIFY DESIGN)
LAM-1	WOOD LAMINATES
MI	MIRROR
SS-1	STAINLESS STEEL AND GLASS STAIR RAILINGS
FLOOR FINISH	
FF-1	19mm THK. SANDBLASTED FIELD GRANITE STONE
FF-2	600MMX600MM HOMOGENEOUS TILES (POLISHED FINISH)
FF-3	600MMX600MM HOMOGENEOUS TILES (MATTE FINISH)
FF-4	600MMX600MM GRANITE TILES
FF-5	300MMX300MM VINYL TILES
FF-6	300MMX300MM HOMOGENEOUS TILES (MATTE FINISH)
FF-7	300MMX300MM ANTI-STATIC VINYL TILES
FF-8	CARPET TILES
FF-9	TROWELLED CONCRETE TOPPING WITH EPOXY FLOOR COATING
FF-10	TROWELLED CONCRETE TOPPING WITH HARDENER AND DUSTPROOFER
FF-11	STRAIGHT TO FINISH FLOORING W/ CONCRETE FLOOR HARDENER
FF-12	RUBBER FLOORING



a.c.o.n.g.
CONSULTING INC.
Engineering + Management
ISO 9001:2015 Certified

2FLTA Building 118 Perea Street, Legaspi Village, 1229 Makati City, Philippines
Tel. Nos. : +63 2 8935827 Fax No. : +63 2 8935829
Email: aconconsulting@aco.com.ph Website: www.aco.com.ph

CERTIFIED BY		OWNER	PROJECT TITLE/LOCATION	CLIENT		SHEET CONTENTS	R.A. 9266 SEC. 33	CADD	DATE	NO.	REVISIONS	CHK	DATE	PAPER SIZE	SHEET NO.	
MICHELANGELA O. SALVADOR, UAP ARCHITECT	REG. NO.: 0021601	METROPOLITAN WATERWORKS AND SEWERAGE SYSTEM REGULATORY OFFICE	3-STOREY OFFICE BUILDING WITH ROOF DECK	PROJECT PROPOSER	APPROVED BY:	THIRD FLOOR FINISHING SCHEDULE	DRAWINGS AND SPECIFICATIONS AND CONTRACT DOCUMENTS DULY SIGNED, STAMPED OR SEALED AS INSTRUMENTS FOR SERVICE ARE THE INTELLECTUAL PROPERTY AND DOCUMENTS OF ARCHITECT, WHETHER THE OBJECT FOR WHICH THEY ARE MADE IS EXECUTED OR NOT; IT SHALL BE UNLAWFUL FOR ANY PERSON TO DUPLICATE OR TO MAKE COPIES OF SAID DOCUMENTS FOR USE IN THE REPLICATION OF AND FOR OTHER PROJECTS OR BUILDINGS, WHETHER EXECUTED PARTLY OR IN WHOLE, WITHOUT THE WRITTEN CONSENT OF THE ARCHITECT OR AUTHOR OF SAID DOCUMENTS.	GMT/NBR/SCEH	JUL 2018					20X30	AI-303	
	TIN NO. : 271--680--669--000				DESIGNED			DATE								
	PTR NO. : 6679972				JDEC			JUL 2018								
	DATE : 2/8/2018	MWSS COMPOUND, KATIPUNAN AVENUE, MATANDANG BALARA, QUEZON CITY	MWSS COMPOUND, KATIPUNAN AVENUE, MATANDANG BALARA, QUEZON CITY	MELCHOR S. CORDOVA	PATRICK LESTER N. TY				APPROVED	DATE		ADDITIONAL FIRE EXIT STAIRS	10-30-2018		AS SHOWN	SO-G-17-036
	PLACE : MAKATI CITY			ALTERNATE END-USUR FOR RO BUILDING	CHIEF REGULATOR, MWSS RO				MOS	JUL 2018	1	SCHEMATIC DESIGN	03-09-2018			

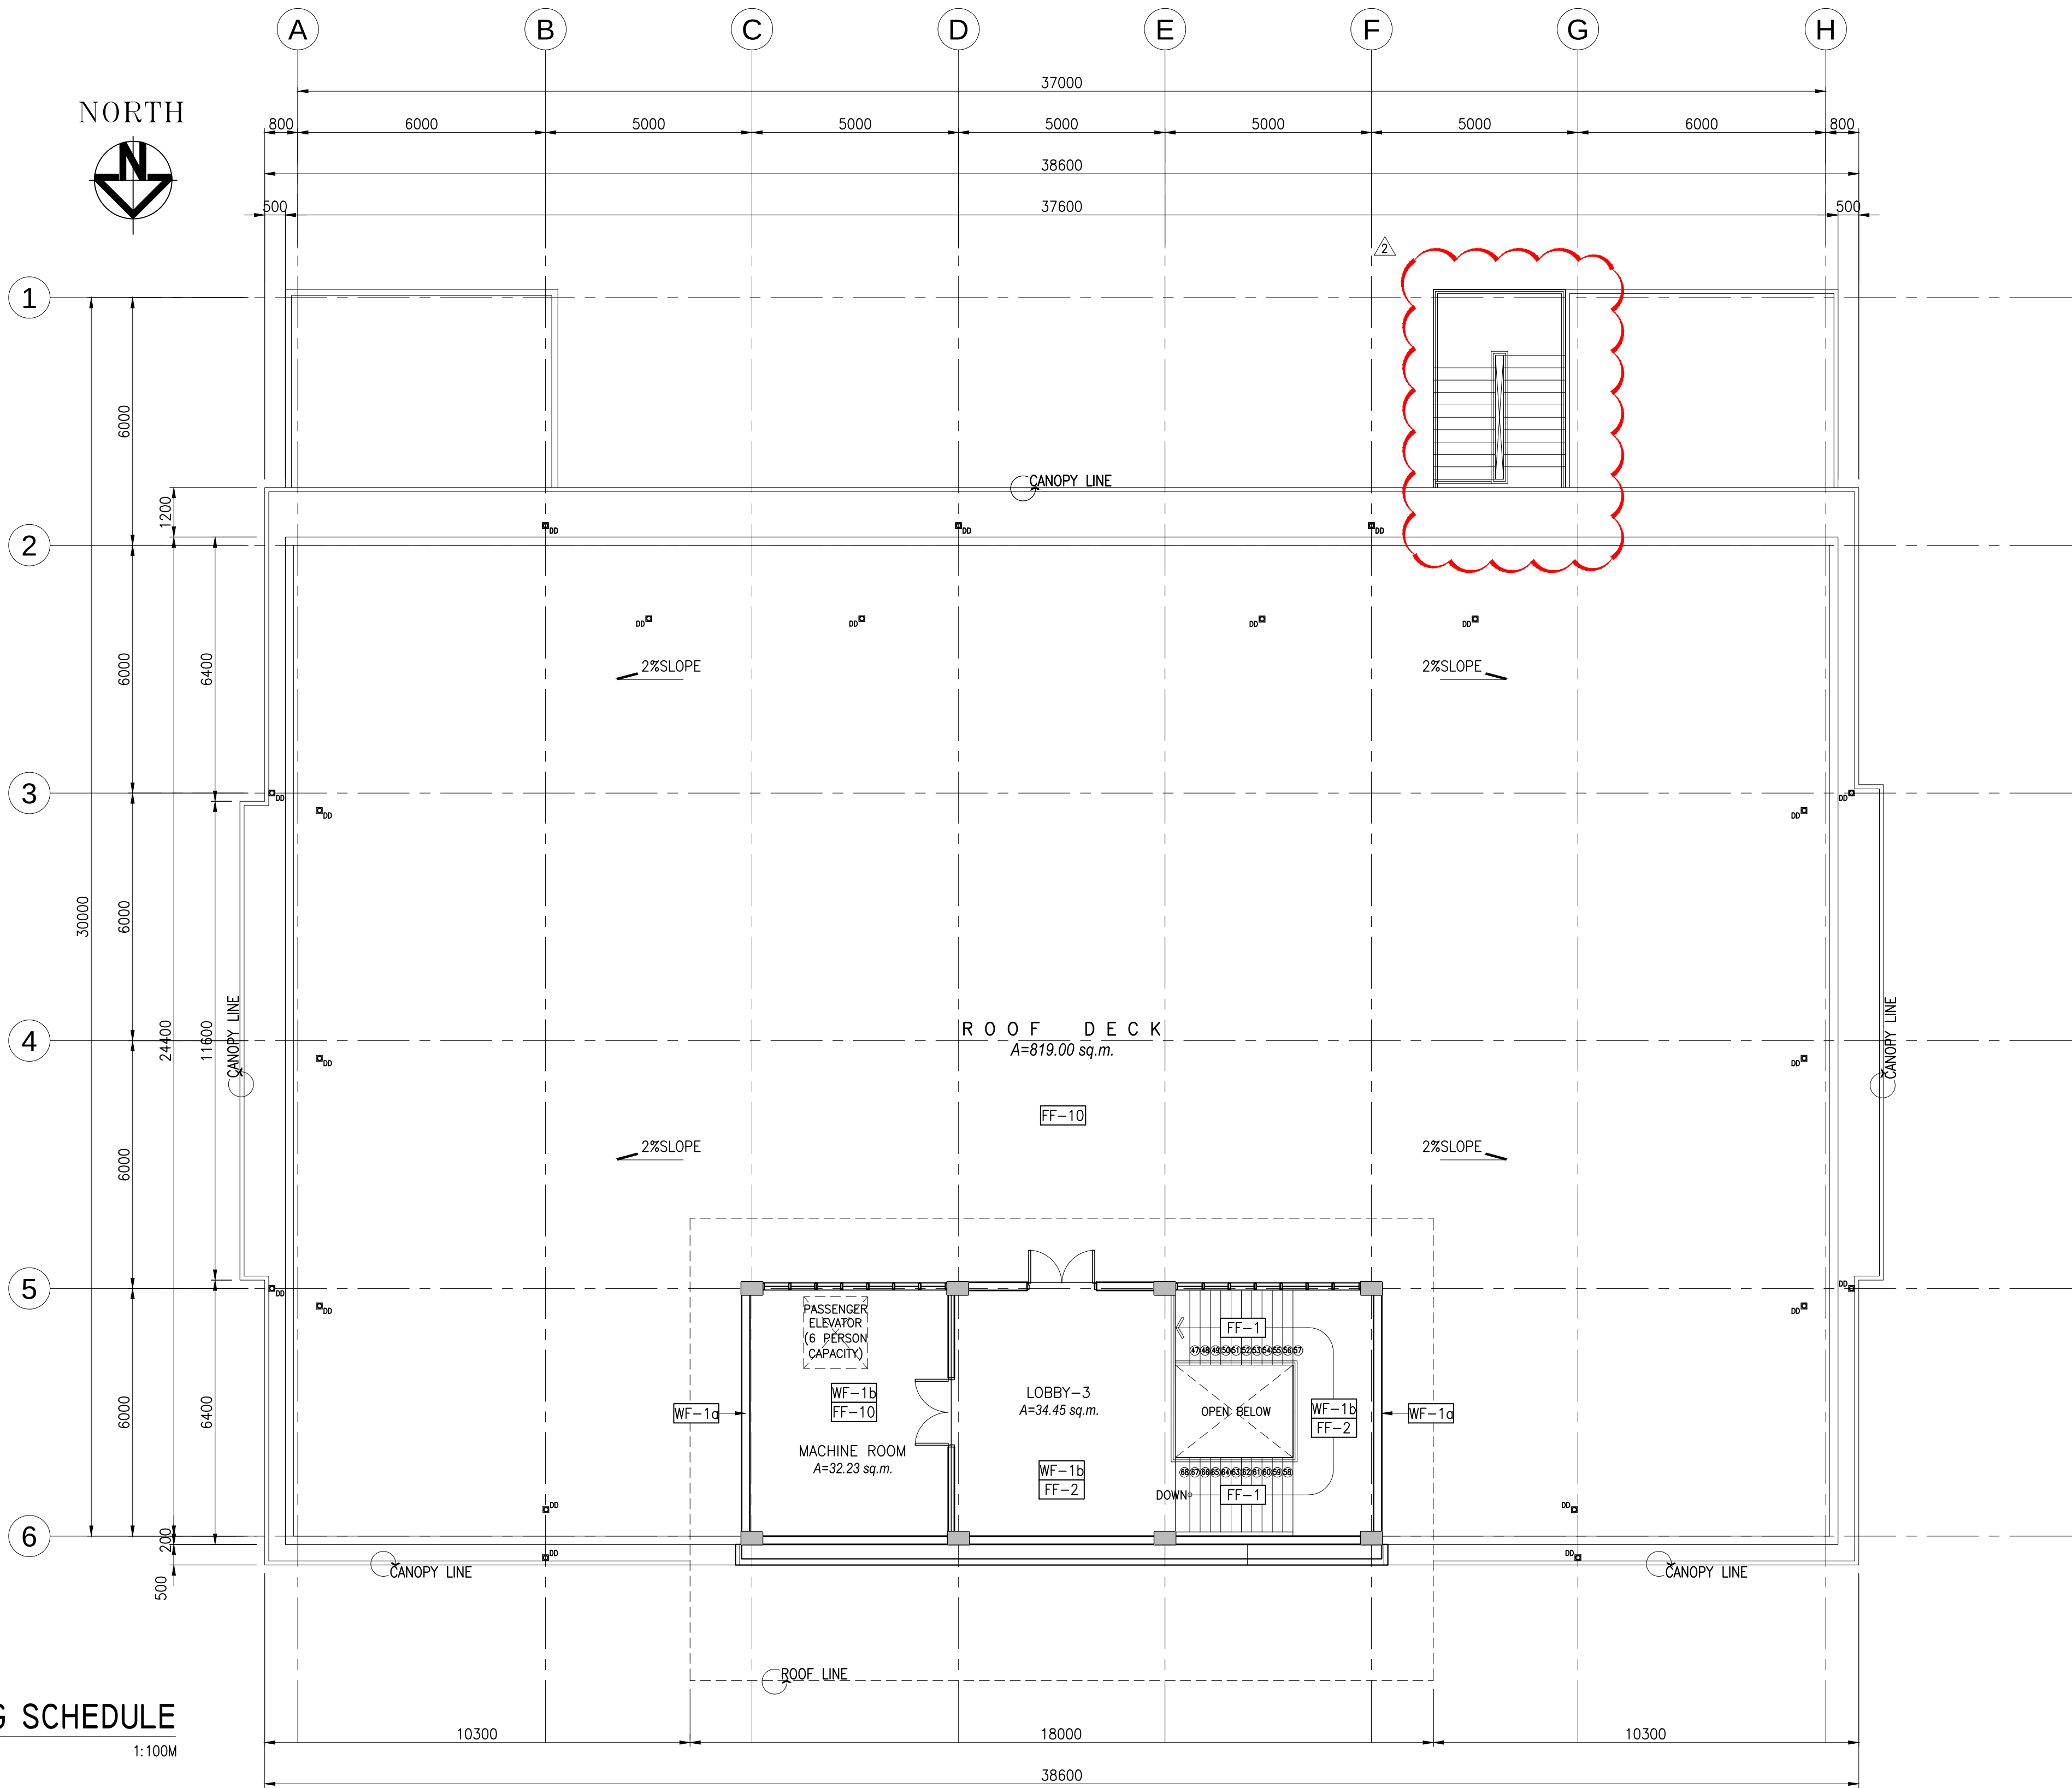

FLOOR AREA = 916.94 SQ. M.

ROOF DECK FINISHING SCHEDULE

SCALE

1:100M



CERTIFIED BY		OWNER	PROJECT TITLE/LOCATION	CLIENT	SHEET CONTENTS	R.A. 9266 SEC. 33		CADD	DATE	NO.	REVISIONS	CHK	DATE	PAPER SIZE	SHEET NO.
MICHELANGELA O. SALVADOR, UAP	REG. NO.: 0021801	METROPOLITAN WATERWORKS AND SEWERAGE SYSTEM REGULATORY OFFICE	3-STOREY OFFICE BUILDING WITH ROOF DECK	PROJECT PROPONENT	APPROVED BY:	DRAWINGS AND SPECIFICATIONS AND CONTRACT DOCUMENTS DULY SIGNED, STAMPED OR SEALED AS INSTRUMENTS FOR SERVICE ARE THE INTELLECTUAL PROPERTY AND DOCUMENTS OF ARCHITECT, WHETHER THE OBJECT FOR WHICH THEY ARE MADE IS EXECUTED OR NOT. IT SHALL BE UNLAWFUL FOR ANY PERSON TO DUPLICATE OR TO MAKE COPIES OF SAID DOCUMENTS FOR USE IN THE REPETITION OF AND FOR OTHER PROJECTS OR BUILDINGS, WHETHER EXECUTED PARTLY OR IN WHOLE, WITHOUT THE WRITTEN CONSENT OF THE ARCHITECT OR AUTHOR OF SAID DOCUMENTS.	GMT/NBR/SC/EH	DESIGNED	JUL 2018					20X30	AI-304
	IAPOA : 17156228123072318								DATE						
	TIN NO. : 271-680-669-000							JDEC	JUL 2018					SCALE	PROJECT NO.
	PTR NO. : 6679972	MWSS COMPOUND, KATIPUNAN AVENUE, MATANDANG BALARA, QUEZON CITY	MWSS COMPOUND, KATIPUNAN AVENUE, MATANDANG BALARA, QUEZON CITY	MELCHOR S. CORDOVA ALTERNATE END-USER FOR RO BUILDING	PATRICK LESTER N. TY CHIEF REGULATOR, MWSS RO			APPROVED	DATE	2	ADDITIONAL FIRE EXIT STAIRS	10-30-2018	03-09-2018	AS SHOWN	SO-G-17-036
ARCHITECT	PLACE : MAKATI CITY							MOS	JUL 2018	1	SCHEMATIC DESIGN				